



TOTAL SHEETS	SHEET NO.
559	231

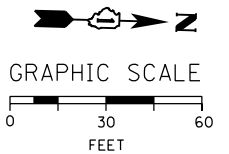

NEW 11,205 WATTS
OLD 10,523 WATTS
ATLAS NO. N-23
GROUP NO. 12
(30) 341 WATT HPS @ 240V
(5) 195 WATT HPS @ 240V

c:\pwworking\acom00\myer-sc\d0207895\DIG0WZ6-sht-Light-08.dgn
8/16/2013 8:21:49 AM

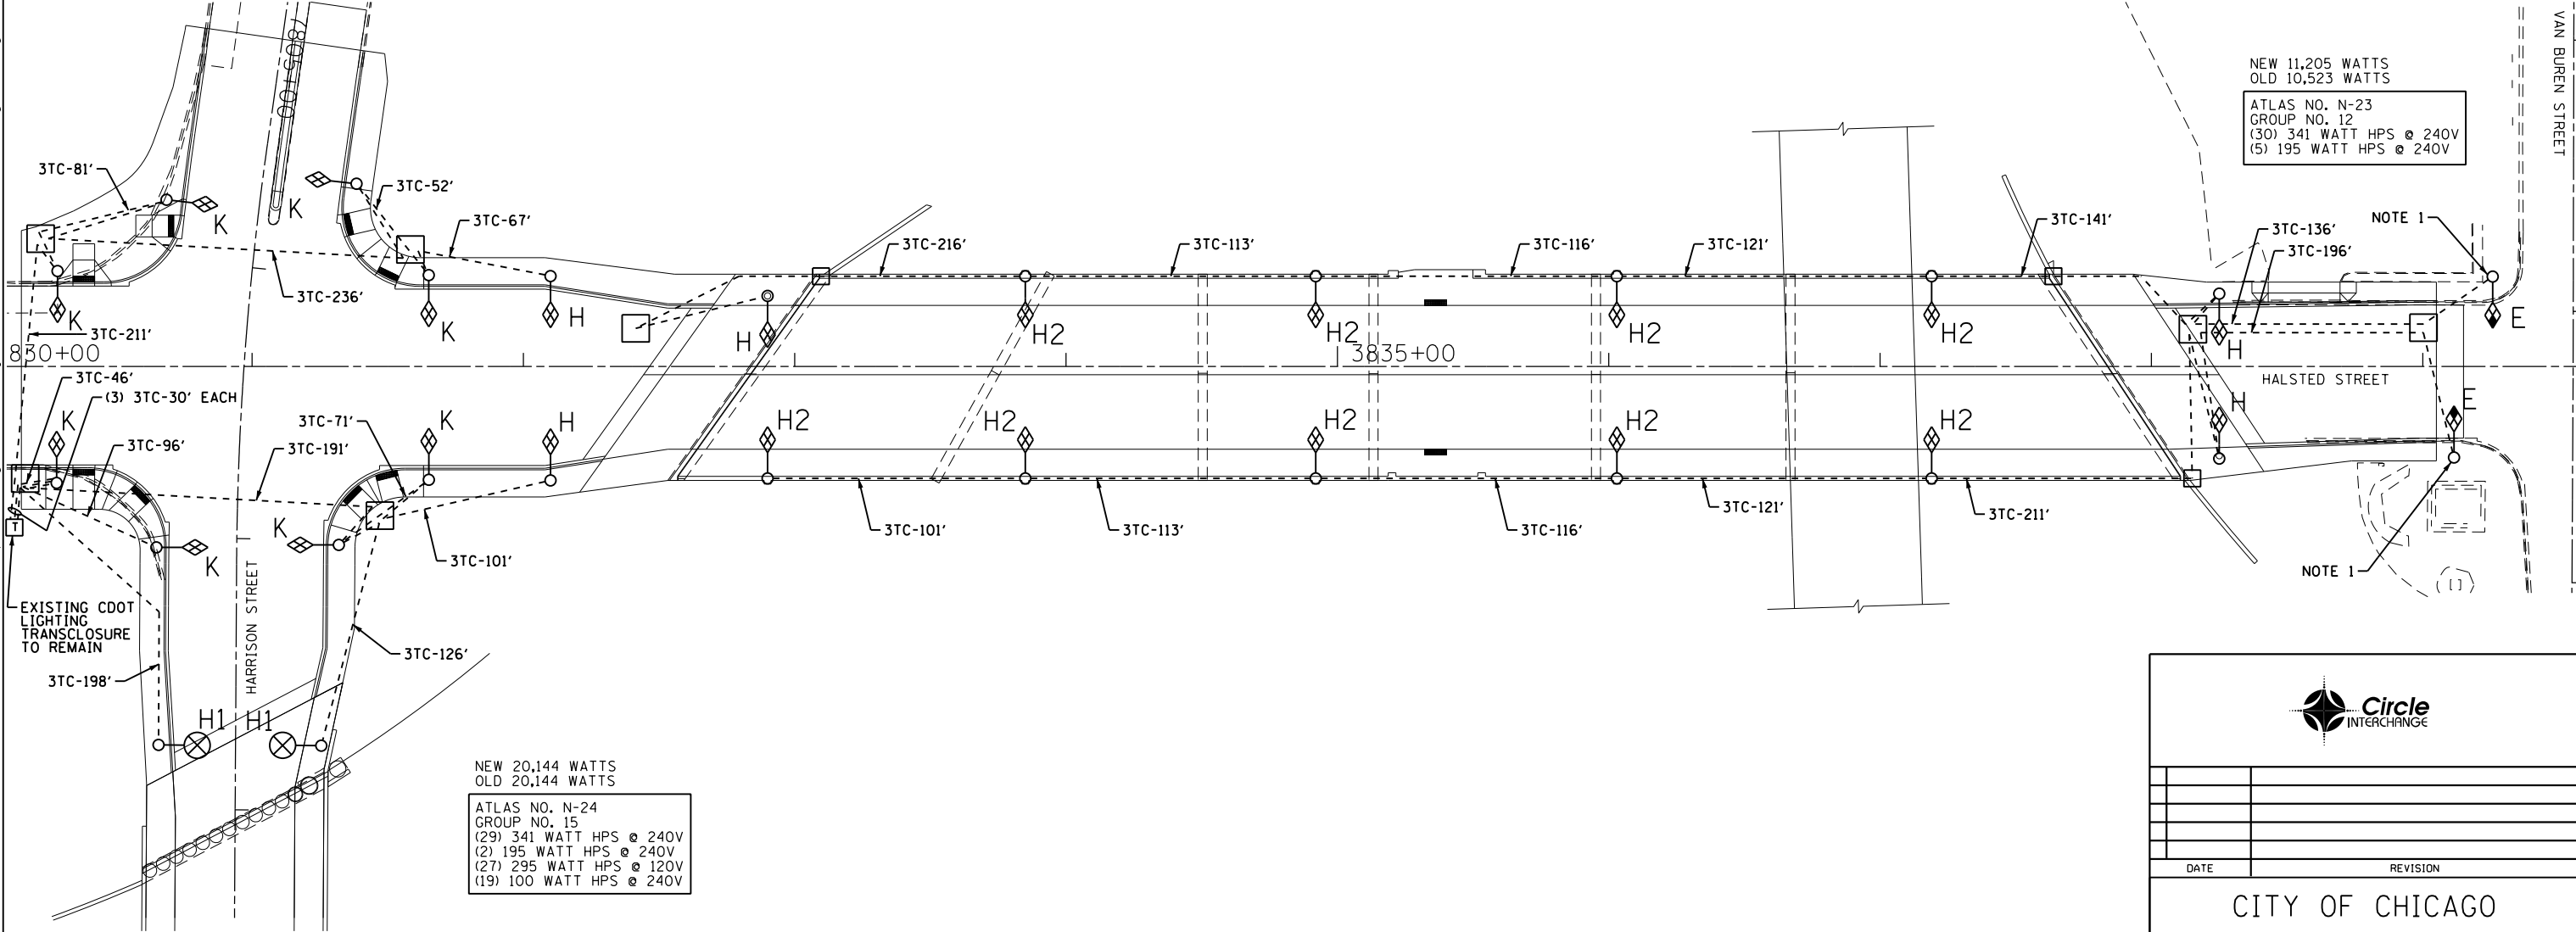

NEW 20,144 WATTS
OLD 20,144 WATTS
ATLAS NO. N-24
GROUP NO. 15
(29) 341 WATT HPS @ 240V
(2) 195 WATT HPS @ 240V
(27) 295 WATT HPS @ 120V
(19) 100 WATT HPS @ 240V

NOTES:

1. SPLICE NEW CABLES TO EXISTING LIGHTING CIRCUITS LOCATED IN EXISTING POLE.

- "H" INSTALL CDOT FURNISHED STEEL POLE, LUMINAIRE, MAST ARM, POLE BASE, FINIAL AND ALL ASSOCIATED COMPONENTS PER DRAWING NOS. 930, 930A, 930B, 930C AND 931.
- "H1" INSTALL CDOT FURNISHED STEEL POLE, LUMINAIRE, MAST ARM AND BALLAST HOUSING BASE PER DRAWING NOS. 808 AND 785.
- "H2" INSTALL CDOT FURNISHED "RETROFIT" LIGHTING UNIT INCLUDING STEEL POLE, MAST ARM, LUMINAIRE AND ALL ASSOCIATED COMPONENTS PER DRAWING NOS. 762, 837 AND 931.
- "K" INSTALL CDOT FURNISHED MAST ARM AND LUMINAIRE ON A TRAFFIC SIGNAL/LIGHT COMBINATION POLE PER DRAWING NOS. 930, 930C AND 931. SEE TRAFFIC SIGNAL PLANS FOR POLE LOCATIONS.

FOR CONDUIT AND FOUNDATION PLANS SEE DRAWING NOS. E-07 AND E-10.
FOR LIGHTING REMOVAL PLANS SEE DRAWING NO. E-09.

DATE	REVISION
CITY OF CHICAGO	
DEPARTMENT OF TRANSPORTATION DIVISION OF ENGINEERING	
CONSULTANT: AECOM	
WORK ORDER NO. _____	DATE _____
COST ALLOCATION ACCOUNT _____	
APPROPRIATION ACCOUNT _____	MATERIAL _____ LABOR _____
HALSTED STREET LIGHTING CABLE AND EQUIPMENT INSTALLATION PLAN	
CITY OF CHICAGO DEPT. OF TRANSPORTATION DIVISION OF ELECTRICAL OPERATIONS	
DRAFTSMAN: CAM	CHIEF DRAFTSMAN: WDS
SUPERVISING ENGINEER: WDS	ENGINEER: WDS
ENGINEER OF ELECTRICITY:	E-08
GEN'L SUPT. OF ELECTRICITY:	
DEPUTY COMMISSIONER:	
SIZE: 22" 34"	SCALE: 1" = 30'
DATE: 08/20/13	DATE: 8/20/13
C.D.O.T. PROJECT NO.:	DWG. NO.: 8 OF 22