


FILE PATH = p:\388035\pmt\escomonline\local\AECOM\Documents\01\_Americas\Transportation\6269938\_Circle\Phase\_1\000\_CAD\01E\_Electrical\Sheets\60W26\_Contract\DI60W26-sht-Light-14

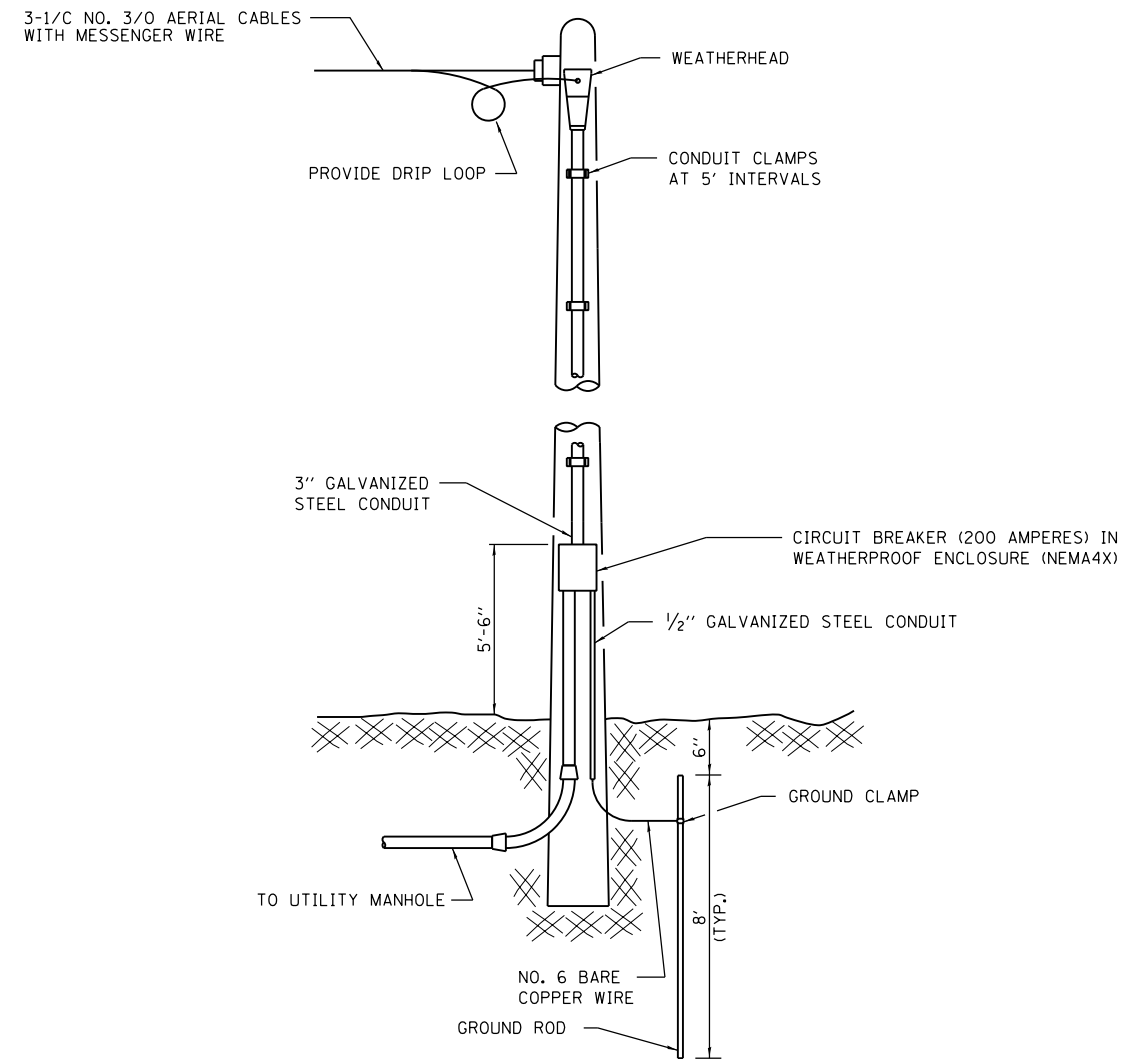

TEMPORARY ELECTRICAL SERVICE  
 INSTALLATION DETAILS  
 SCALE: NOT TO SCALE



DI60W26-sht-Light-14  
 USER NAME = myersc  
 PLOT SCALE = 1:8000' / in.  
 PLOT DATE = 8/15/2013

DESIGNED - WDS	REVISED -
DRAWN - CAM	REVISED -
CHECKED - WDS	REVISED -
DATE - 8/20/13	REVISED -

STATE OF ILLINOIS  
 DEPARTMENT OF TRANSPORTATION

MISCELLANEOUS ELECTRICAL DETAILS

SCALE: N.T.S. SHEET 14 OF 22 SHEETS STA. TO STA.

F.A.I. RTE.	SECTION	COUNTY	TOTAL SHEETS	SHEET NO.
90/94/290	2013-008R	COOK	559	237
CONTRACT NO. 60W26				
ILLINOIS FED. AID PROJECT				