



**AERIAL CABLE CONNECTION DETAIL**  
N.T.S.

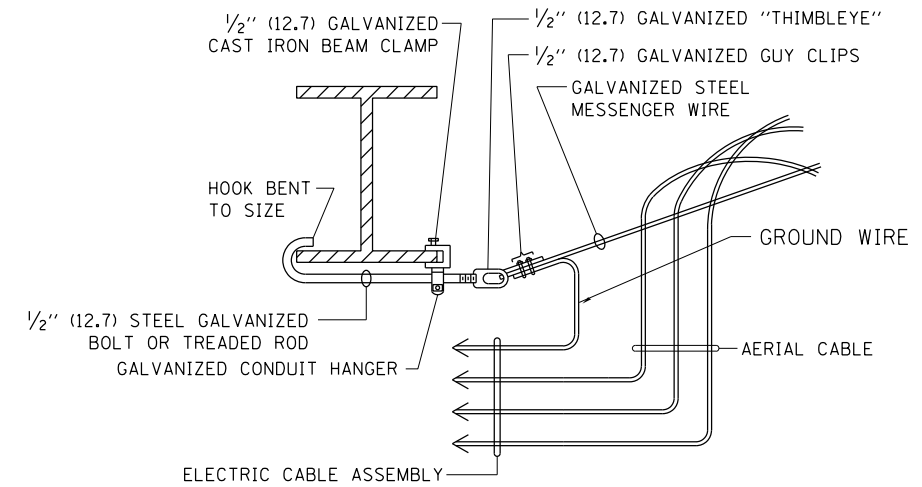

**AERIAL CABLE ATTACHED TO STRUCTURE**  
NOT TO SCALE

**NOTES:**

1. ALL DIMENSIONS IN INCHES (MILLIMETERS) UNLESS OTHERWISE INDICATED.
2. SEE PROPOSED LIGHTING PLAN FOR CONDUIT, CABLE AND ROUTING.
3. THE CONTRACTOR SHALL PROVIDE INTERMEDIATE SUPPORTS TO MAINTAIN MINIMUM CLEARANCES. REFER TO AERIAL AERIAL CABLE ATTACHED TO STRUCTURE DETAIL.
4. COST OF SPLICES AND MOUNTING HARDWARE SHALL BE INCLUDED IN THE UNIT PRICE FOR AERIAL CABLE.

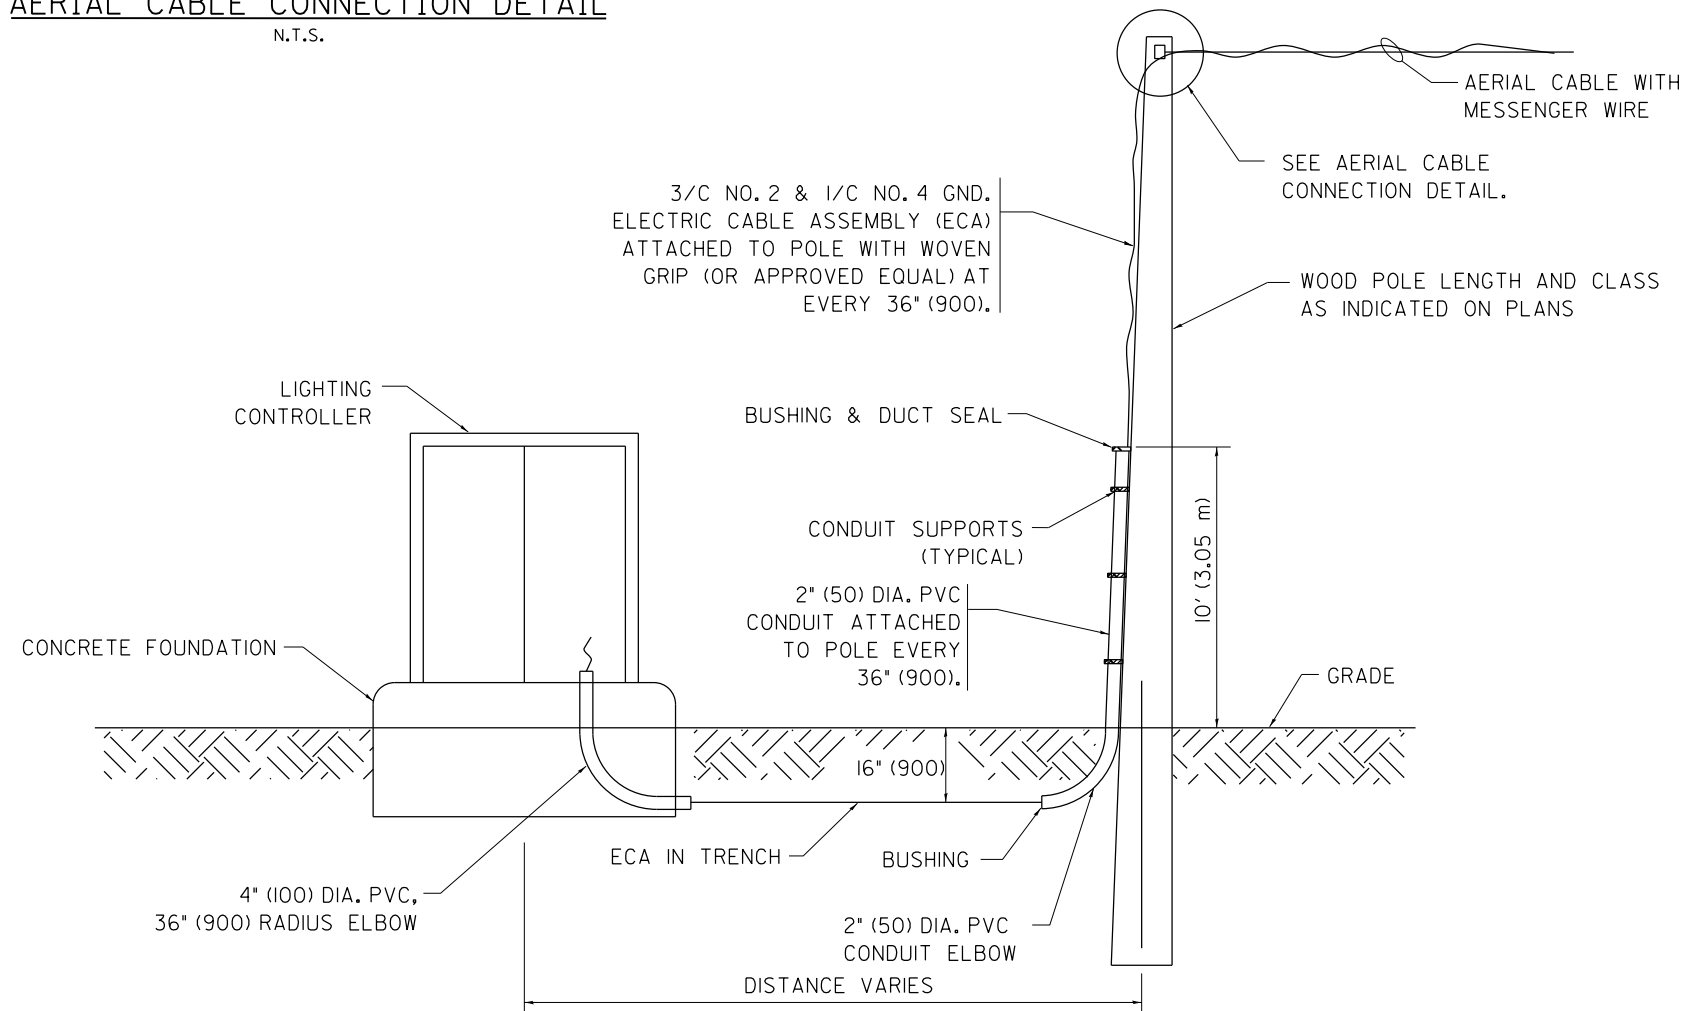

**WOOD POLE TO LIGHTING CONTROLLER WIRING CONNECTION DETAIL**  
N.T.S.

FILE NAME =	USER NAME = ougeungh	DESIGNED -	REVISED - 08-08-03	<b>STATE OF ILLINOIS DEPARTMENT OF TRANSPORTATION</b>	<b>TEMPORARY AERIAL CABLE INSTALLATION</b>			F.A.I. RTE.	SECTION	COUNTY	TOTAL SHEETS	SHEET NO.
pw:\388039-pwintl\ecomon\lne.local\pwaecom\Documents\01 Americas\Transportation\400000\Drawings\CAD\006\Road\60W26\Contract\DI60W26-SHT-DI	Drawn CirclePhase.II\000.CAD\006.Road\60W26.Contract\DI60W26-SHT-DI	CHECKED -	REVISED -		SCALE: NONE	SHEET NO. 13 OF 27 SHEETS	STA.	TO STA.	2013-008R	COOK	559	473
PLOT SCALE = 50.000' / in.	CHECKED -	REVISED -	REVISED -		<b>BE-801</b>			<b>CONTRACT NO. 60W26</b>				
PLOT DATE = 8/18/2013	DATE -	REVISED -	REVISED -		FED. ROAD DIST. NO. 1 ILLINOIS FED. AID PROJECT							