
 


LEGEND

- 2" UD, W/7*6 & 1*6 GND □ EXISTING COM ED POWER POLE
- 3" C, W/2" UD □ SERVICE PEDESTAL
- UD — 2" UNIT DUCT 7*6 & 1*6 GROUND (UNLESS NOTED OTHERWISE)
- PC — 3" CONDUIT, PUSHED LENGTH AS SHOWN WITH 2" UNIT DUCT OR AS NOTED
- A — EXISTING AERIAL UTILITY
- PROPOSED ORNAMENTAL STREET LIGHT, SINGLE TEARDROP FIXTURE, HPS, 250 WATT, 240 VOLT, TYPE IV, 36.5' M.H.
- PROPOSED ORNAMENTAL STREET LIGHT UNIT, COMPLETE, HPS, 150 WATT, 240 VOLT, TYPE IV, 36.5' M.H.
- PROPOSED ORNAMENTAL STREET LIGHT, SINGLE ACORN FIXTURE, HPS, 35 WATT, 120 VOLT, TYPE III, 15.5' M.H.
- EXISTING STREET LIGHT, 400W, MERCURY VAPOR, 30' MH
- PROPOSED LIGHTING CONTROLLER
- PROPOSED HANDHOLE
- EXISTING HANDHOLE
- EXISTING LIGHTING CONTROLLER
- SB SETBACK FROM BACK OF CURB
- ⌚ DUPLEX RECEPTACLE, 120V, 20A

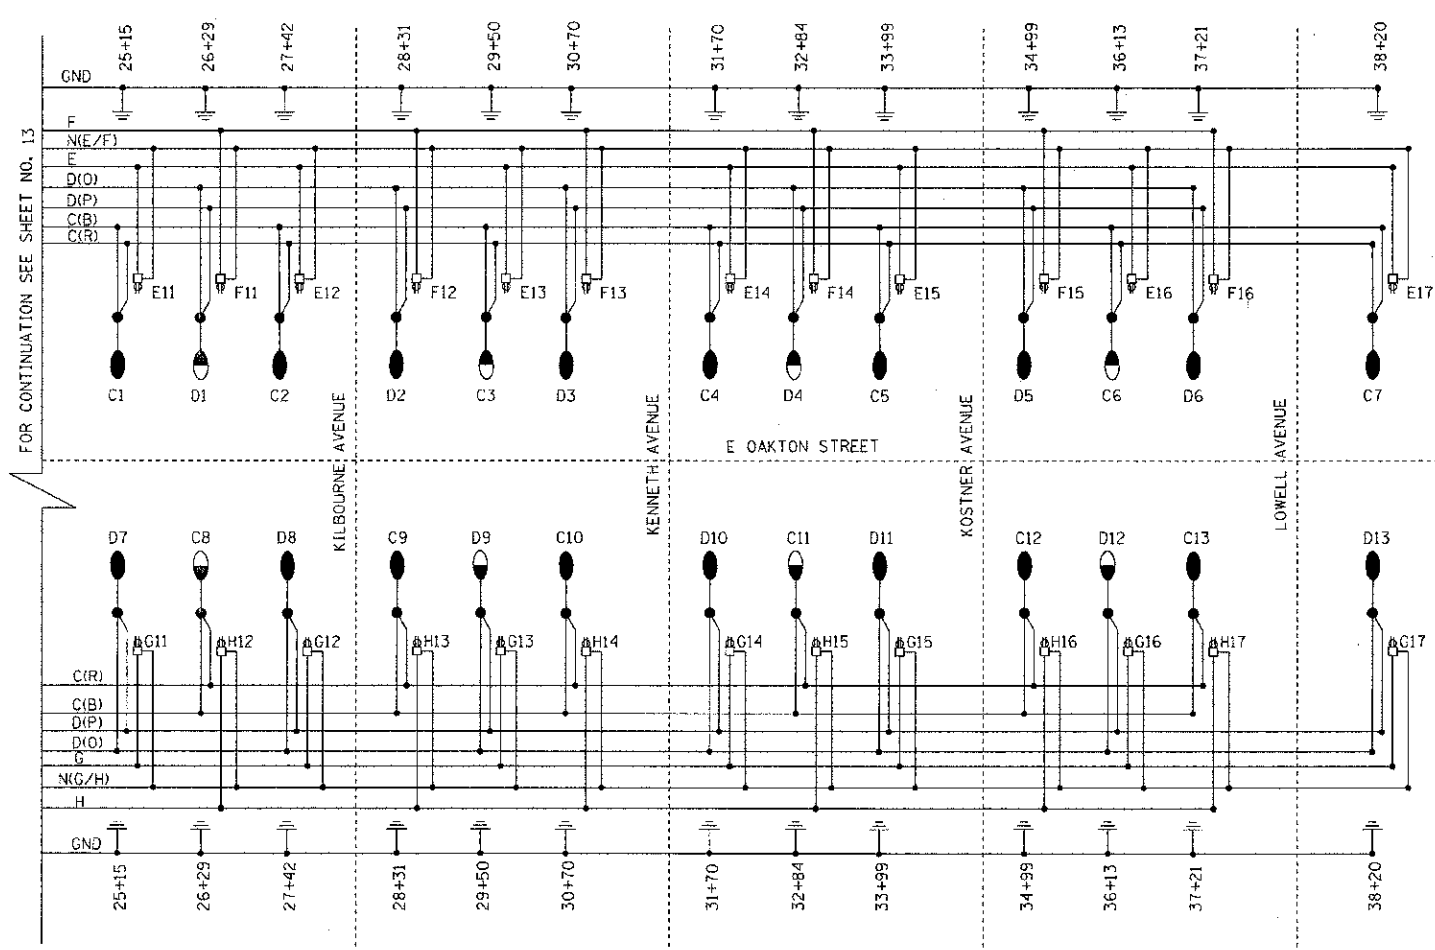

FOR CONTINUATION SEE SHEET NO. 13



CONSULT: CHIEF ENGINEER, BAXTER & WOODMAN, INC. 1100 W. JACKSON ST., CHICAGO, IL 60606
 DRAWN: MAC
 CHECKED: OSW
 DATE: 5-14-12
 FILE: 100791-SL-single_line.sht



DESIGNED - MWH	REVISED -
DRAWN - MAC	REVISED -
CHECKED - OSW	REVISED -
DATE - 5-14-12	FILE - 100791-SL-single_line.sht

VILLAGE OF SKOKIE, ILLINOIS
F.A.U. ROUTE 1332 E. OAKTON STREET
FROM F.A.P. 350 U.S. ROUTE 41 (SKOKIE BOULEVARD) TO LOWELL AVENUE
STREETSCAPE IMPROVEMENTS

STREET LIGHTING - SINGLE LINE DIAGRAM
 SCALE: _____ STA. _____ TO STA. _____

F.A.U. RTE. 1332	SECTION 11-Q0286-CO-LS	COUNTY COOK	TOTAL SHEETS 29	SHEET NO. 14
C-91-145-17			CONTRACT NO. 63737	
FED. ROAD DIST. NO. 1 (ILLINOIS)			FED. AID PROJECT TE-0001889	