
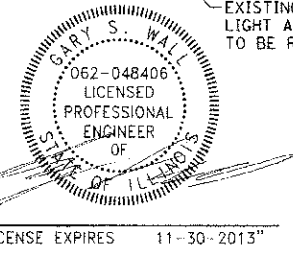


LEGEND

- 2" UD, W/7*6 & 1*6 GND
- 3" C, W/2" UD
- A-
- PROPOSED ORNAMENTAL STREET LIGHT, SINGLE TEARDROP FIXTURE, HPS, 250 WATT, 240 VOLT, TYPE IV, 36.5' M.H.
- PROPOSED ORNAMENTAL STREET LIGHT UNIT, COMPLETE, HPS, 150 WATT, 240 VOLT, TYPE IV, 36.5' M.H.
- PROPOSED ORNAMENTAL STREET LIGHT, SINGLE ACORN FIXTURE, HPS, 35 WATT, 120 VOLT, TYPE III, 15.5' M.H.
- EXISTING STREET LIGHT, 400W, MERCURY VAPOR, 30' MH
- PROPOSED LIGHTING CONTROLLER
- PROPOSED HANDHOLE
- EXISTING HANDHOLE
- EXISTING LIGHTING CONTROLLER
- SB
- DUPLEX RECEPTACLE, 120V, 20A

- NOTES:**
- 1) THE LIGHTING SYSTEM SHALL BE CONSTRUCTED IN PHASES. LIGHTING SHALL BE MAINTAINED OPERATIONAL ON ONE SIDE OF THE ROAD AS THE OPPOSITE SIDE IS BEING CONSTRUCTED.
 - 2) WEST CIRCUITS USE 2" UD W/5*6, 3*4 & *4GND
EAST CIRCUITS USE 2" UD W/7*6 & *6GND

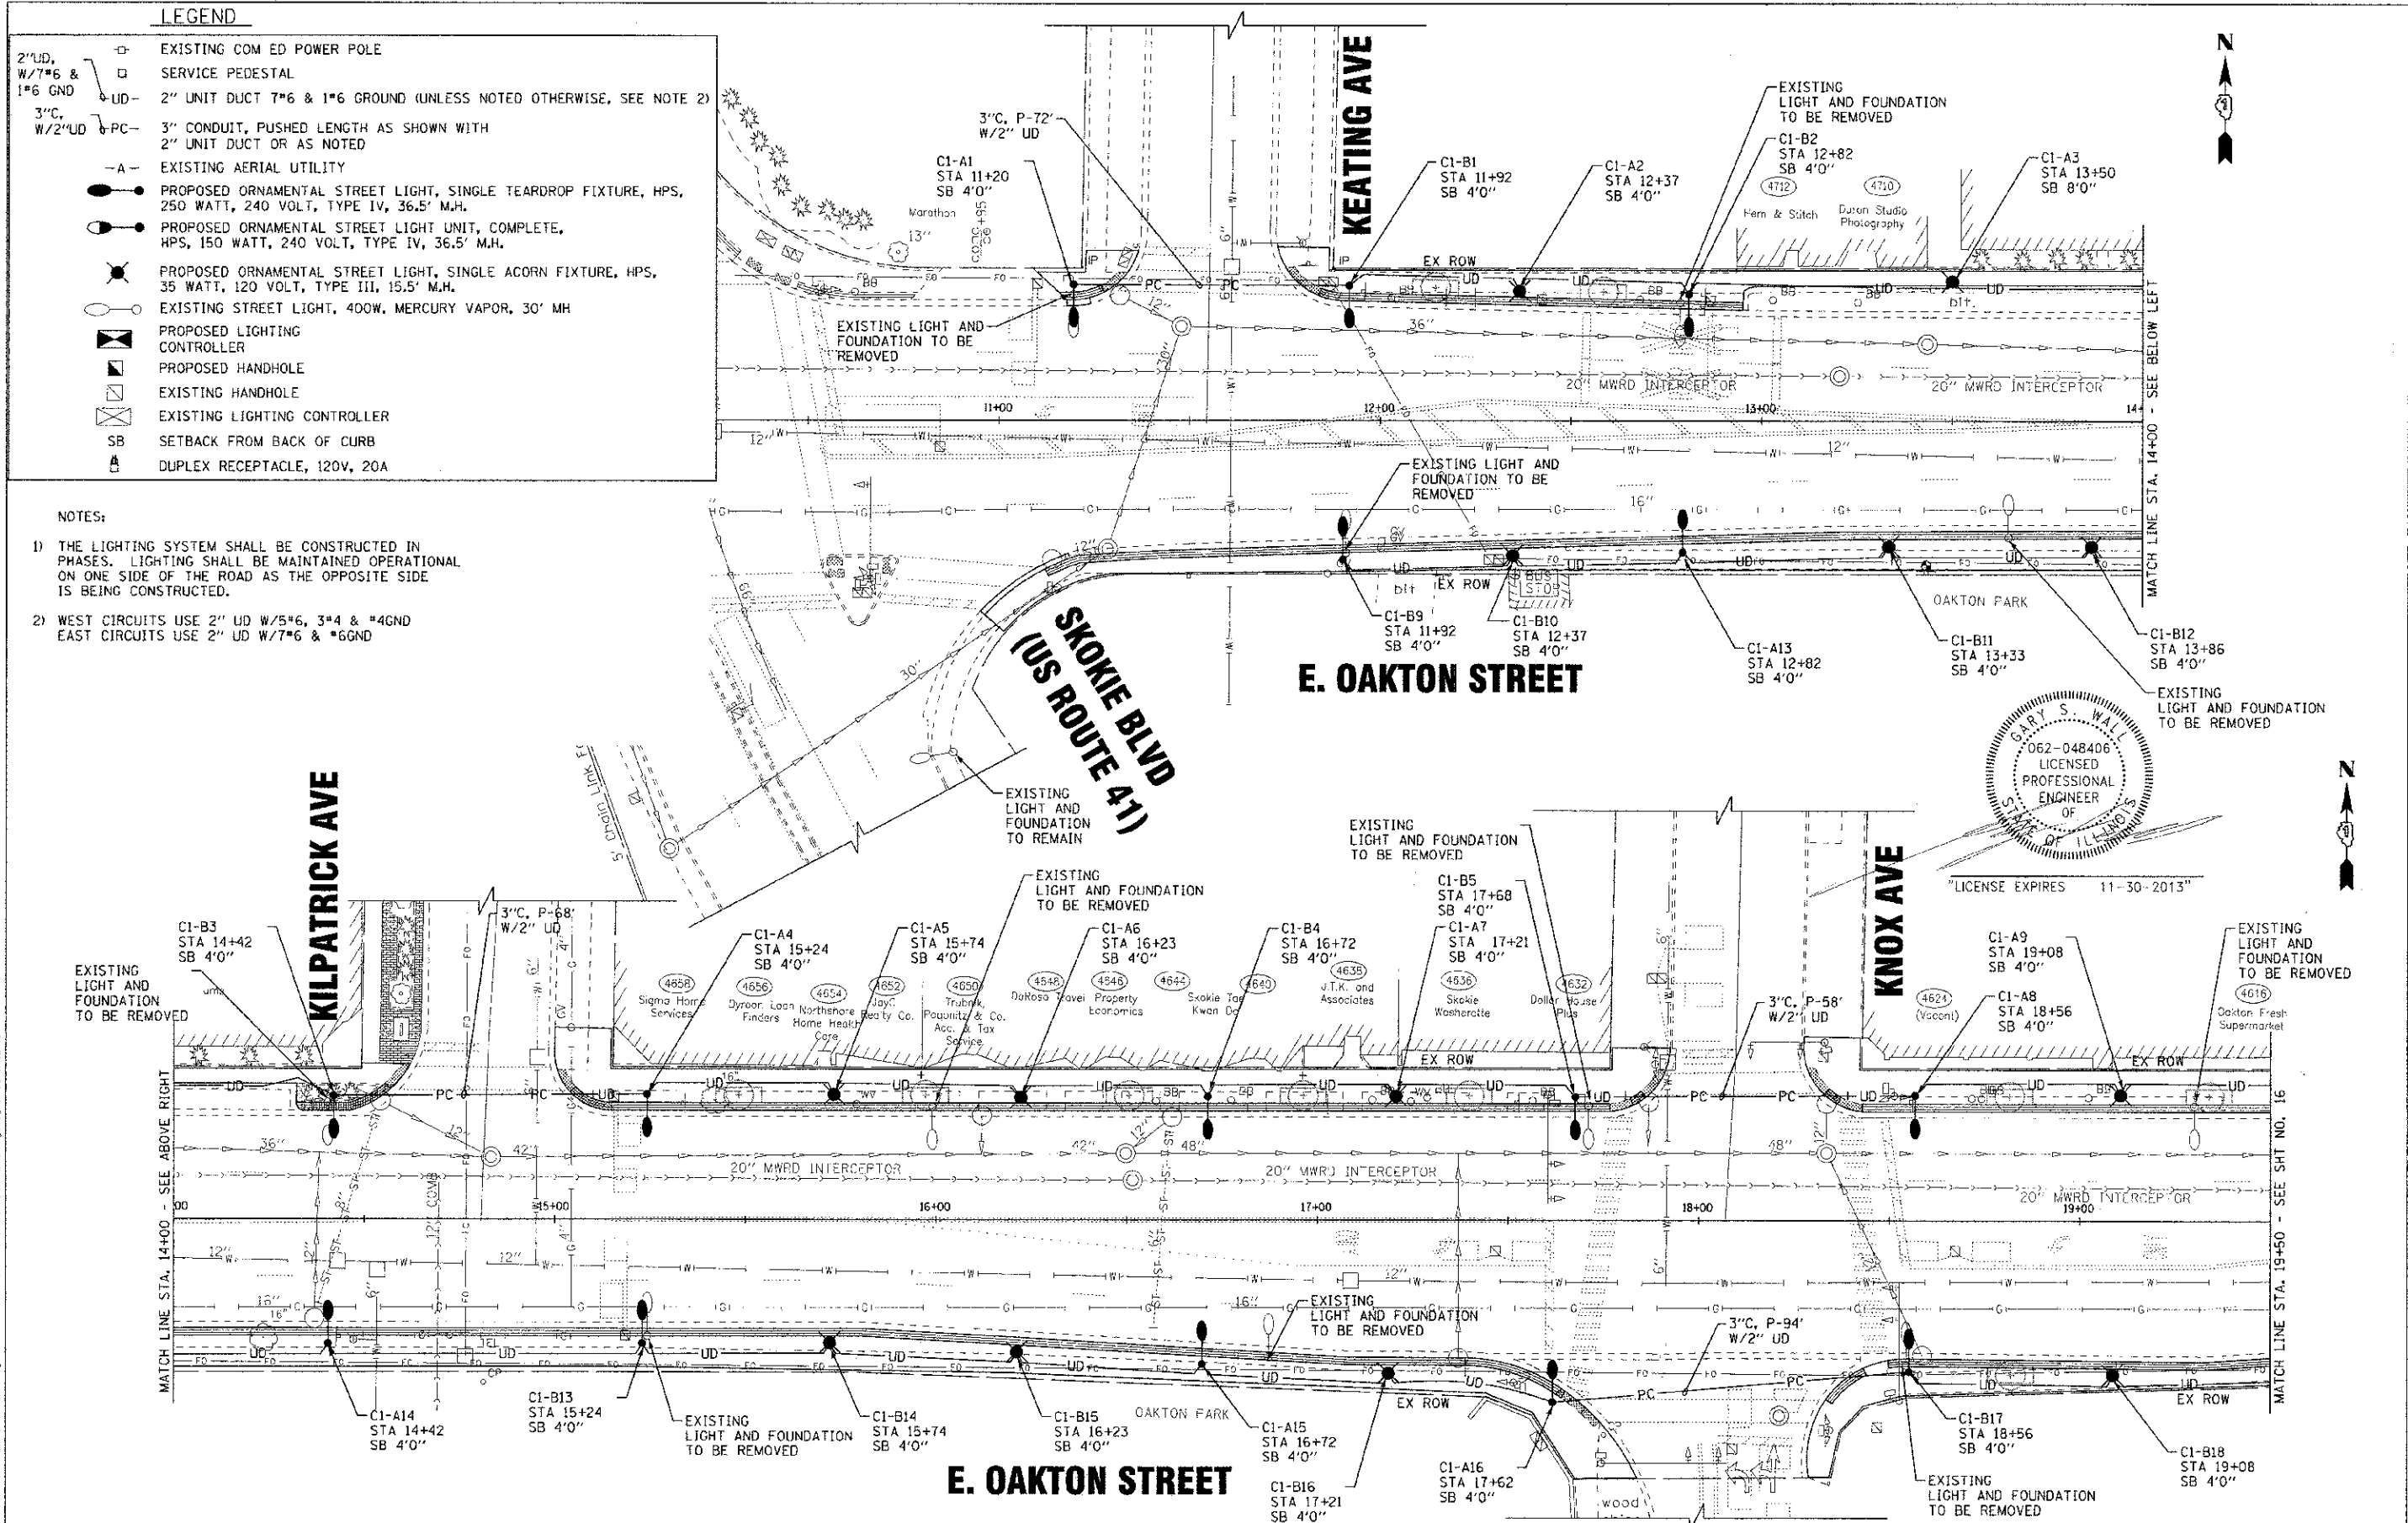

2011 BY BAXTER & WIDEMAN, INC. FOR THE VILLAGE OF SKOKIE, ILLINOIS
 PROJECT: VILLAGE OF SKOKIE, ILLINOIS - STREETSCAPE IMPROVEMENTS
 DRAWING NO.: 100751-SL-1.sht
 DATE: 5-14-12



DESIGNED - MWH	REVISED - 8-3-12 PER CCHO
DRAWN - MAC	REVISED - 8-3-12 PER 100
CHECKED - GSW	REVISED -
DATE - 5-14-12	FILE - 100751-SL-1.sht

VILLAGE OF SKOKIE, ILLINOIS
F.A.U. ROUTE 1332 E. OAKTON STREET
FROM F.A.P. 350 U.S. ROUTE 41 (SKOKIE BOULEVARD) TO LOWELL AVENUE
STREETSCAPE IMPROVEMENTS

STREET LIGHTING PLAN
F.A.U. ROUTE 1332 E. OAKTON STREET
 SCALE: 1"=20'
 STA. 9+00 TO STA. 19+50

F.A.U. RTE. 1332	SECTION 11-00286-00-LS	COUNTY COOK	TOTAL SHEETS 29
	C-91-149-12		NO. 15
FED. ROAD DIST. NO. 1 ILLINOIS		CONTRACT NO. 63737	
		FED. AID PROJECT: YE-00018891	