



PLAN	DATE
BY	
NO.	
FILE NAME	

PROF. FILE	DATE
BY	
NO.	
FILE NAME	

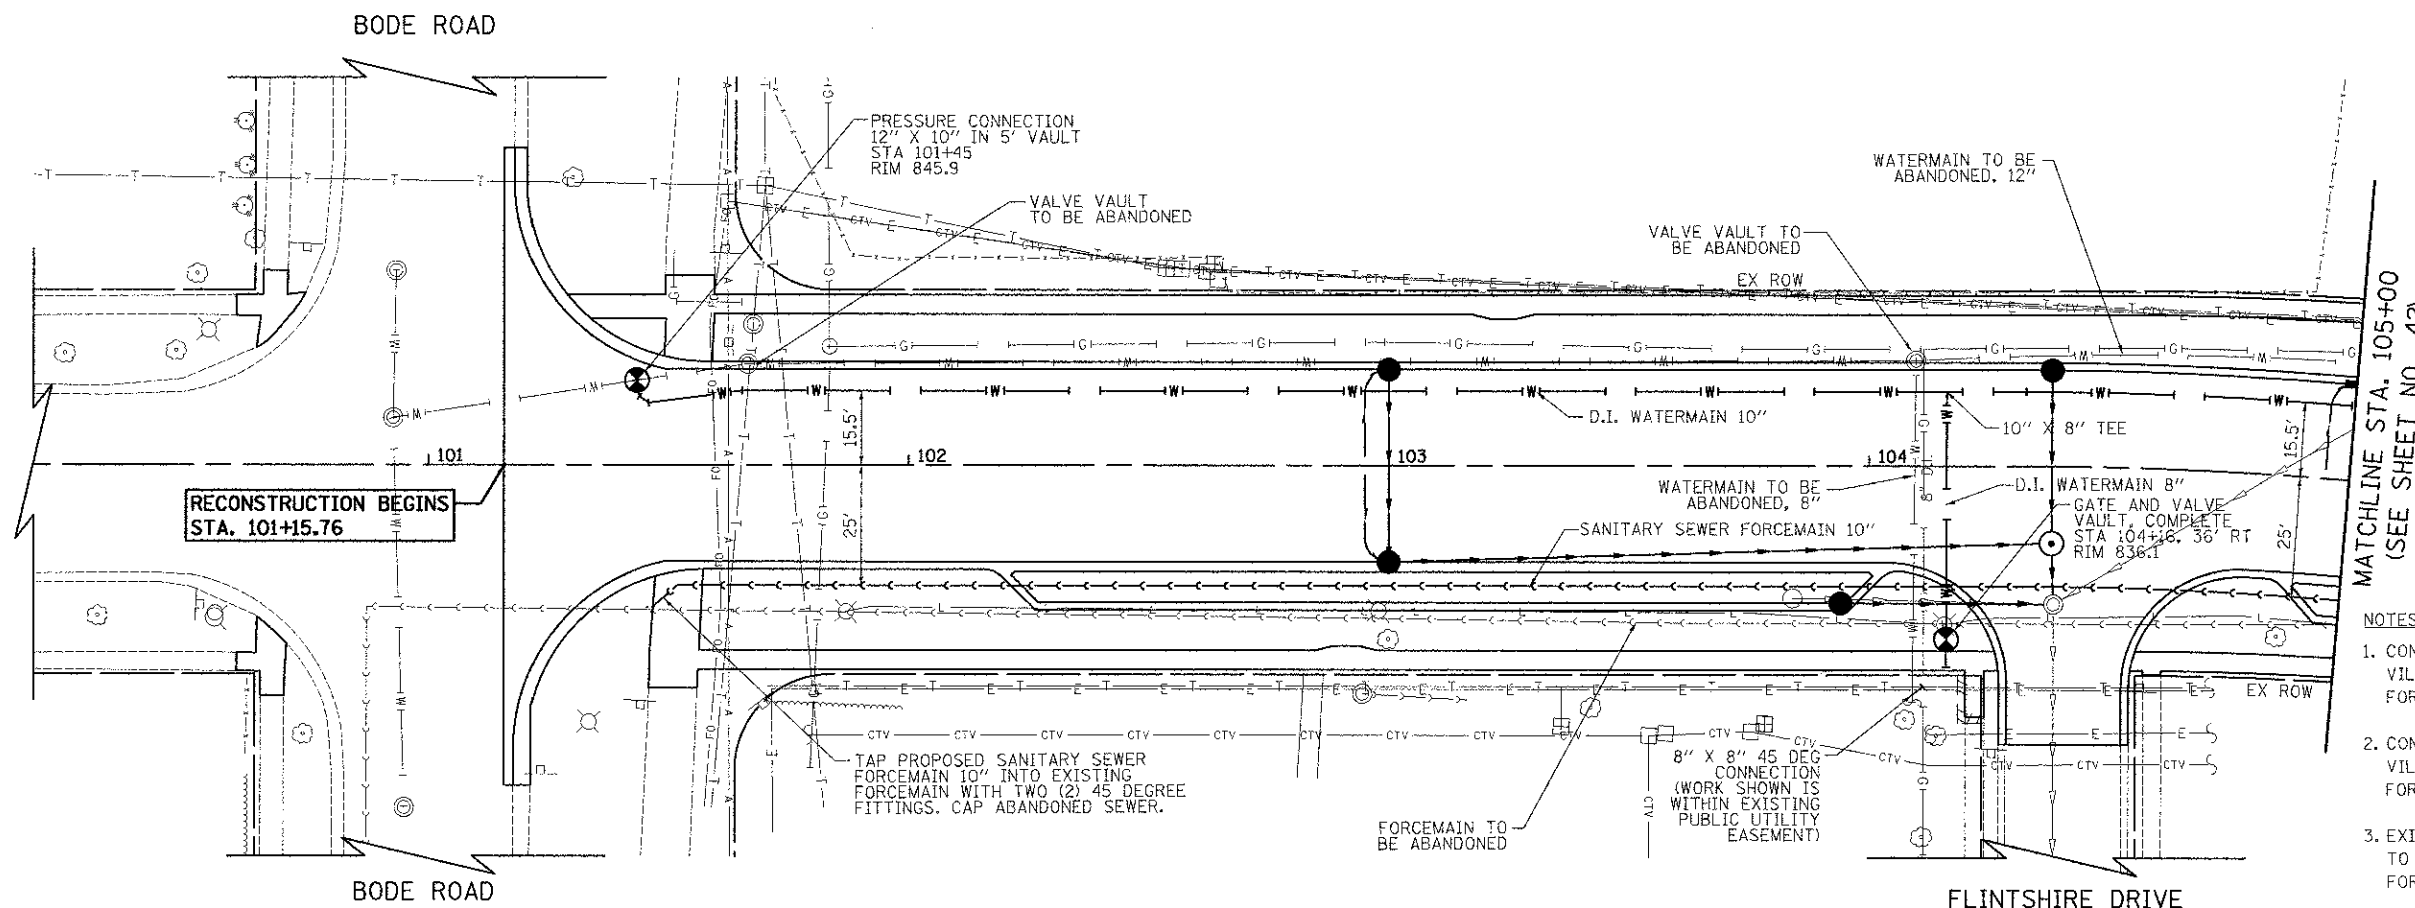

- NOTES**
- CONTRACTOR TO COORDINATE WITH THE VILLAGE OF SCHAUMBURG'S WATER DIVISION FOR VALVE SHUT DOWN.
 - CONTRACTOR TO COORDINATE WITH THE VILLAGE OF SCHAUMBURG'S WATER DIVISION FOR SANITARY SEWER FORCEMAIN SHUTDOWN.
 - EXISTING SANITARY SEWER FORCEMAIN IS TO REMAIN IN SERVICE UNTIL THE NEW FORCEMAIN IS IN SERVICE.

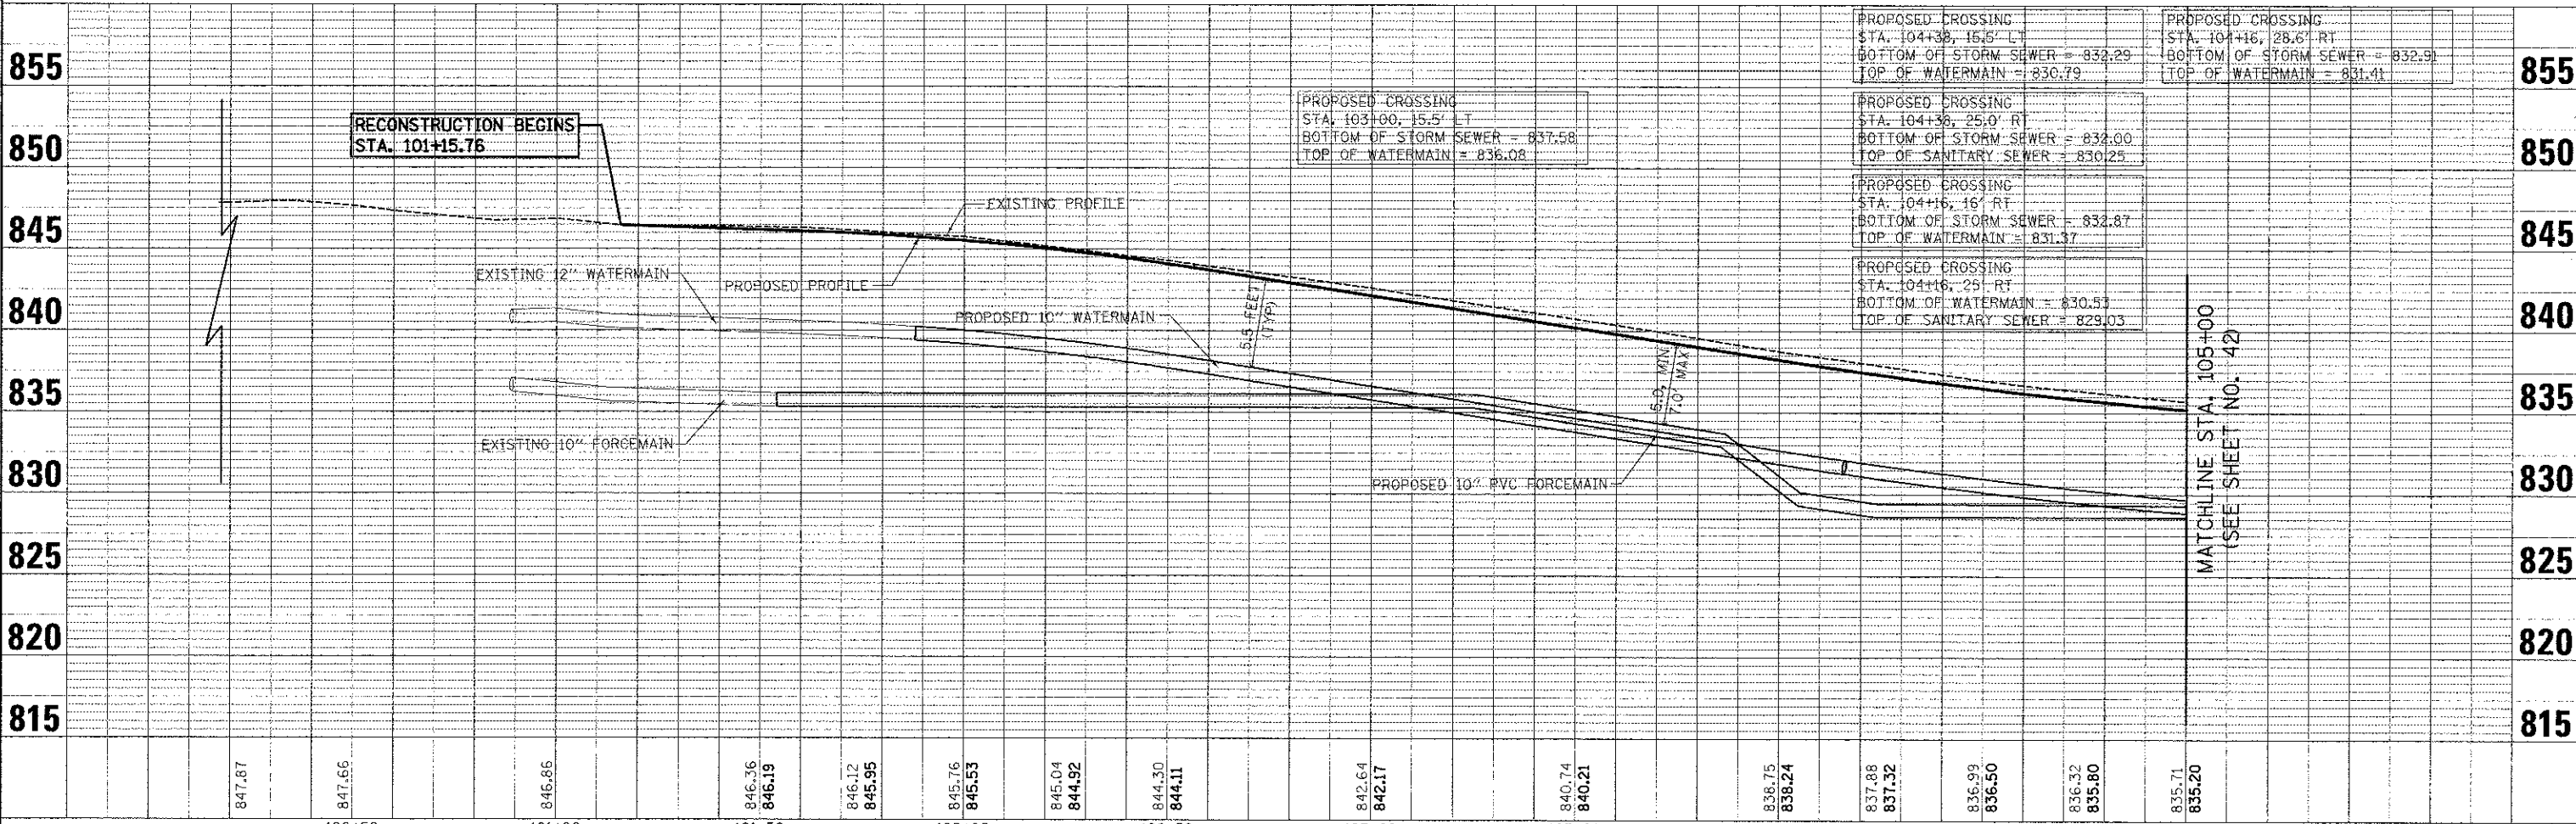

FILE NAME = ...VFGRCE_MAIN_21.dgn	USER NAME = a.jk	DESIGNED -	REVISED -	STATE OF ILLINOIS DEPARTMENT OF TRANSPORTATION	WALNUT LANE VILLAGE UTILITY PLAN	F.A.U. RTE. 2556	SECTION 08-00094-00-PV	COUNTY COOK	TOTAL SHEETS 41	SHEET NO. 1 OF 5 SHEETS	STA. 101+15.67 TO STA. 105+00.00	CONTRACT NO. 63738	
PLT SCALE = 20.0000' / 1" =	CHECKED - DJK	REVISOR -	REVISOR -			ILLINOIS FED. AID PROJECT M-9003(494)							
PLT DATE = 8/15/2012	DATE = 8/20/2012	REVISOR -	REVISOR -										