
 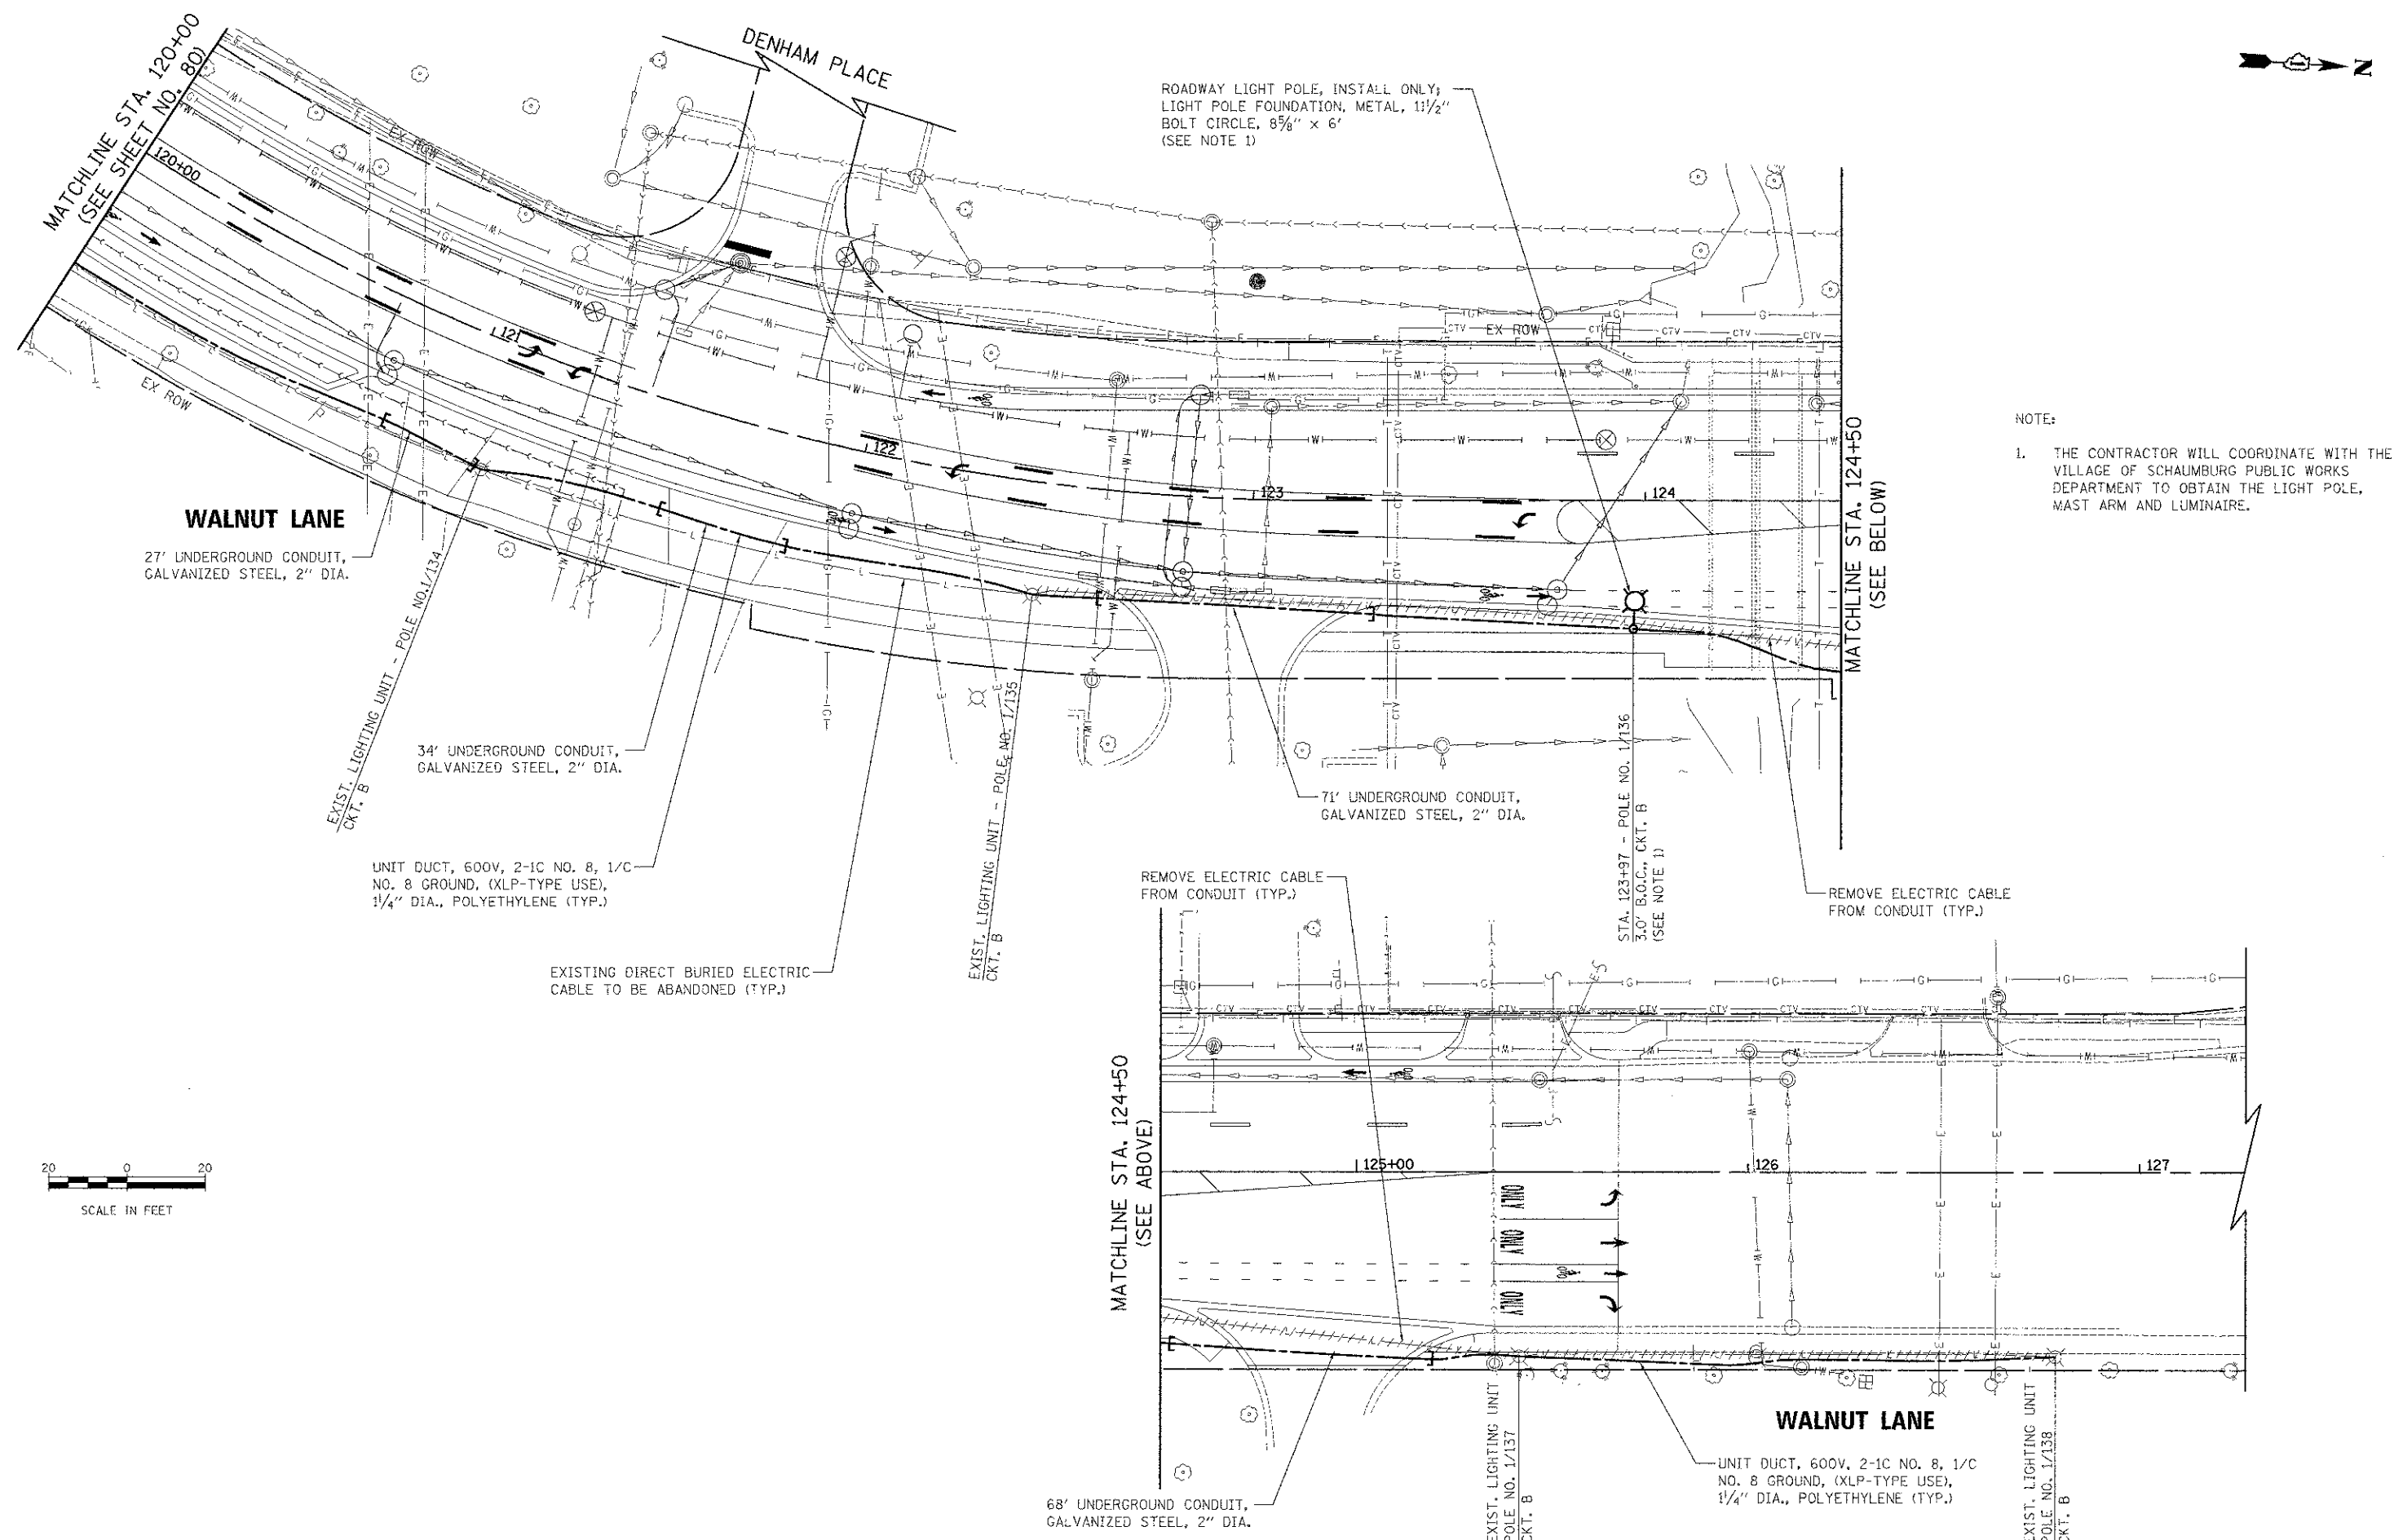


PLAN	DATE
BY	
REVISIONS	
CHECKED	
ALIGNMENT	
FILE NAME	
NO.	

PROFILE	DATE
BY	
REVISIONS	
CHECKED	
GRADES	
STRUCTURE	
NOTATION	
NO.	



NOTE:
1. THE CONTRACTOR WILL COORDINATE WITH THE VILLAGE OF SCHAUMBURG PUBLIC WORKS DEPARTMENT TO OBTAIN THE LIGHT POLE, MAST ARM AND LUMINAIRE.

FILE NAME = ...\\16-Lighting\2536-LT_PP_05.dgn	USER NAME = djk	DESIGNED - JSM	REVISED -	STATE OF ILLINOIS DEPARTMENT OF TRANSPORTATION	WALNUT LANE LIGHTING PLAN	F.A.I. RTE. 2556	SECTION 08-00094-00-PV	COUNTY COOK	TOTAL SHEETS 113	SHEET NO. 81		
PLOT SCALE = 20.0000' / 1" =	CHECKED - DJK	REVISIED -	REVISIED -			SCALE = 1" = 20'	SHEET NO. 5 OF 6 SHEETS	STA. 120+00.00 TO STA. 125+67.00	CONTRACT NO. 63738			
PLOT DATE = #DATE#	DATE - 8/15/2012	REVISIED -	REVISIED -			ILLINOIS FED. AID PROJECT M-9003(494)						