
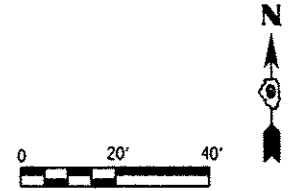


MATCHLINE STA. 865+00

MATCHLINE STA. 871+00

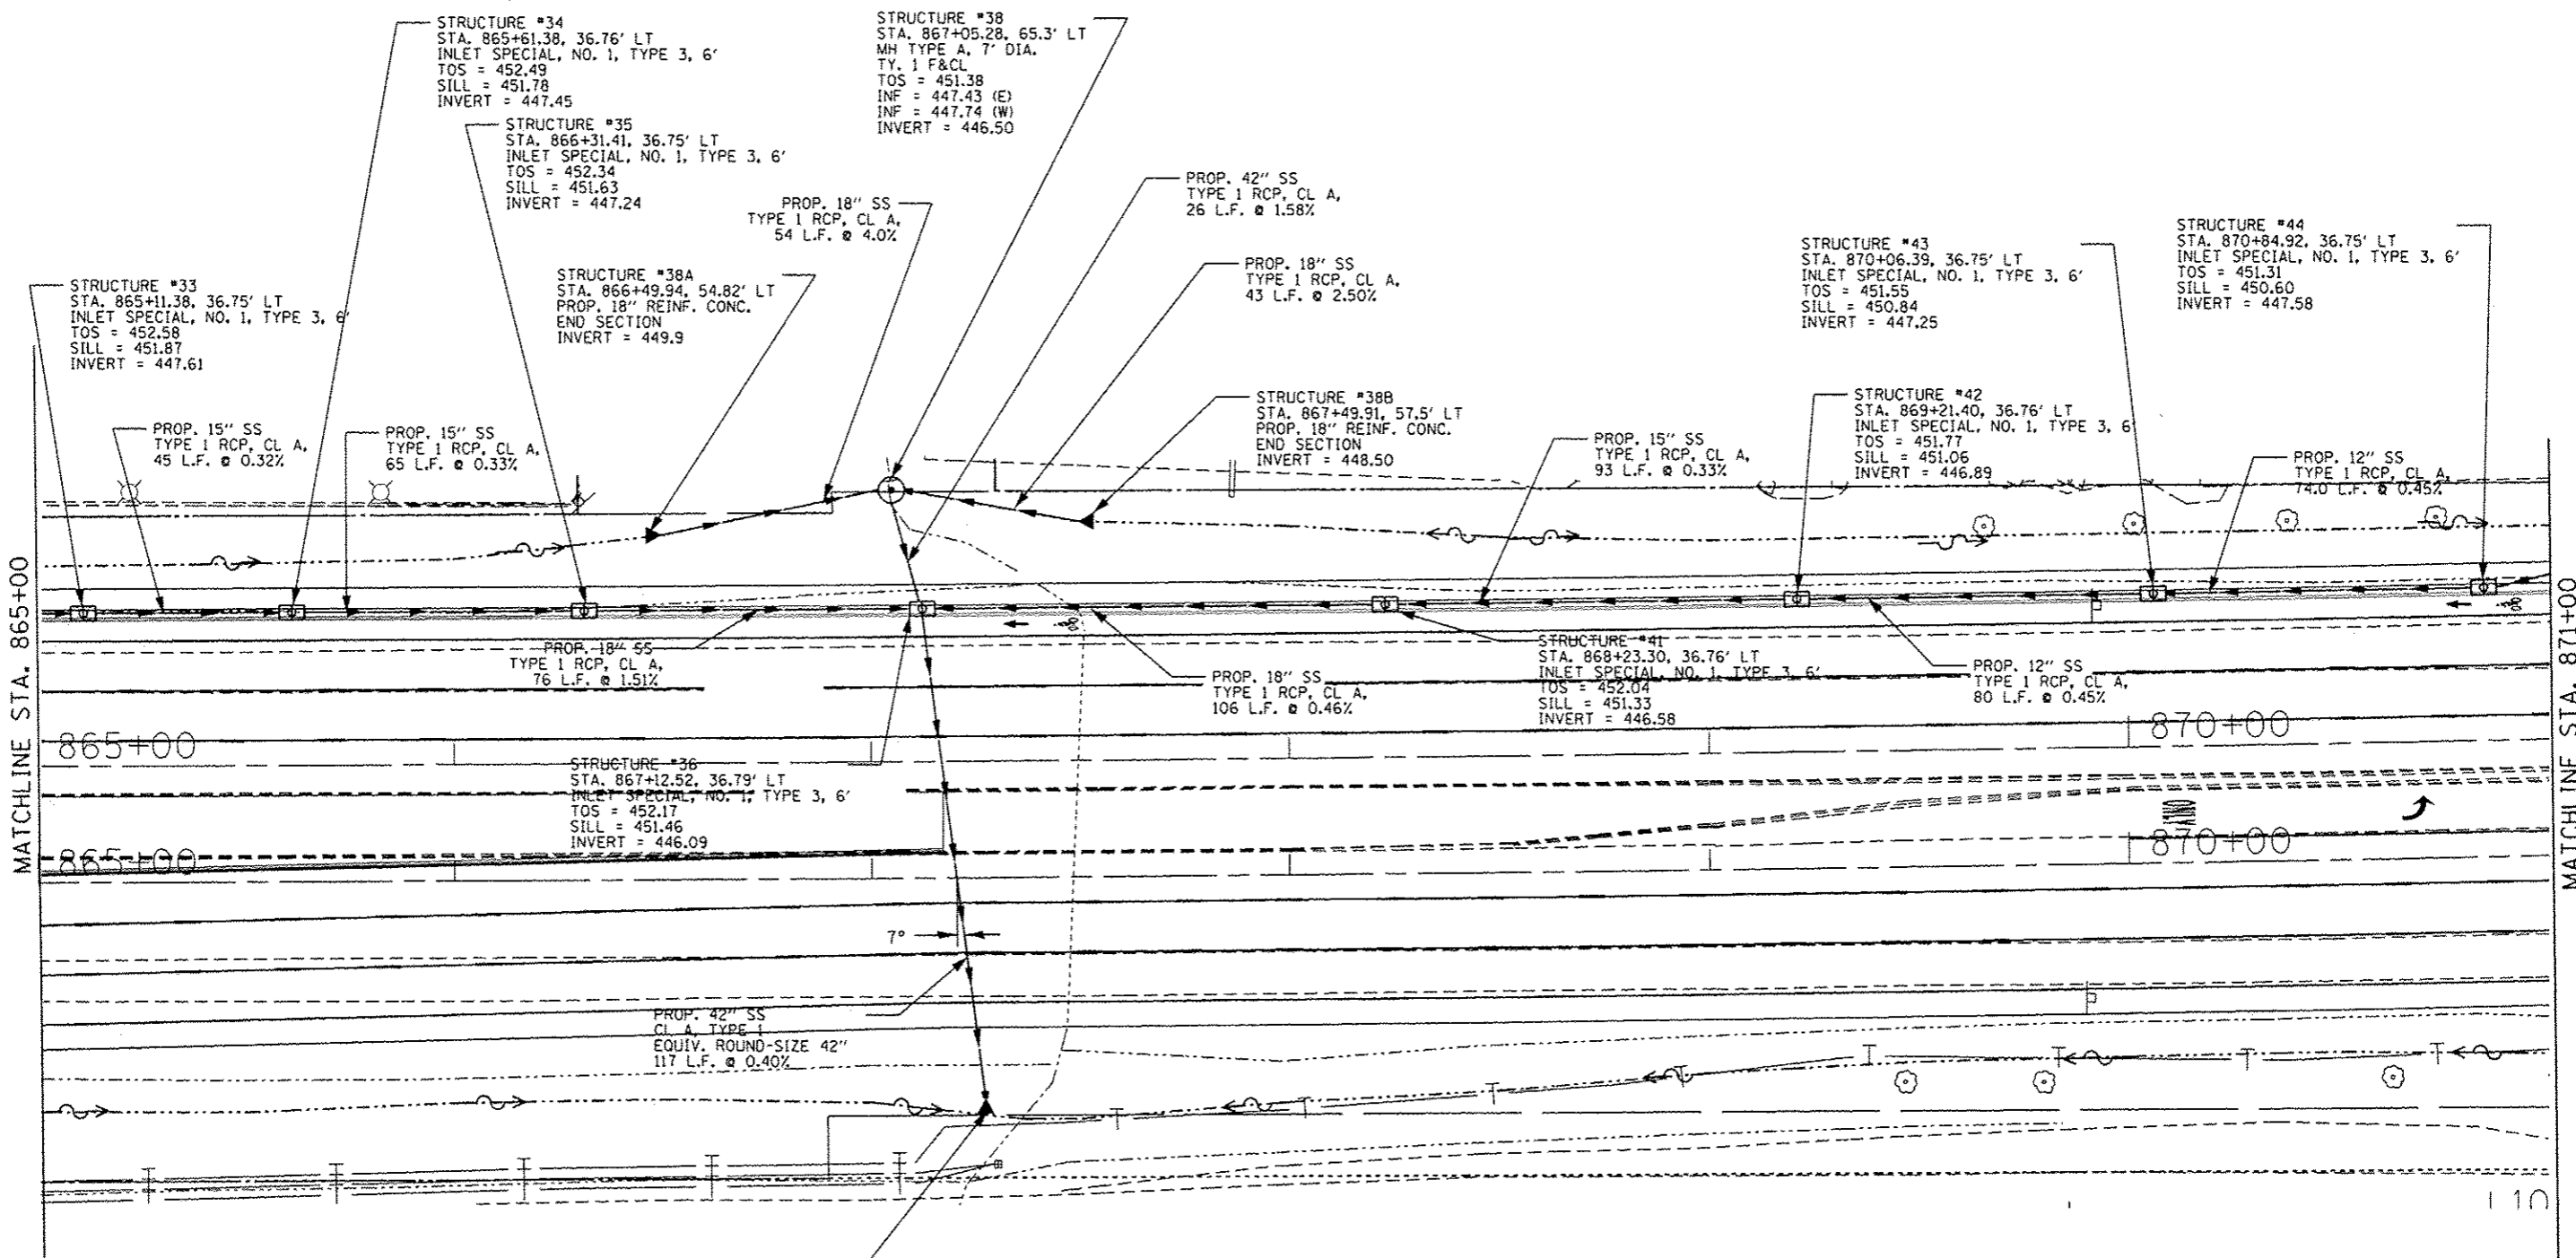

FILE NAME =	USER NAME = lavenderba	DESIGNED -	REVISED -	STATE OF ILLINOIS DEPARTMENT OF TRANSPORTATION	DRAINAGE PLAN SHEETS IL 13		F.A.P. RTE.	SECTION	COUNTY	TOTAL SHEETS	SHEET NO.	
c:\pwork\pedit\lavenderba\01844517	203-gh1-drain.dgn	DRAWN -	REVISED -		SCALE:	SHEET NO. OF SHEETS	STA. TO STA.	331	(IX-11R-5,RS-3,N-5,TS-4	WILLIAMSON	288	97
	PLOT SCALE = 40.0000' / in.	CHECKED -	REVISED -									
	PLOT DATE = 9/12/2012	DATE -	REVISED -									
CONTRACT NO. 78203												
ILLINOIS FED. AID PROJECT												