 



DATE
BY
REVISIONS
NO.
DESCRIPTION
DATE
BY
REVISIONS
NO.
DESCRIPTION
DATE
BY
REVISIONS
NO.
DESCRIPTION
DATE
BY
REVISIONS
NO.
DESCRIPTION

DATE
BY
REVISIONS
NO.
DESCRIPTION
DATE
BY
REVISIONS
NO.
DESCRIPTION
DATE
BY
REVISIONS
NO.
DESCRIPTION
DATE
BY
REVISIONS
NO.
DESCRIPTION
DATE
BY
REVISIONS
NO.
DESCRIPTION

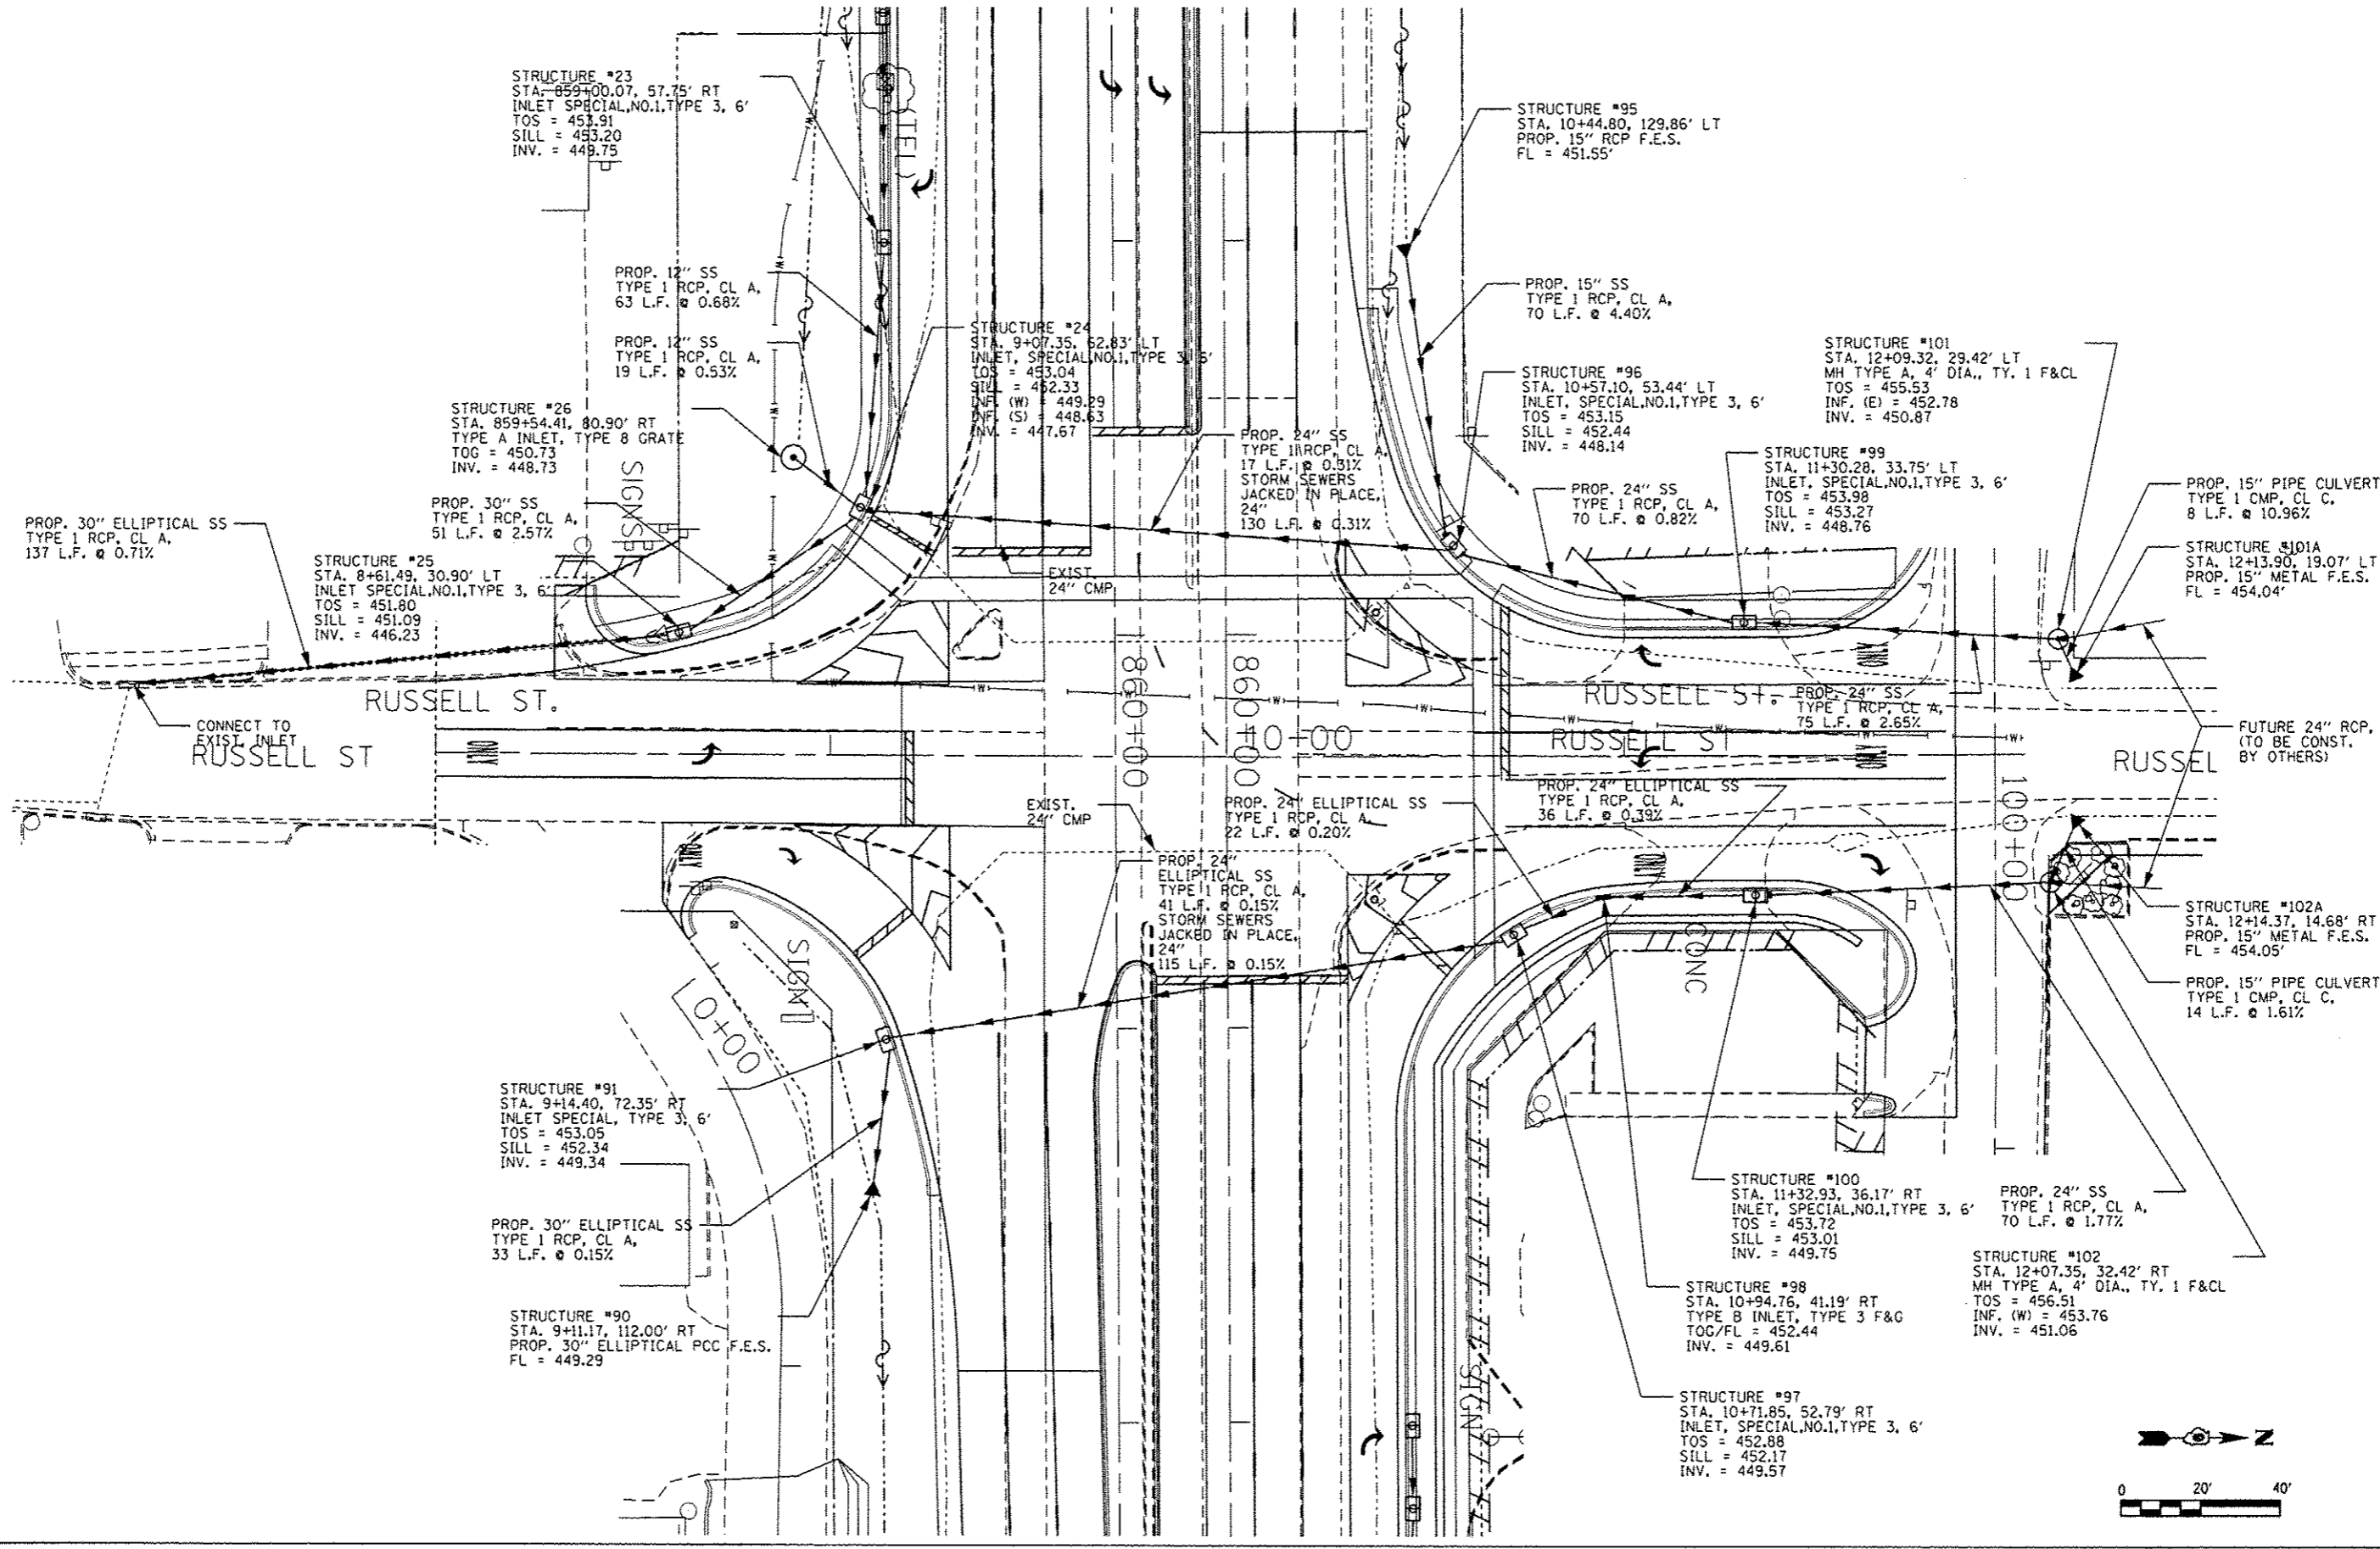

DESIGNED -	REVISED -	STATE OF ILLINOIS DEPARTMENT OF TRANSPORTATION	DRAINAGE PLAN SHEETS RUSSELL ST.		F.A.P. RTE.	SECTION	COUNTY	TOTAL SHEETS	SHEET NO.
DRAWN -	REVISED -				331	(1X-11R-5,RS-3,N-5,TS-4	WILLIAMSON	288	101
CHECKED -	REVISED -				CONTRACT NO. 78203				
DATE -	REVISED -				ILLINOIS FED. AID PROJECT				
			SCALE: 1" = 20'	SHEET NO. 12 OF 20 SHEETS	STA 7+00.00 TO STA 12+25.00				