
 
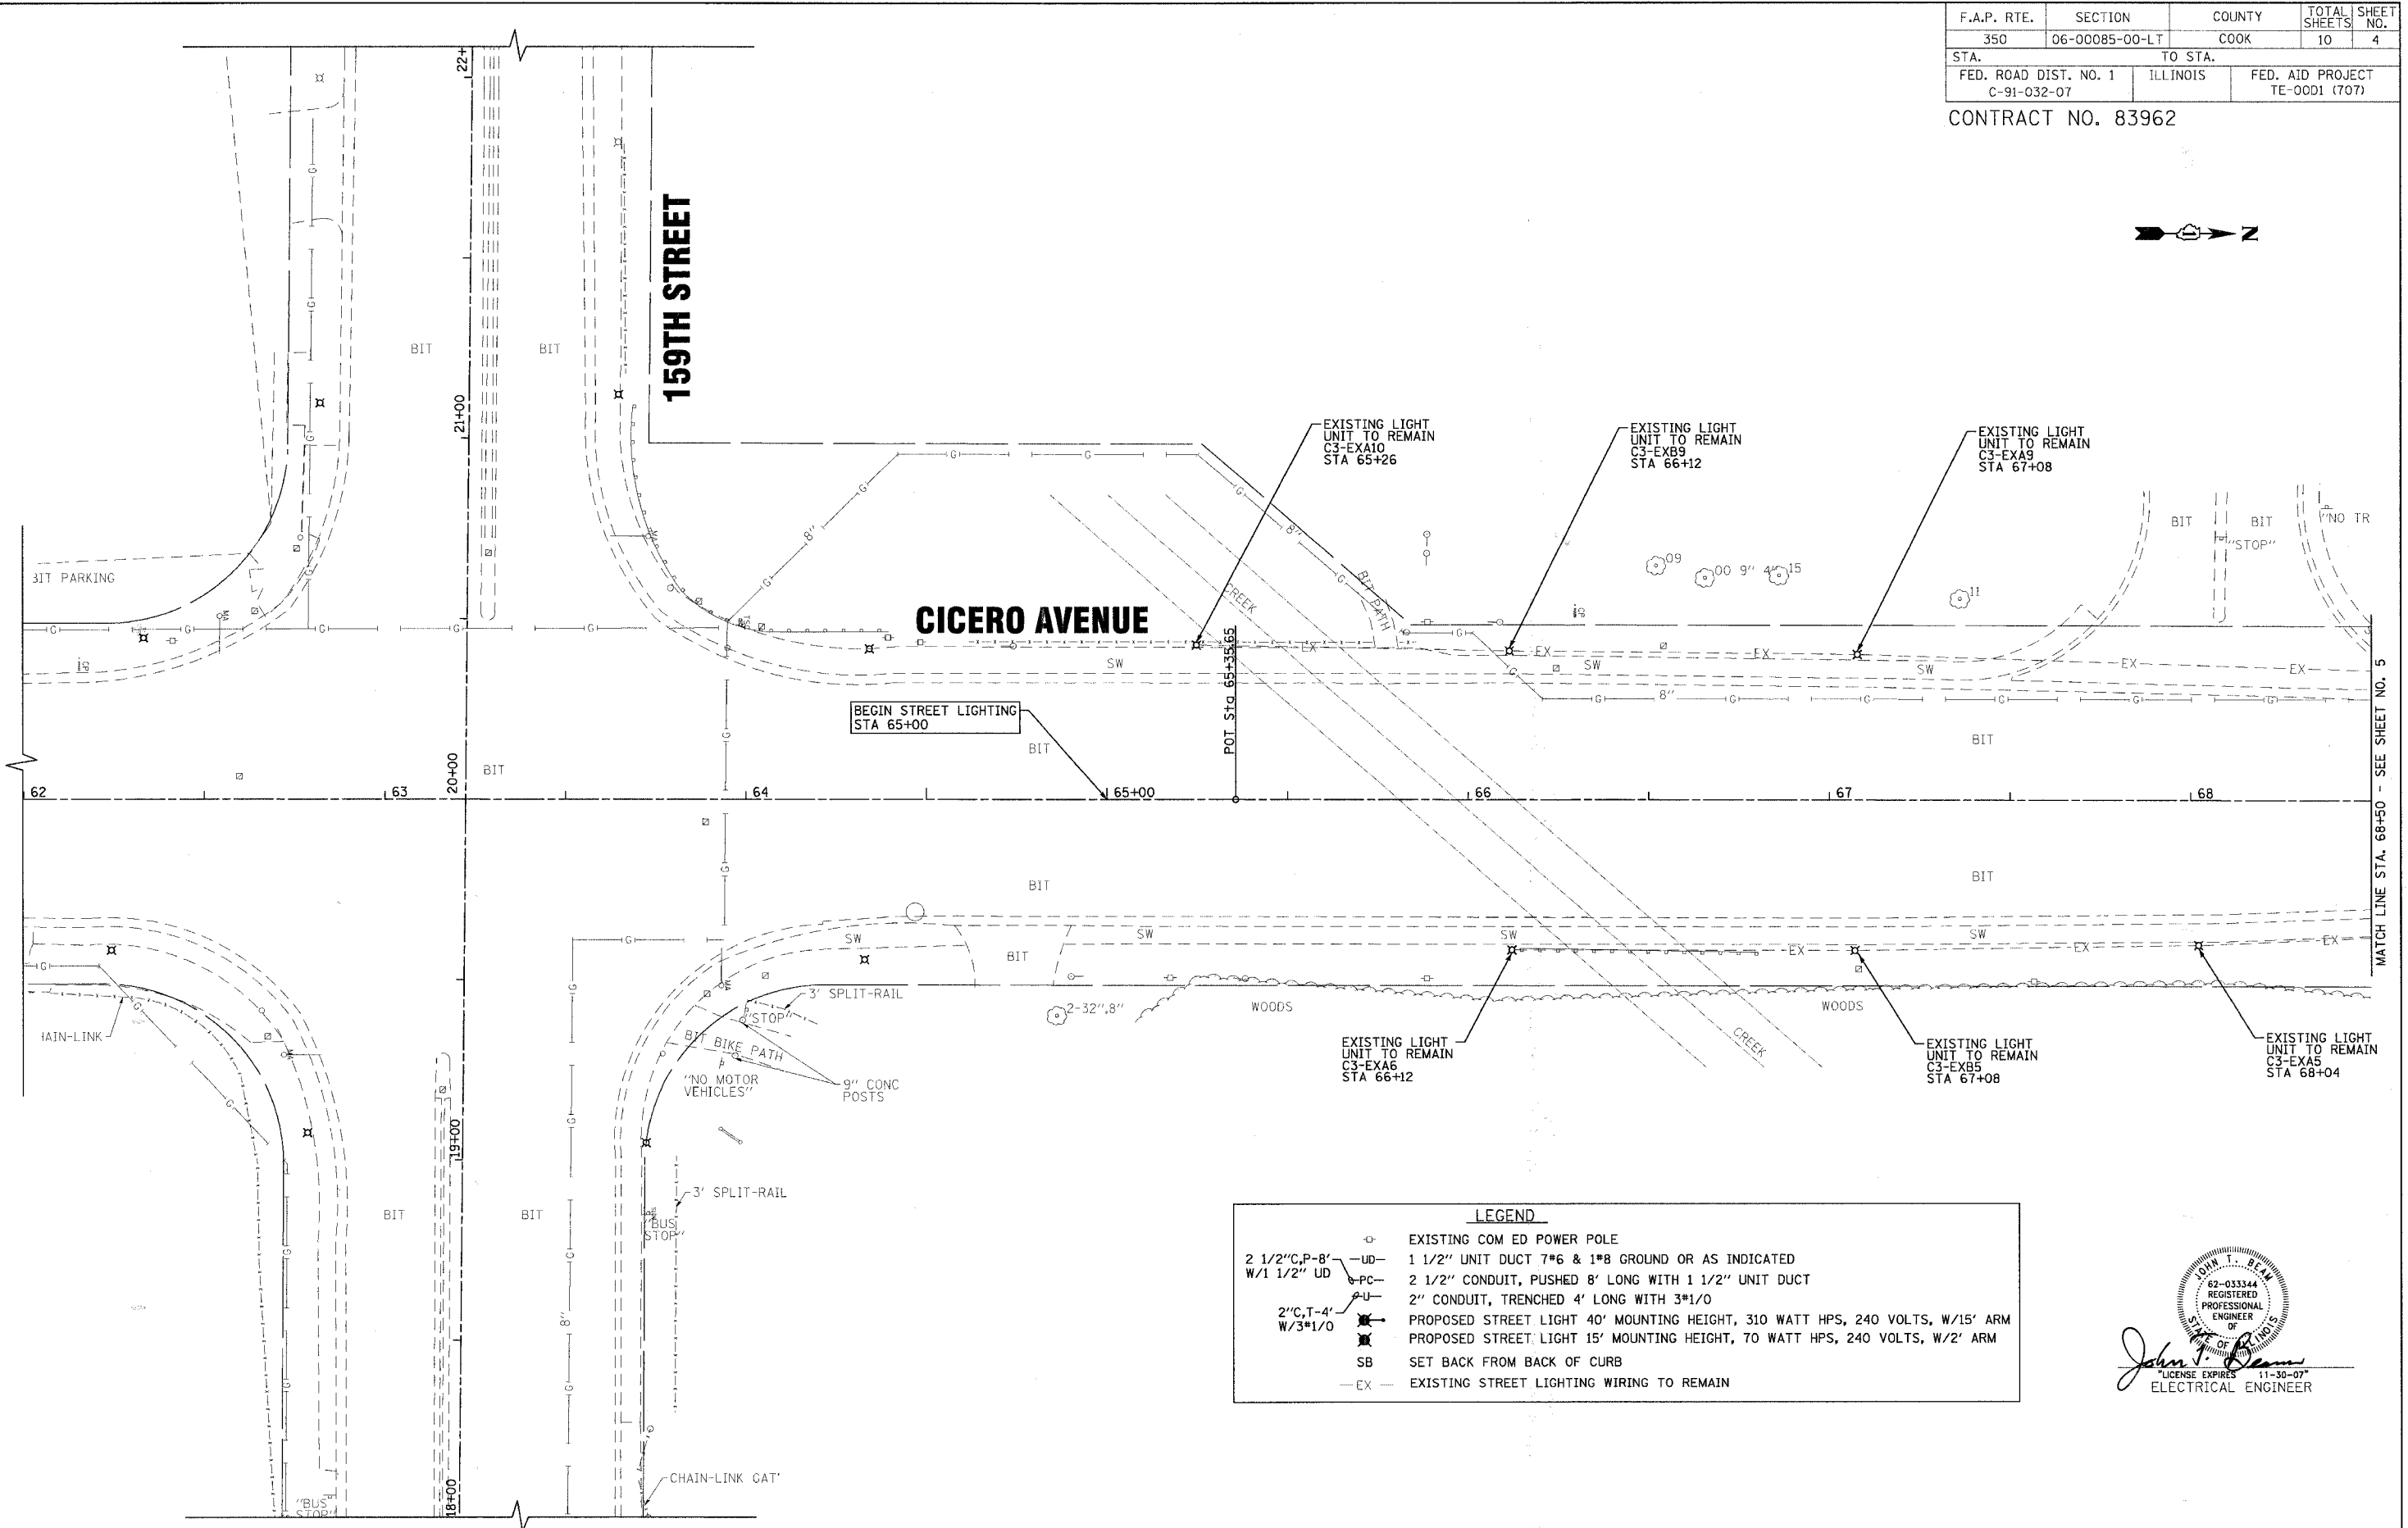


F.A.P. RTE.	SECTION	COUNTY	TOTAL SHEETS	SHEET NO.
350	06-00085-00-LT	COOK	10	4
STA.		TO STA.		
FED. ROAD DIST. NO. 1		ILLINOIS	FED. AID PROJECT	
C-91-032-07			TE-0001 (707)	

CONTRACT NO. 83962



LEGEND	
	EXISTING COM ED POWER POLE
	1 1/2" UNIT DUCT 7*6 & 1*8 GROUND OR AS INDICATED
	2 1/2" CONDUIT, PUSHED 8' LONG WITH 1 1/2" UNIT DUCT
	2" CONDUIT, TRENCHED 4' LONG WITH 3*1/0
	PROPOSED STREET LIGHT 40' MOUNTING HEIGHT, 310 WATT HPS, 240 VOLTS, W/15' ARM
	PROPOSED STREET LIGHT 15' MOUNTING HEIGHT, 70 WATT HPS, 240 VOLTS, W/2' ARM
	SB SET BACK FROM BACK OF CURB
	EX EXISTING STREET LIGHTING WIRING TO REMAIN

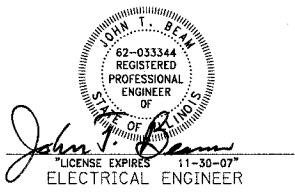

COPYRIGHT © 2007 BY BAXTER & WOODMAN, INC.
 STATE OF ILLINOIS - PROFESSIONAL DESIGN FIRM
 2630 N. WILSON AVENUE, SUITE 100, OAK FOREST, ILLINOIS 60451
 TEL: 815.469.1200 FAX: 815.469.1201 WWW.BAXTERANDWOODMAN.COM

CONSULTANTS	REV. NO.	DATE	DESCRIPTION

* REFER TO EQUIPMENT MANUFACTURER'S SHOP DRAWINGS

DRAWING FILE: #FILEA#

BAXTER & WOODMAN
 Consulting Engineers

Baxter & Woodman
 Crystal Lake, Illinois 815.469.1200
 Havana, Illinois 815.770.1870
 Burlington, Wisconsin 262.763.7854
 Mahomet, Illinois 708.478.2020
 DeKalb, Illinois 815.787.3111
 Graylake, Illinois 847.223.8088
 Rockford, Illinois 815.489.1551
 Plainfield, Illinois 815.609.7425

CITY OF OAK FOREST, ILLINOIS
FAP 350 CICERO AVENUE IMPROVEMENTS
 (155TH ST. TO 159TH ST.)

STREET LIGHTING PLAN
CICERO AVENUE
 STA 62+00 TO STA 68+50

DESIGNED BY	JLR	SCALE	1"=20'
DRAWN BY	MAC	PROJECT NO.	060467
CHECKED BY	JTB	SHEET NO.	
DATE	06/21/07		