 



F.A. RTE.	SECTION	COUNTY	TOTAL SHEETS	SHEET NO.
8899	03-00026-00-RP	MADISON	107	50
FED. ROAD DIST. NO.	ILLINOIS	FED. AID PROJECT		
CONTRACT NO. 97295				

BY	DATE
FINAL SURVEY PLOTTED	
NOTE BOOK	
AREAS CHECKED	
NO.	

BY	DATE
ORIGINAL SURVEY PLOTTED	
NOTE BOOK	
AREAS CHECKED	
NO.	

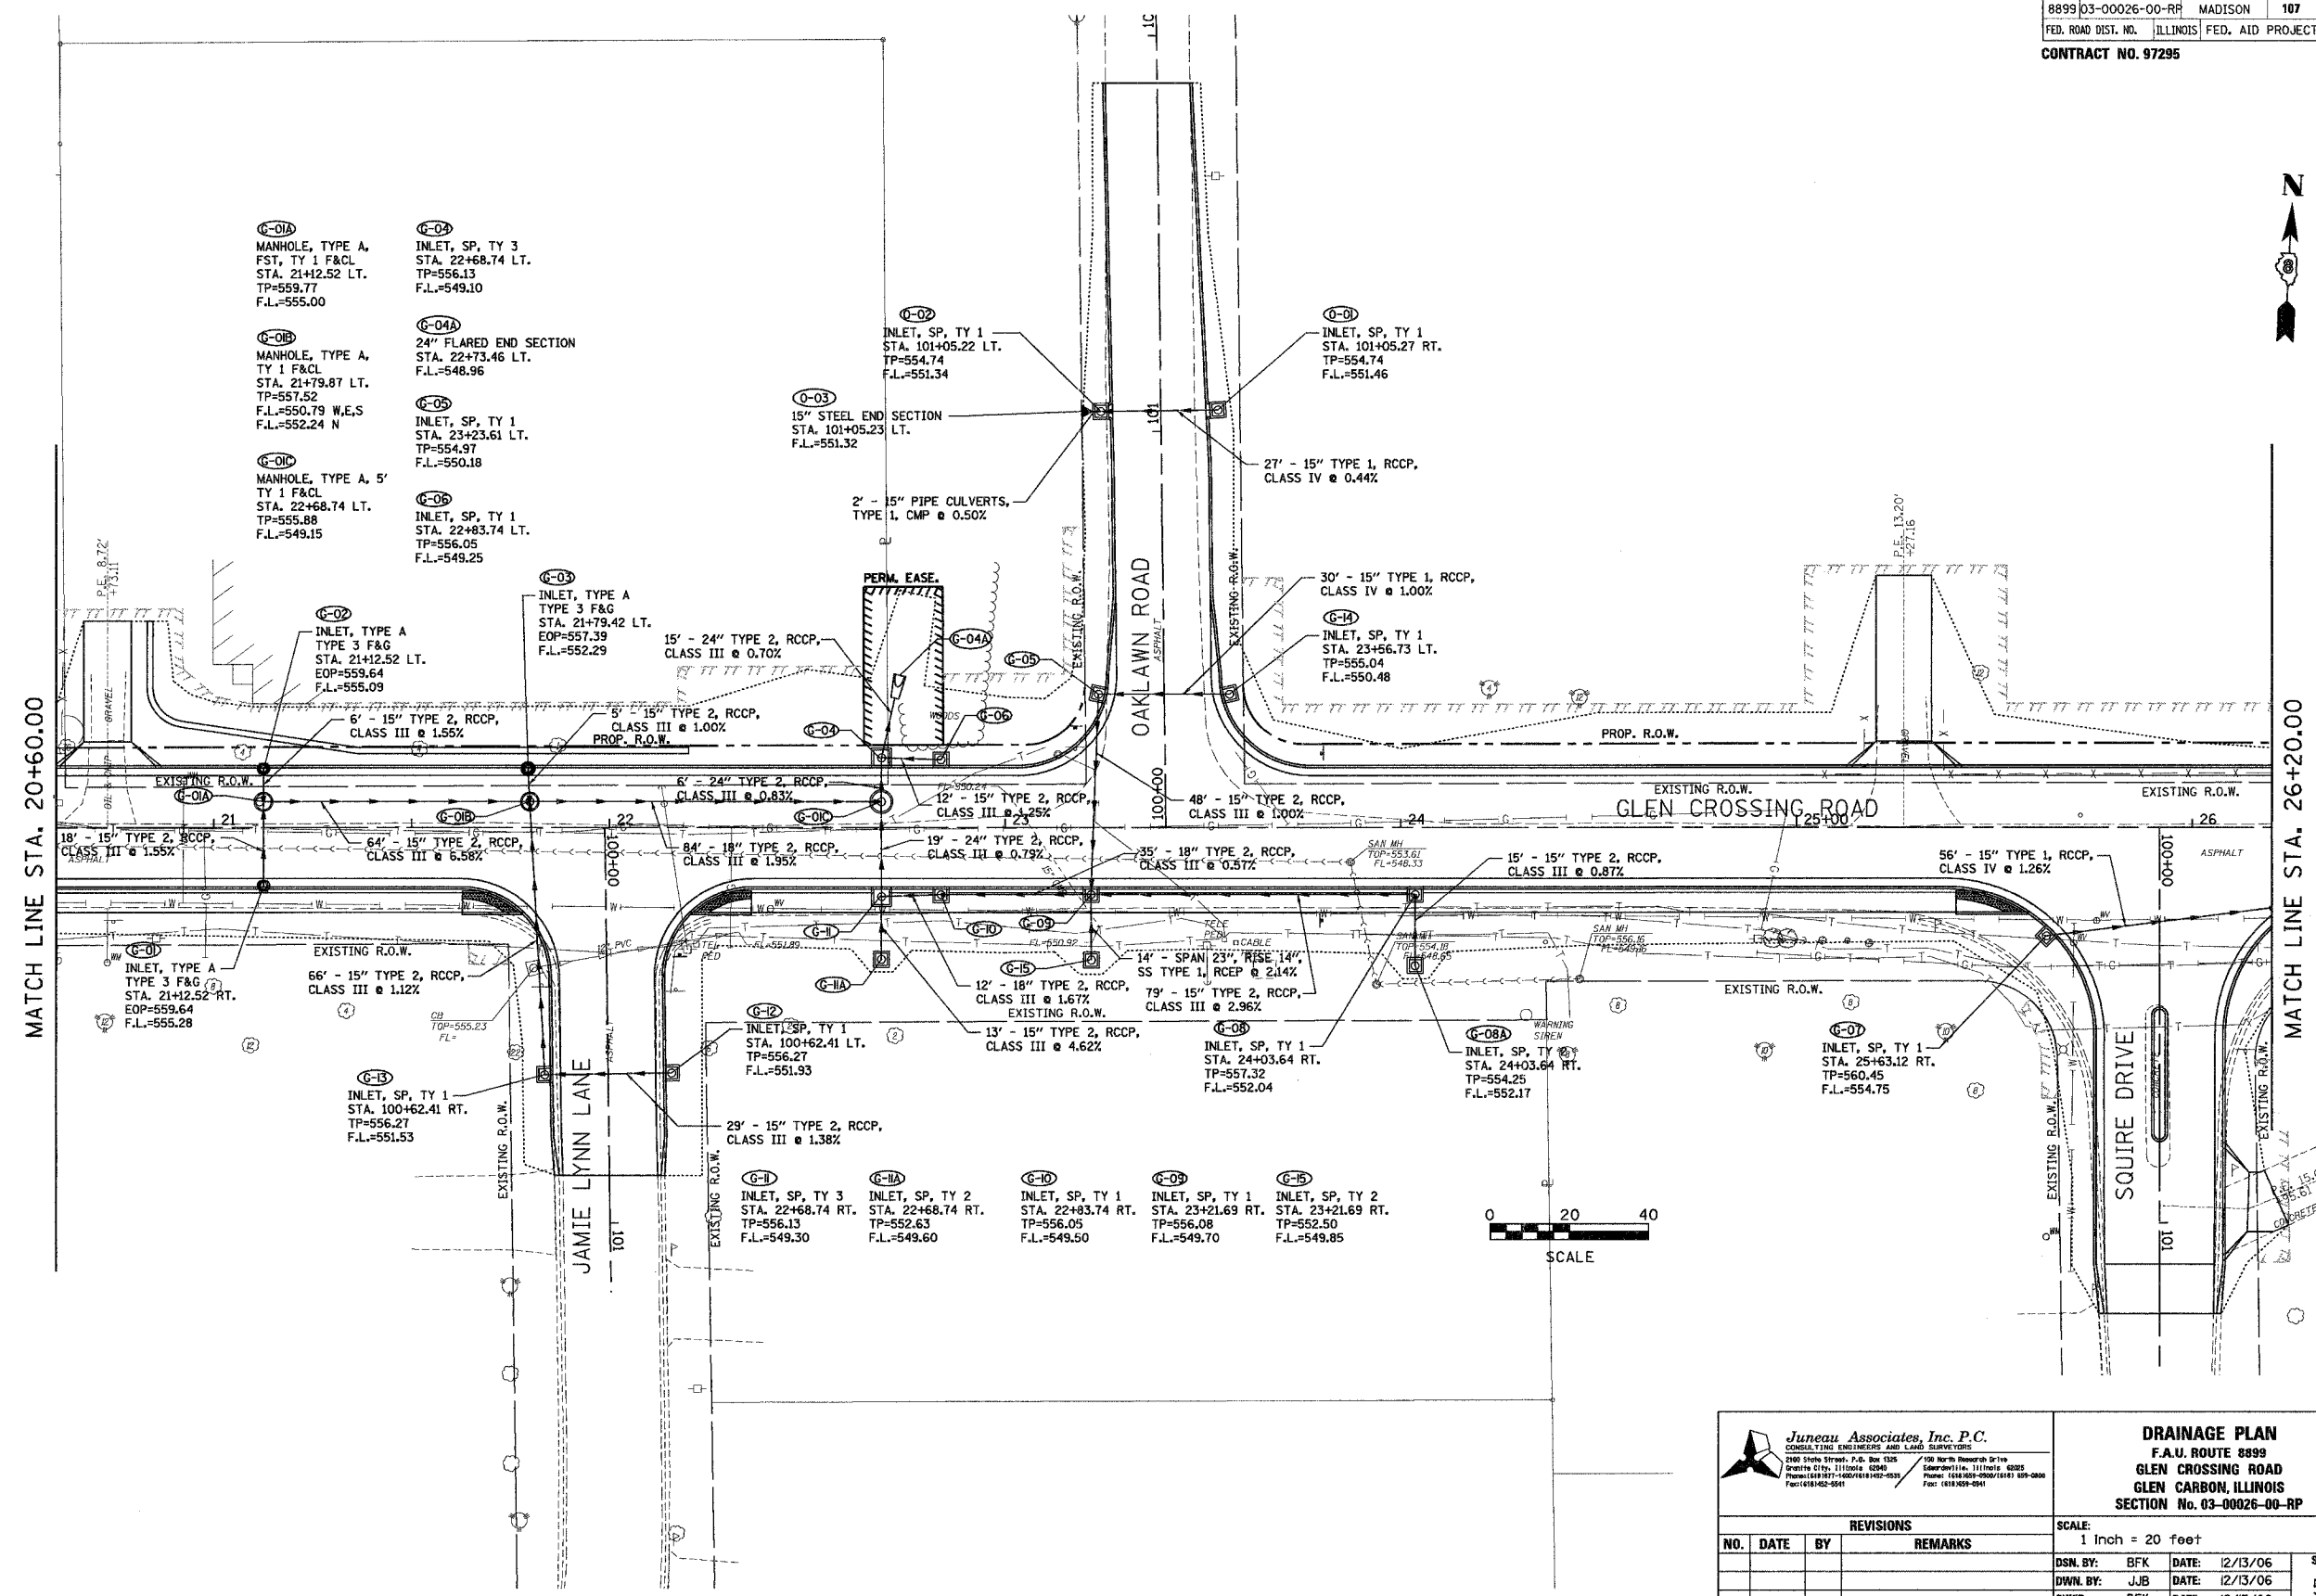

**Juneau Associates, Inc. P.C.**  
 CONSULTING ENGINEERS AND LAND SURVEYORS  
 2100 State Street, P.O. Box 1325  
 Granite City, Illinois 62040  
 Phone: (618) 937-1000 FAX: (618) 937-1001  
 100 North Research Drive  
 Edwardsville, Illinois 62025  
 Phone: (618) 592-0000 FAX: (618) 592-0001

**DRAINAGE PLAN**  
**F.A.U. ROUTE 8999**  
**GLEN CROSSING ROAD**  
**GLEN CARBON, ILLINOIS**  
**SECTION No. 03-00026-00-RP**

REVISIONS			
NO.	DATE	BY	REMARKS

SCALE: 1 Inch = 20 feet			
DSN. BY:	BFK	DATE:	12/13/06
DWN. BY:	JUB	DATE:	12/13/06
CHKD:	BFK	DATE:	12/13/06
DWG. NO.	JOB NO. 040630	DGN. NAME:	DRANS OF 107 SHTS