

GENERAL NOTES


1. CONTRACTOR SHALL LOCATE ALL EXISTING UTILITIES PRIOR TO BEGINNING CONSTRUCTION.
2. UNLESS NOTED OTHERWISE, ALL CONDUIT SHALL BE PVC.
3. ROUTE CONDUITS AROUND TREE PLANTING AREAS.
4. ALL LIGHTING SHALL REMAIN OPERATIONAL UNTIL NEW IS INSTALLED AND MADE OPERATIONAL.
5. CONTRACTOR SHALL REMOVE ALL EXISTING WIRING FROM LIGHT FIXTURES BEING REMOVED. WIRING SHALL BE REMOVED TO THE SOURCE. REMOVE ENTIRE CONCRETE FOUNDATION, ANCHOR BOLTS AND EXPOSED CONDUIT.

KEYED NOTES

- 1 EXISTING UTILITY POLE TO REMAIN.
- 2 EXISTING TRAFFIC CONTROLLER TO REMAIN.
- 3 EXISTING CLOCK TO REMAIN.
- 4 EXISTING SERVICE TO BE REMOVED AND REPLACED.
- 5 EXISTING SERVICE TO BE REMOVED.
- 6 EXISTING SL/TRAFFIC STANDARD TO REMAIN.
- 7 EXISTING LIGHT FIXTURE TO REMAIN. ENSURE CONTINUITY OF WIRE THROUGHOUT CONSTRUCTION.
- 8 EXISTING LIGHT FIXTURE TO BE REMOVED. PROTECT EXISTING WIRE AND CONDUIT TO ENSURE CONTINUITY THROUGHOUT CONSTRUCTION AND ALLOW FOR RECONNECTION.

LEGEND

- SL EXISTING STREET LIGHT TO BE REMOVED.
- DEC DECORATIVE LIGHT FIXTURE TO BE REMOVED. DELIVER FIXTURE AND POLE INTACT TO CITY OF BELLEVILLE.
- DEC DECORATIVE LIGHT FIXTURE TO BE REPLACED IN PLACE.
- EXISTING GROUND MOUNTED LIGHT TO BE REMOVED.
- EXISTING FLOOD LIGHT TO BE REMOVED.
- BOL EXISTING BOLLARD TO REMAIN.

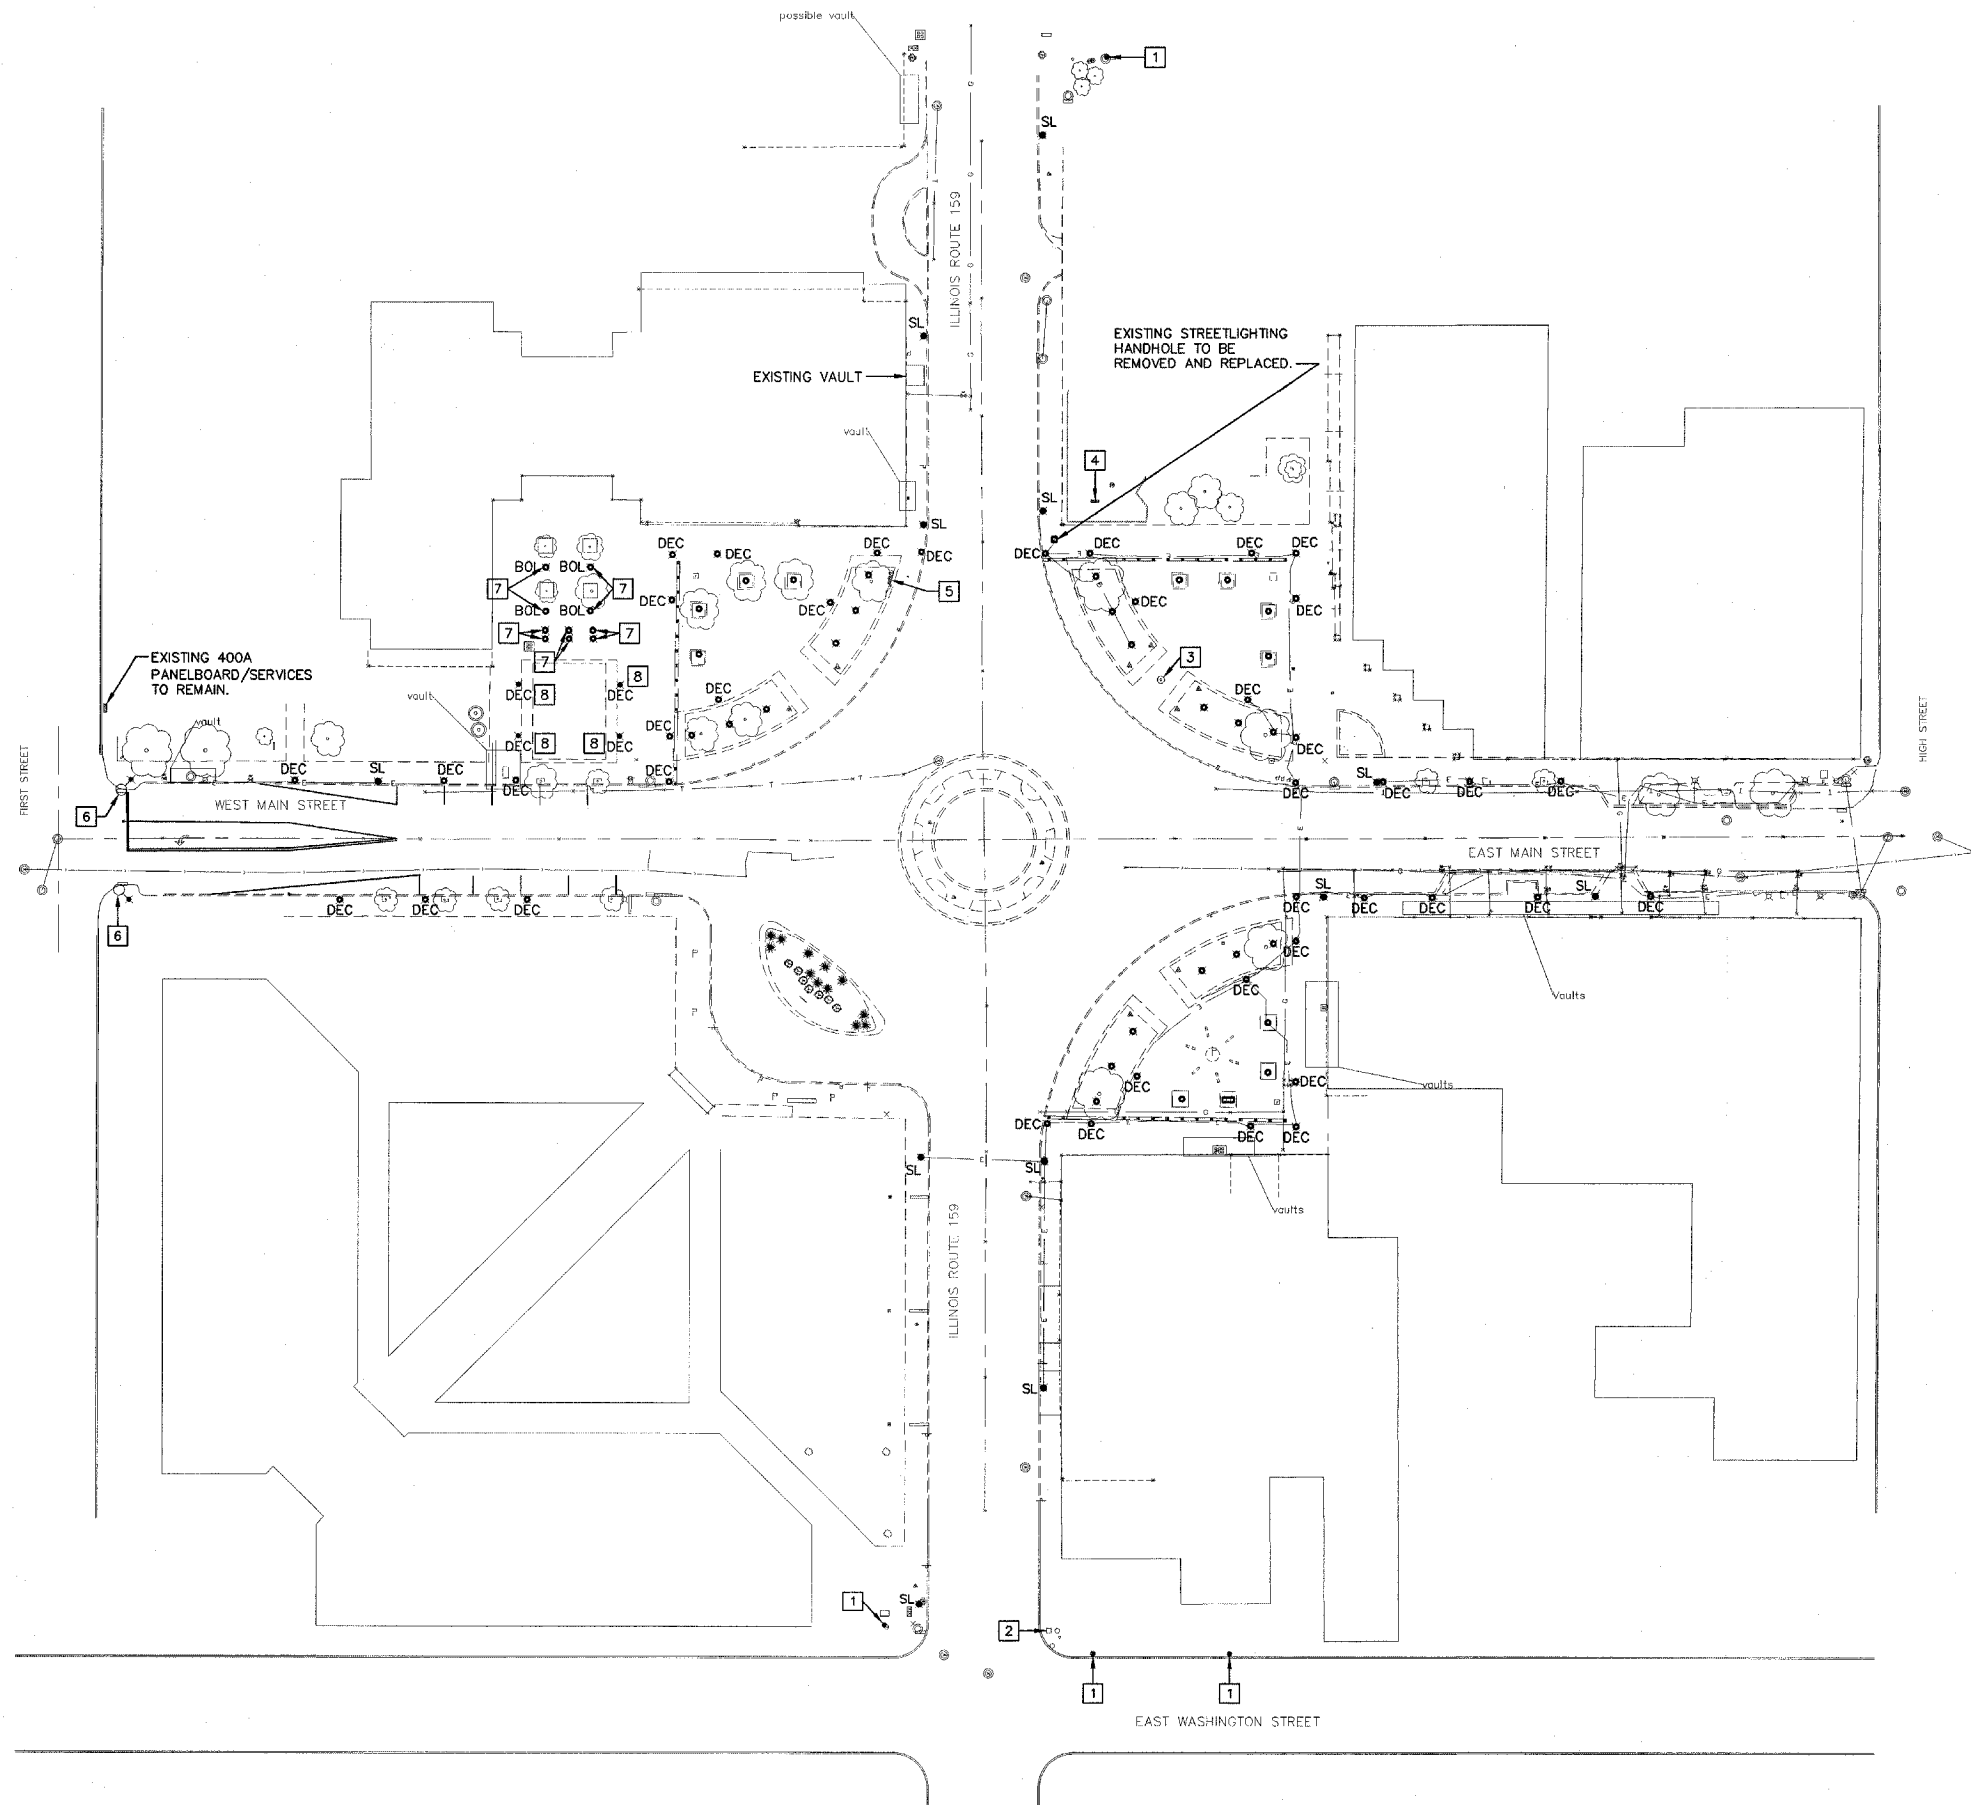


ELECTRICAL SITE PLAN - DEMOLITION

1" = 40'-0"



Kaskaskia Engineering Group L.L.C.
 23 Public Square Suite 404
 Belleville, Illinois 62220
 Office: (618)-233-5877 Fax: (618)-233-5977
 www.kaskasiaeng.com
 A Disadvantaged Business Enterprise

PREPARED BY: 
 LICENSE NO. 184,007/0
 PROFESSIONAL REGISTRATIONS ILLINOIS PROFESSIONAL DESIGN FIRM PROFESSIONAL ENGINEERING CORP.

BRIC
 PARTNERSHIP, LLC
 CONSULTING ENGINEERS
 100 EAST WASHINGTON, SUITE 220
 BELLEVILLE, ILLINOIS 62220
 TEL: 618.277.5200 FAX: 618.277.5227

SEAL

Signature: _____

Expiration Date: _____

REV	DATE	DESCRIP

SHEET TITLE: **ELECTRICAL SITE PLAN - DEMOLITION**

PROJECT TITLE: **BELLEVILLE SQUARE CITY OF BELLEVILLE ST. CLAIR COUNTY, ILLINOIS**

DESIGNED BY: ESF	SHEET
DRAWN BY: GYK/ESF	32
CHECKED BY: BEC	DE1.0
DATE OF PRELIMINARY: 08/17/2007	
DATE OF FINAL:	

SHEET NO. 1 OF 13 SHEETS
 PROJECT NUMBER 07-0041