
 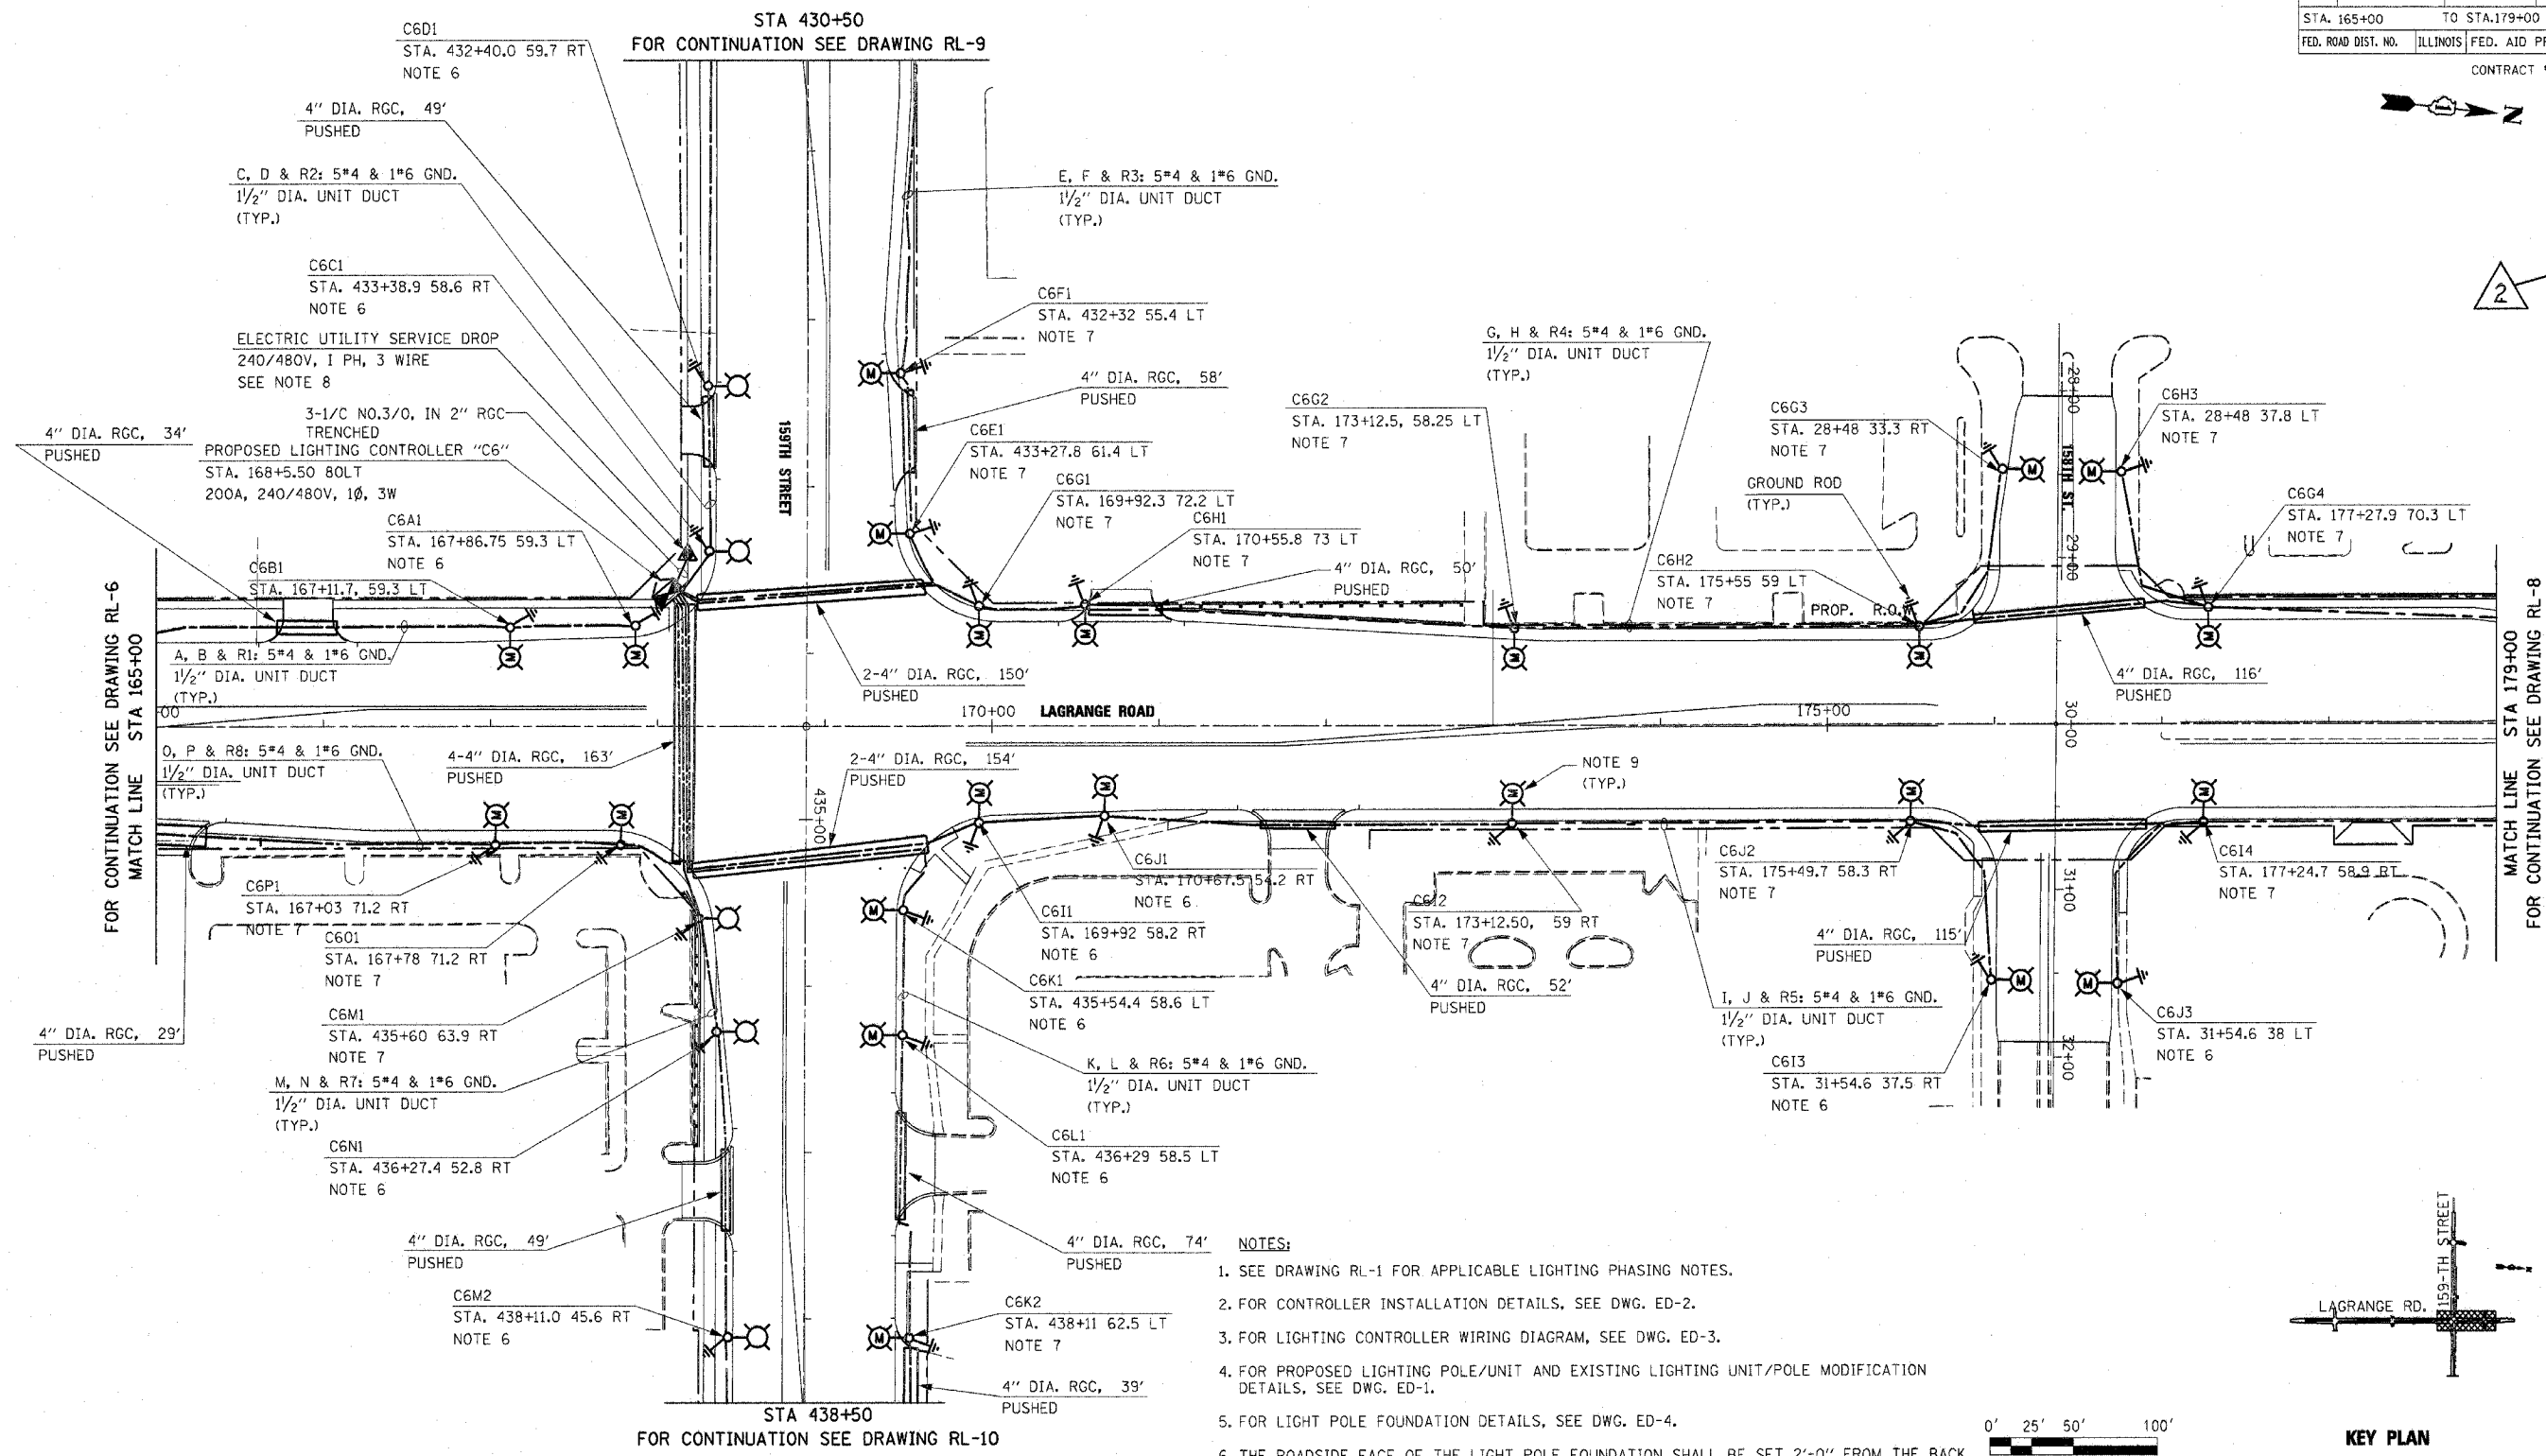




F.A.P. RTE.	SECTION	COUNTY	TOTAL SHEETS	SHEET NO.
351	537 R-1	COOK	245	166
STA. 165+00		TO STA. 179+00		
FED. ROAD DIST. NO.		ILLINOIS	FED. AID PROJECT	
CONTRACT # 62880				



FOR CONTINUATION SEE DRAWING RL-6
MATCH LINE STA 165+00

MATCH LINE STA 179+00
FOR CONTINUATION SEE DRAWING RL-8

 - NOTES:**
- SEE DRAWING RL-1 FOR APPLICABLE LIGHTING PHASING NOTES.
 - FOR CONTROLLER INSTALLATION DETAILS, SEE DWG. ED-2.
 - FOR LIGHTING CONTROLLER WIRING DIAGRAM, SEE DWG. ED-3.
 - FOR PROPOSED LIGHTING POLE/UNIT AND EXISTING LIGHTING UNIT/POLE MODIFICATION DETAILS, SEE DWG. ED-1.
 - FOR LIGHT POLE FOUNDATION DETAILS, SEE DWG. ED-4.
 - THE ROADSIDE FACE OF THE LIGHT POLE FOUNDATION SHALL BE SET 2'-0" FROM THE BACK OF CURB.
 - INSTALL LIGHT POLE FOUNDATION ON THE BACK SIDE OF SIDEWALK.
 - FOR ELECTRIC SERVICE INSTALLATION DETAIL, SEE DWG. ED-5. THE EXACT LOCATION OF SERVICE POLE AND THE UTILITY SERVICE DROP TO BE DETERMINED IN THE FIELD.
 - INSTALL PREVIOUSLY REMOVED EXISTING LIGHTING UNIT ON A NEW FOUNDATION. THE CONTRACTOR SHALL REPLACE EXISTING 12'-0" MAST ARM WITH 15'-0" MAST ARM PRIOR TO THE INSTALLATION OF EXISTING LIGHTING UNIT ON A NEW FOUNDATION. THE COST OF THIS WORK SHALL BE INCLUDED IN THE COST OF "MODIFY EXISTING LIGHT POLE, ALUMINUM 47.5 FT M.H., WITH NEW 15 FT MAST ARM AND 20A, 120V, GFI RECEPTACLE" PAY ITEM. NO SEPARATE PAYMENT WILL BE MADE.

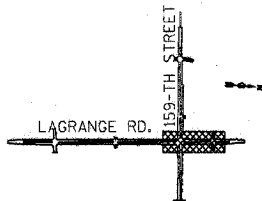

KEY PLAN
RL-7

REVISIONS	
NAME	DATE

ILLINOIS DEPARTMENT OF TRANSPORTATION
US RTE 6 (159TH ST) AT US RTE 45 (LAGRANGE RD)
**LAGRANGE ROAD (US45)
PROPOSED LIGHTING PLAN
STA 165+00 TO STA 179+00**
SCALE: 1" = 50'
DATE: 7-07-06
DRAWN BY: MB
CHECKED BY: KMY



E:\Elec\CADD\RL-7.dgn
10/28/2006
7:42:21 PM