


CIRCUIT	AMPS	VA
A	10.5	2520
B	10.5	2520
C	10.5	2520
D	7.0	1680
E	10.5	2520
F	10.5	2520
G	19.3	4632
H	19.8	4752
TOTAL	98.6	23664

NOTE:
LOAD INFORMATION IS BASED ON THE FOLLOWING DATA:
250W HPS LUMINAIRE: 1.3AMP @240V
400W HPS LUMINAIRE: 2AMP @ 240V
750W HPS LUMINAIRE: 3.5AMP @ 240V

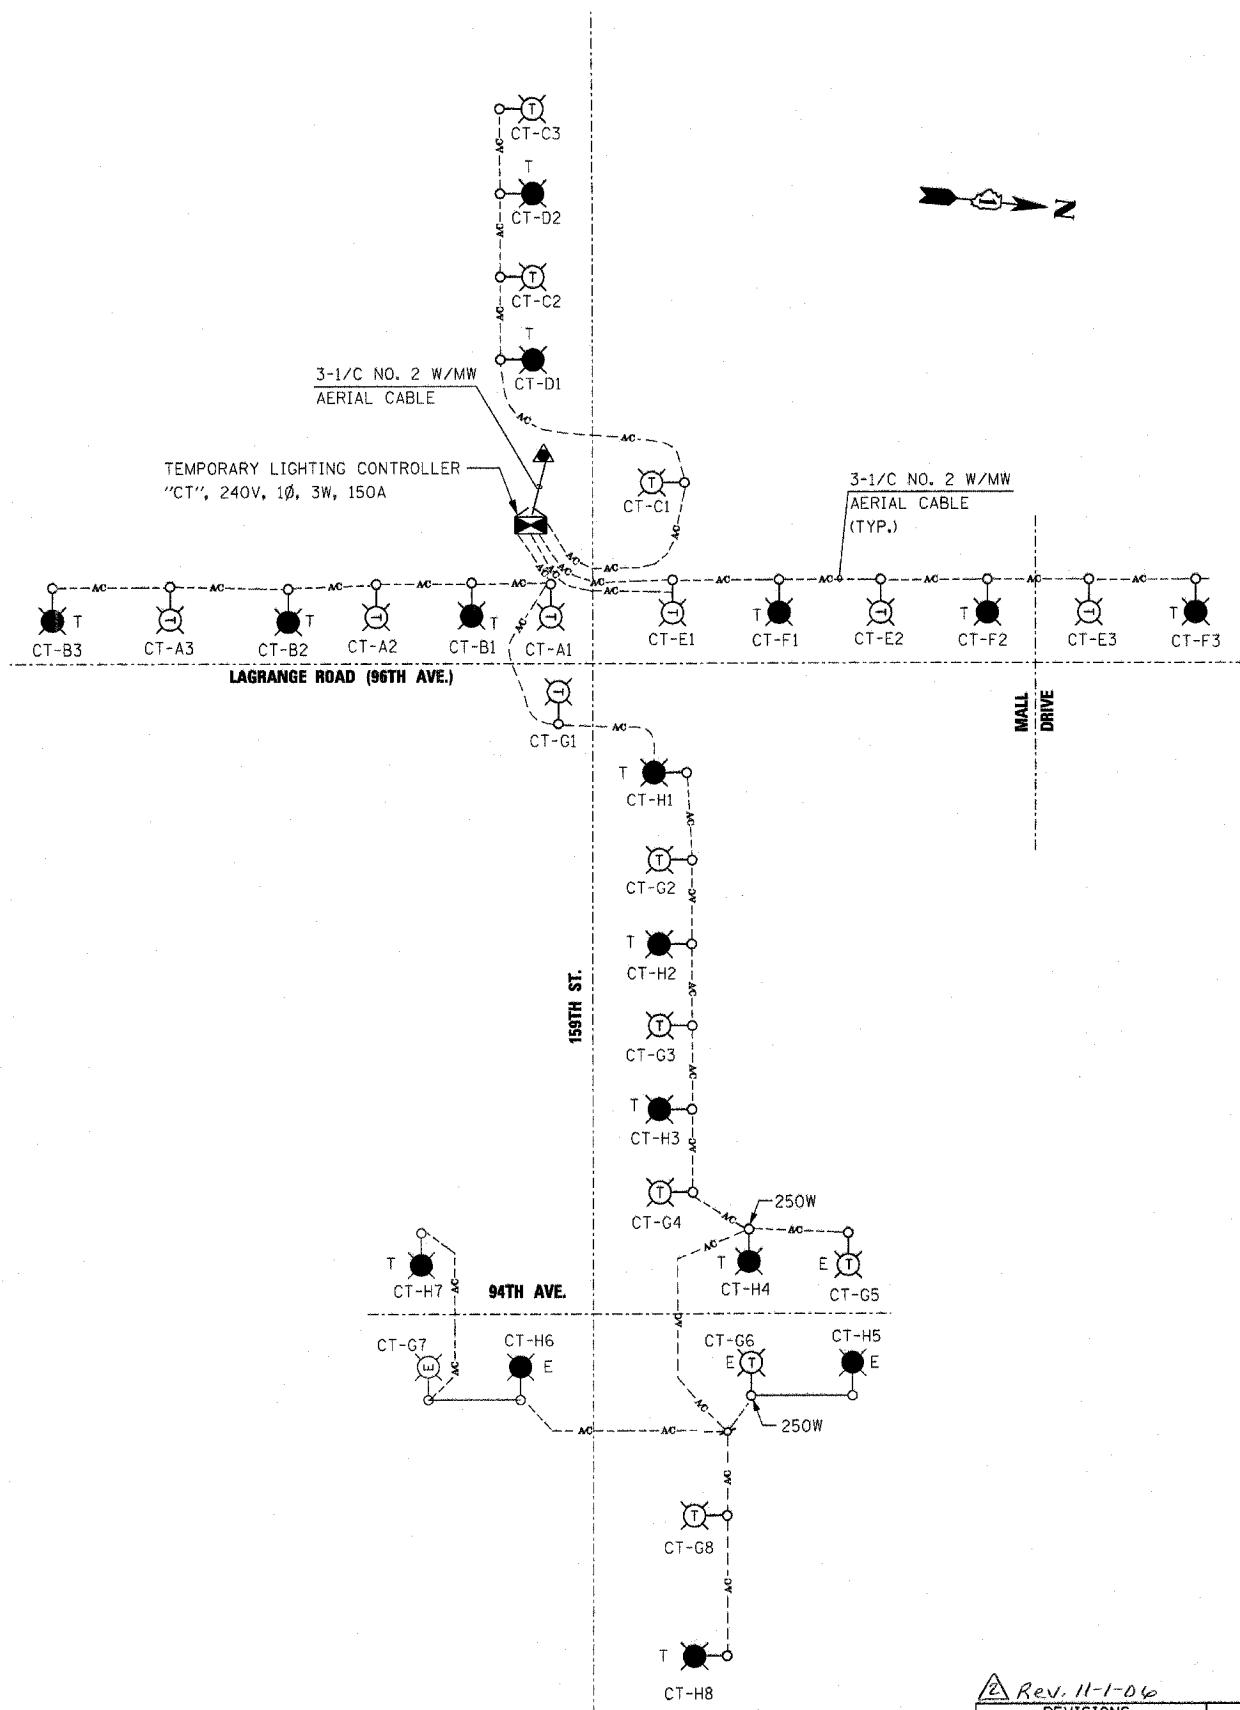

- LEGEND**
- TEMPORARY LIGHT UNIT ON RED CABLE
 - TEMPORARY LIGHT UNIT ON BLACK CABLE
 - EXISTING LIGHT UNIT ON RED CABLE
 - EXISTING LIGHT UNIT ON BLACK CABLE
 - TEMPORARY LIGHTING CONTROLLER
 - COMED SERVICE POLE
 - WOOD POLE

Rev. 11-1-06

REVISIONS	
NAME	DATE

ILLINOIS DEPARTMENT OF TRANSPORTATION
US RTE 6 (159TH ST) AT US RTE 45 (LAGRANGE RD)
**SINGLE LINE DIAGRAM
TEMPORARY LIGHTING CONTROLLER "CT"**
SCALE: NONE
DATE: 7-07-06
DRAWN BY: MB
CHECKED BY: KMY

McDonough Associates Inc.
Engineers / Architects

2

WE-2