
 
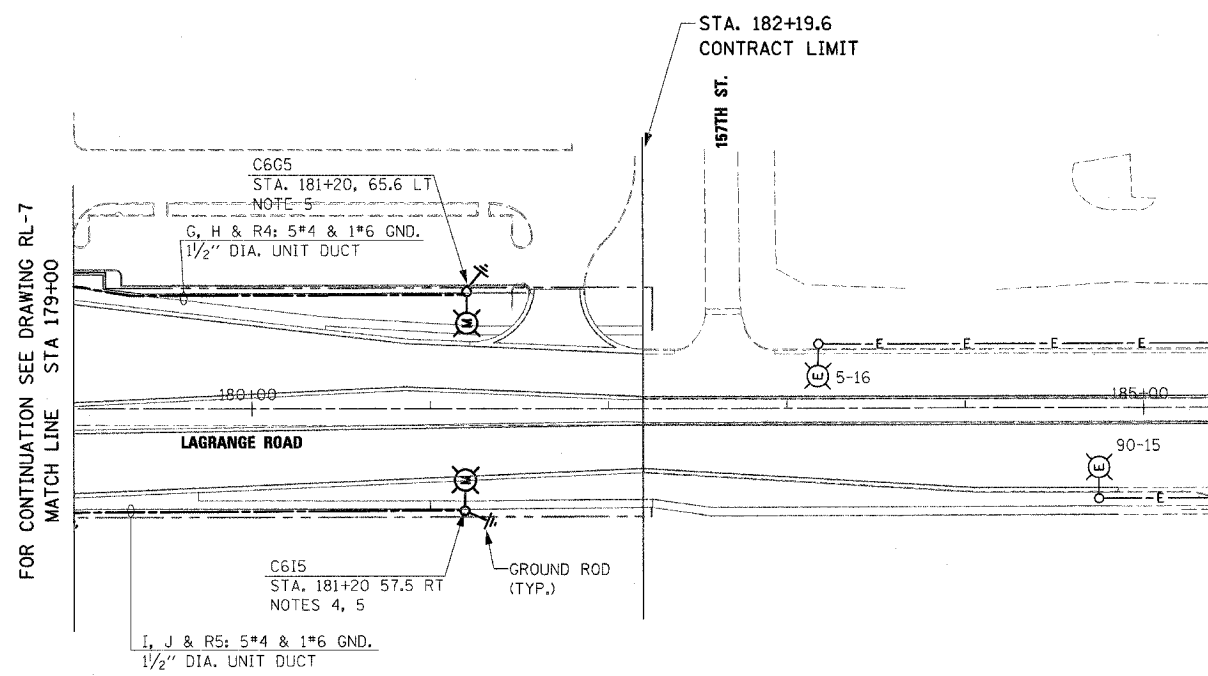



| | | | | |
|---------------------|----------|------------------|--------------|-----------|
| F.A.P. RTE. | SECTION | COUNTY | TOTAL SHEETS | SHEET NO. |
| 351 | 537 R-1 | COOK | 245 | 167 |
| STA. 179+00 | | TO STA. 183+50 | | |
| FED. ROAD DIST. NO. | ILLINOIS | FED. AID PROJECT | | |
| CONTRACT # 62880 | | | | |



- NOTES:**
1. SEE DRAWING RL-1 FOR APPLICABLE LIGHTING PHASING NOTES.
 2. FOR EXISTING LIGHTING UNIT/POLE MODIFICATION DETAIL, SEE DWG. ED-1.
 3. FOR LIGHT POLE FOUNDATION DETAILS, SEE DWG. ED-4.
 4. INSTALL LIGHT POLE FOUNDATION ON THE BACK SIDE OF SIDEWALK.
 5. INSTALL PREVIOUSLY REMOVED EXISTING LIGHTING UNIT ON A NEW FOUNDATION. THE CONTRACTOR SHALL REPLACE EXISTING 12'-0" MAST ARM WITH 15'-0" MAST ARM PRIOR TO THE INSTALLATION OF EXISTING LIGHTING UNIT ON A NEW FOUNDATION. THE COST OF THIS WORK SHALL BE INCLUDED IN THE COST OF "MODIFY EXISTING LIGHT POLE, ALUMINUM 47.5 FT M.H., WITH NEW 15 FT MAST ARM AND 20A, 120V, GFI RECEPTACLE" PAY ITEM. NO SEPARATE PAYMENT WILL BE MADE.

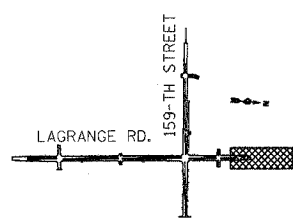

 KEY PLAN



RL-8

| REVISIONS | |
|-----------|------|
| NAME | DATE |
| | |
| | |
ILLINOIS DEPARTMENT OF TRANSPORTATION
US RTE 6 (159TH ST) AT US RTE 45 (LAGRANGE RD)
**LAGRANGE ROAD (US45)
PROPOSED LIGHTING PLAN
STA 179+00 TO STA 182+19.6**

SCALE: 1" = 50' DRAWN BY: MB
DATE: 7-07-06 CHECKED BY: KMY

McDonough Associates Inc.
Engineers / Architects

5/11/06
 5/11/06
 5/11/06