



STATE OF ILLINOIS
DEPARTMENT OF TRANSPORTATION

ROUTE NO. F.A.I. 39	SECTION 50-4B	COUNTY LASALLE	SHEET NO. 160	SHEET NO. 138 313 SHEETS
FED. ROAD DIST. NO. 7		ILLINOIS FED. AID PROJECT		

Contract # 66586

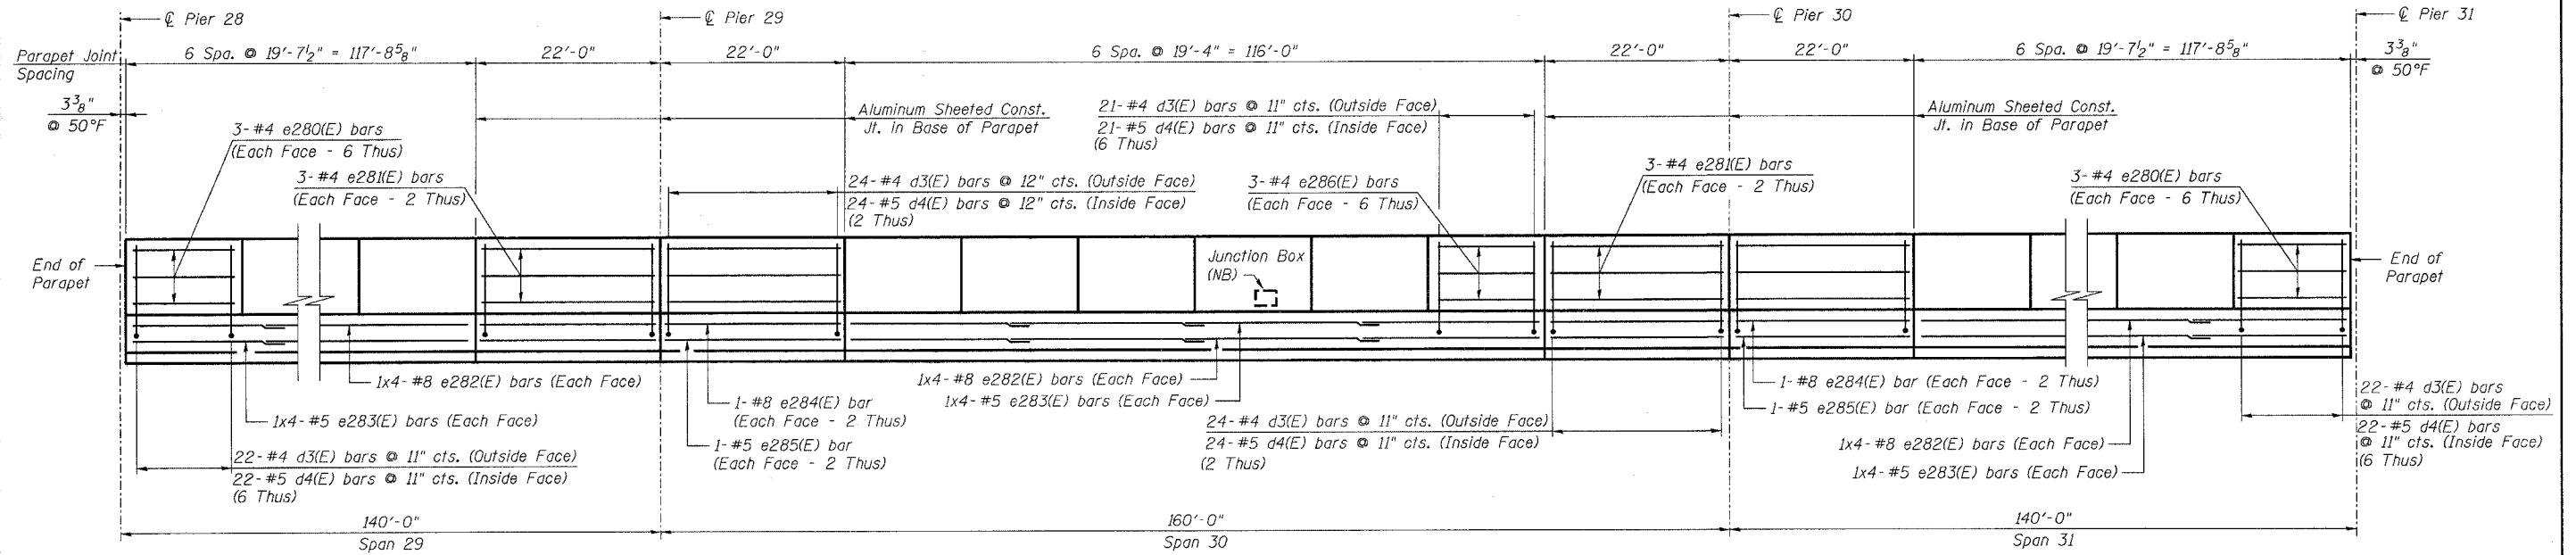

INSIDE ELEVATION OF OUTSIDE PARAPET - SB
REFLECTED INSIDE ELEVATION OF OUTSIDE PARAPET - NB

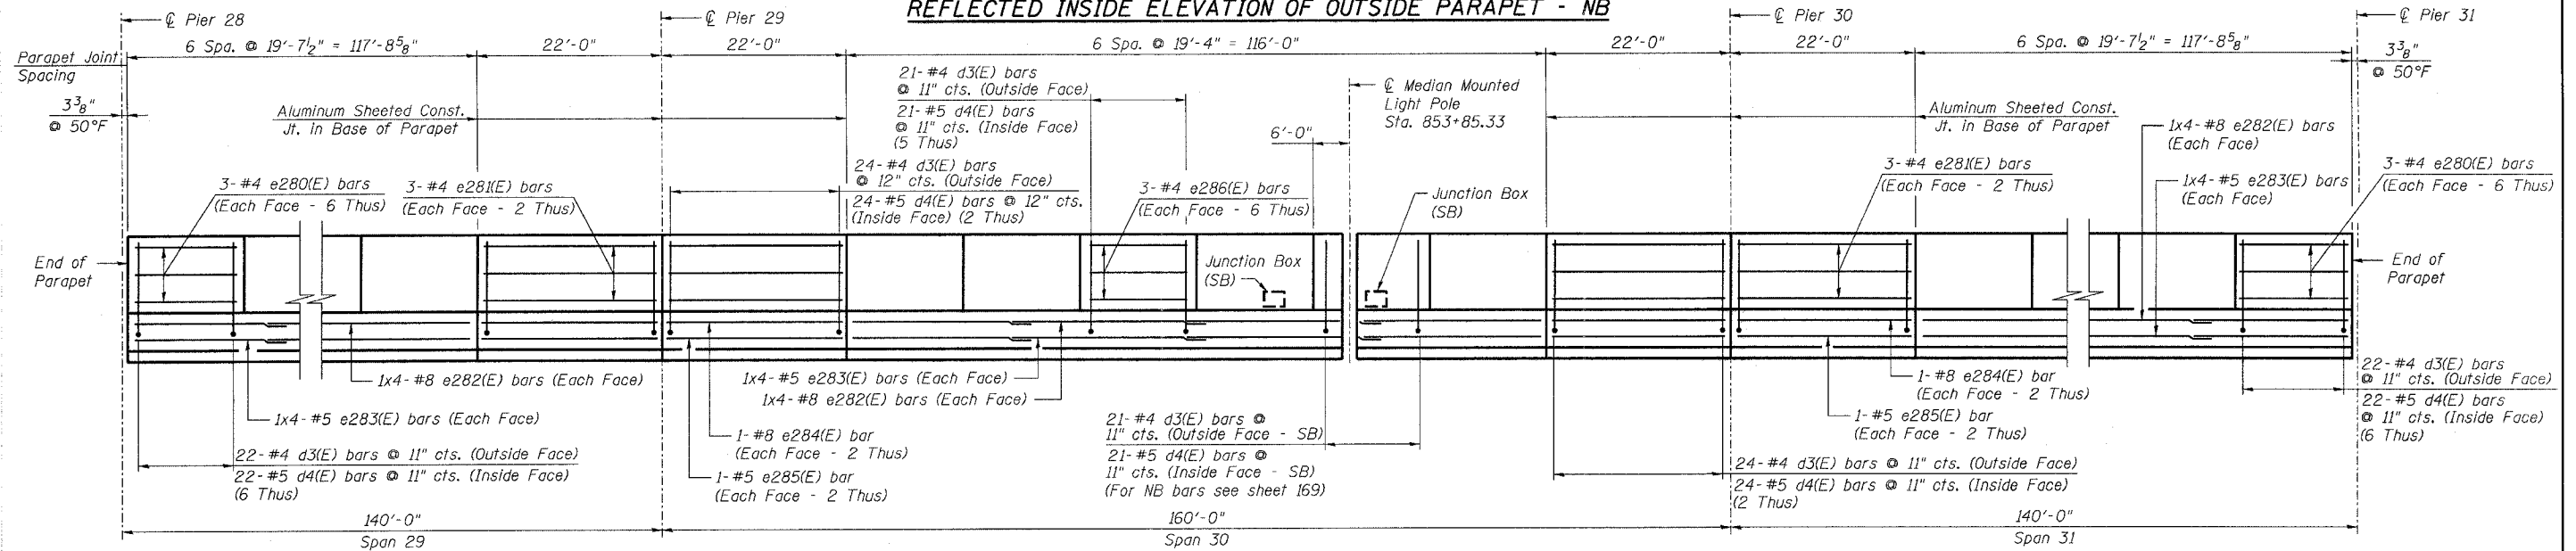

INSIDE ELEVATION OF MEDIAN PARAPET - NB
REFLECTED INSIDE ELEVATION OF MEDIAN PARAPET - SB

NOTES:

- Reinforcement bars designated (E) shall be epoxy coated.
- Bars indicated thus 3x4 - #4 etc. indicates 3 lines of bars with 4 lengths per line.
- Use the following minimum lap lengths unless otherwise noted:
 - #4 - 1'-8"
 - #5 - 2'-2"
 - #8 - 4'-6"
- For Bill of Material and Reinforcement schedule see sheet 139.
- All edges have 3/4" chamfer.
- For section through parapet see sheets 166 and 168.
- For Median Mounted Light Pole details and additional reinforcement see sheet 169.
- For Junction Box locations, see Electrical Plans.
- For additional rebar at Junction Box, see sheet 169.

PARAPET ELEVATIONS - SPANS 29 THRU 31
ABRAHAM LINCOLN MEMORIAL BRIDGE OVER
THE ILLINOIS RIVER (PUBLIC WATERS)
F.A.I. ROUTE 39 SEC. (50-4B) BR
LASALLE COUNTY
STATION 863+16.00
STRUCTURE NO. 050-0191 (SB & NB)

benesch

alfred benesch & company
Engineers • Surveyors • Planners
205 North Michigan Avenue, Suite 2400
Chicago, Illinois 60601
312-565-0450
Job # 3856

DESIGNED -	AJK
CHECKED -	KWS
DRAWN -	AR
CHECKED -	MRB

xx:\3800s\3856\structures\abe lincoln memorial\final\plans\AL-dkpp2931.sht

3:01:45 PM

10/16/2006