
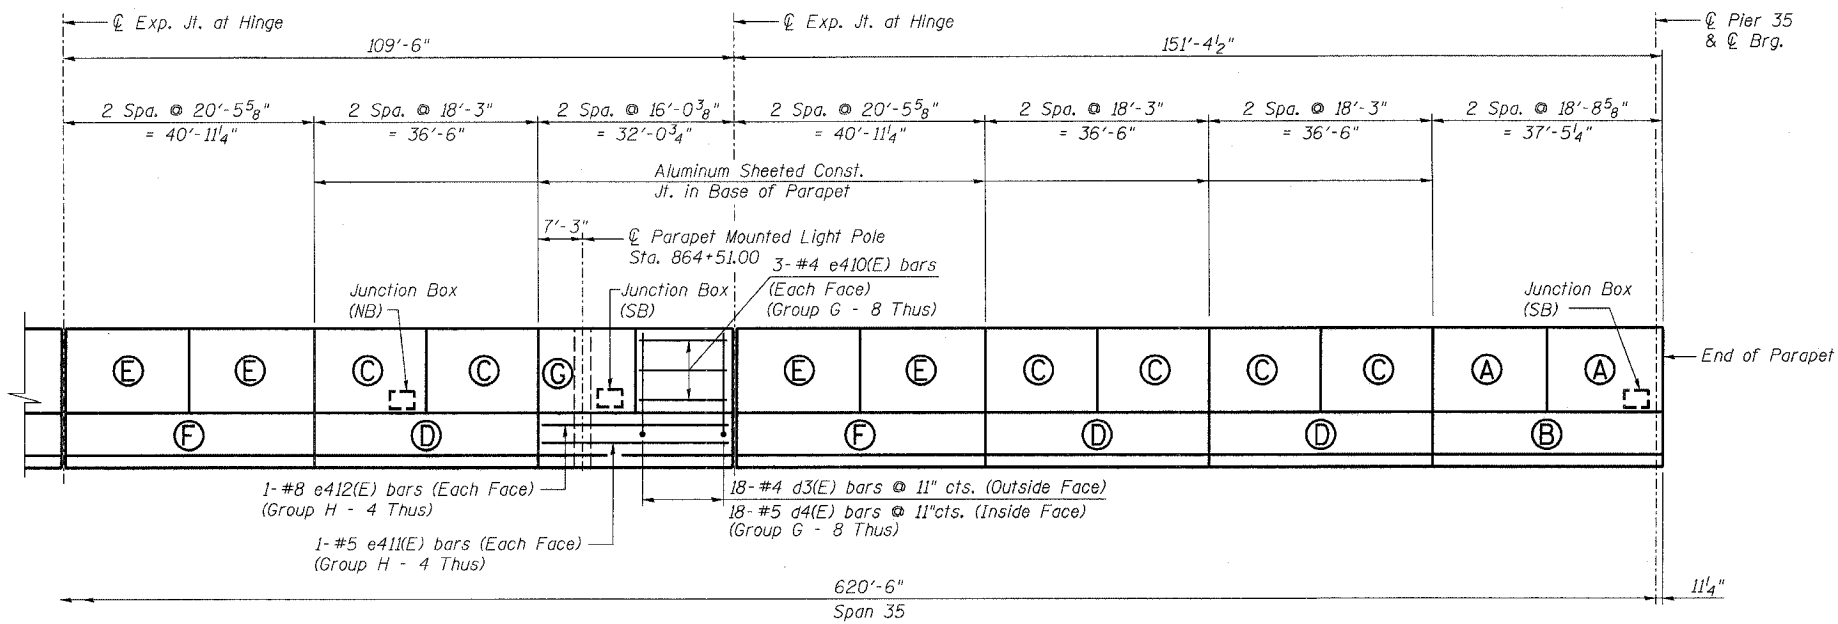


STATE OF ILLINOIS  
DEPARTMENT OF TRANSPORTATION

ROUTE NO.	SECTION	COUNTY	TOTAL SHEETS	SHEET	SHEET NO. 145 313 SHEETS
F.A.I. 39	50-4B	LASALLE		167	
FED. ROAD DIST. NO. 7	ILLINOIS	FED. AID PROJECT			

Contract # 66586

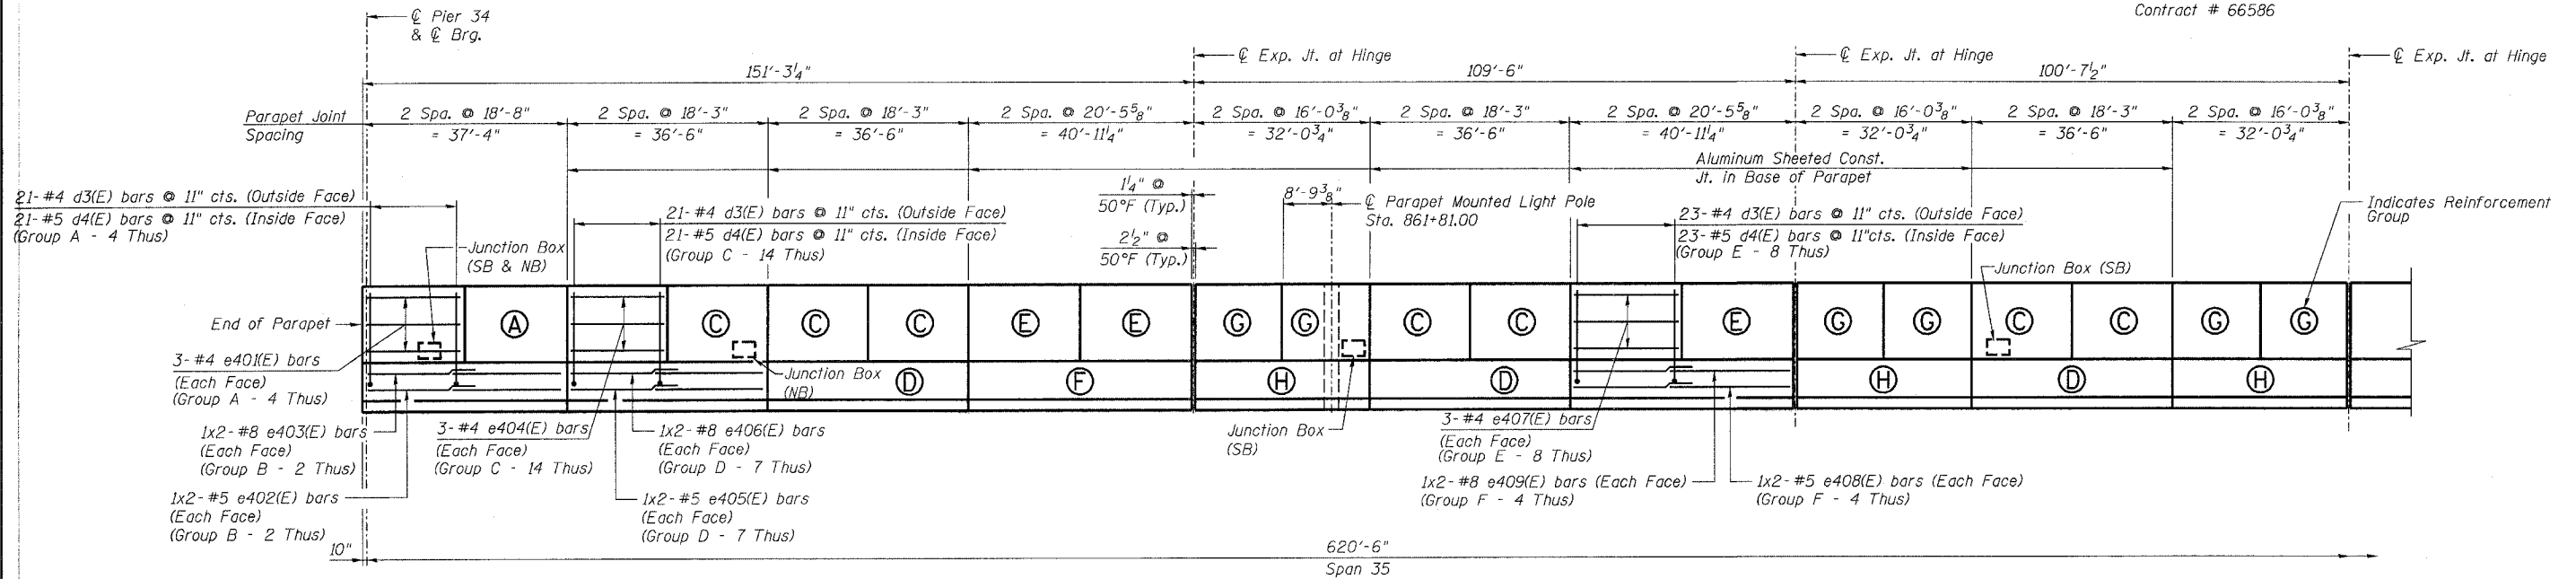

**INSIDE ELEVATION OF OUTSIDE PARAPET - SB**  
**REFLECTED INSIDE ELEVATION OF OUTSIDE PARAPET - NB**

**NOTES:**

1. Reinforcement bars designated (E) shall be epoxy coated.
2. Bars indicated thus 3x4 - #4 etc. indicates 3 lines of bars with 4 lengths per line.
3. Use the following minimum lap lengths unless otherwise noted:  
#4 - 1'-8"  
#5 - 2'-2"  
#8 - 4'-6"
4. For Bill of Material and Reinforcement schedule see sheet 147.
5. All edges have 3/4" chamfer.
6. For section through parapet see sheets 166 and 168.
7. For Parapet Mounted Light Pole details and additional reinforcement see sheet 169.
8. For Junction Box locations, see Electrical Plans.
9. For additional rebar at Junction Box, see sheet 169.

DESIGNED -	HAA
CHECKED -	AJK
DRAWN -	AR
CHECKED -	MRB

**benesch**

alfred benesch & company  
Engineers • Surveyors • Planners  
205 North Michigan Avenue, Suite 2400  
Chicago, Illinois 60601  
312-865-0450  
Job # 3856

**PARAPET ELEVATION - SPAN 35**  
**ABRAHAM LINCOLN MEMORIAL BRIDGE OVER**  
**THE ILLINOIS RIVER (PUBLIC WATERS)**  
**F.A.I. ROUTE 39 SEC. (50-4B) BR**  
**LASALLE COUNTY**  
**STATION 863+16.00**  
**STRUCTURE NO. 050-0191 (SB & NB)**

x:\3800s\3856\structures\abe lincoln memorial\final\plans\AL\_ekpp3535a.sht

3:01:49 PM

10/16/2006