



STATE OF ILLINOIS  
DEPARTMENT OF TRANSPORTATION

ROUTE NO. F.A.I. 39	SECTION 50-4B	COUNTY LASALLE	SHEET 178	SHEET NO. 156 313 SHEETS
FED. ROAD DIST. NO. 7		ILLINOIS FED. AID PROJECT		

Contract # 66586

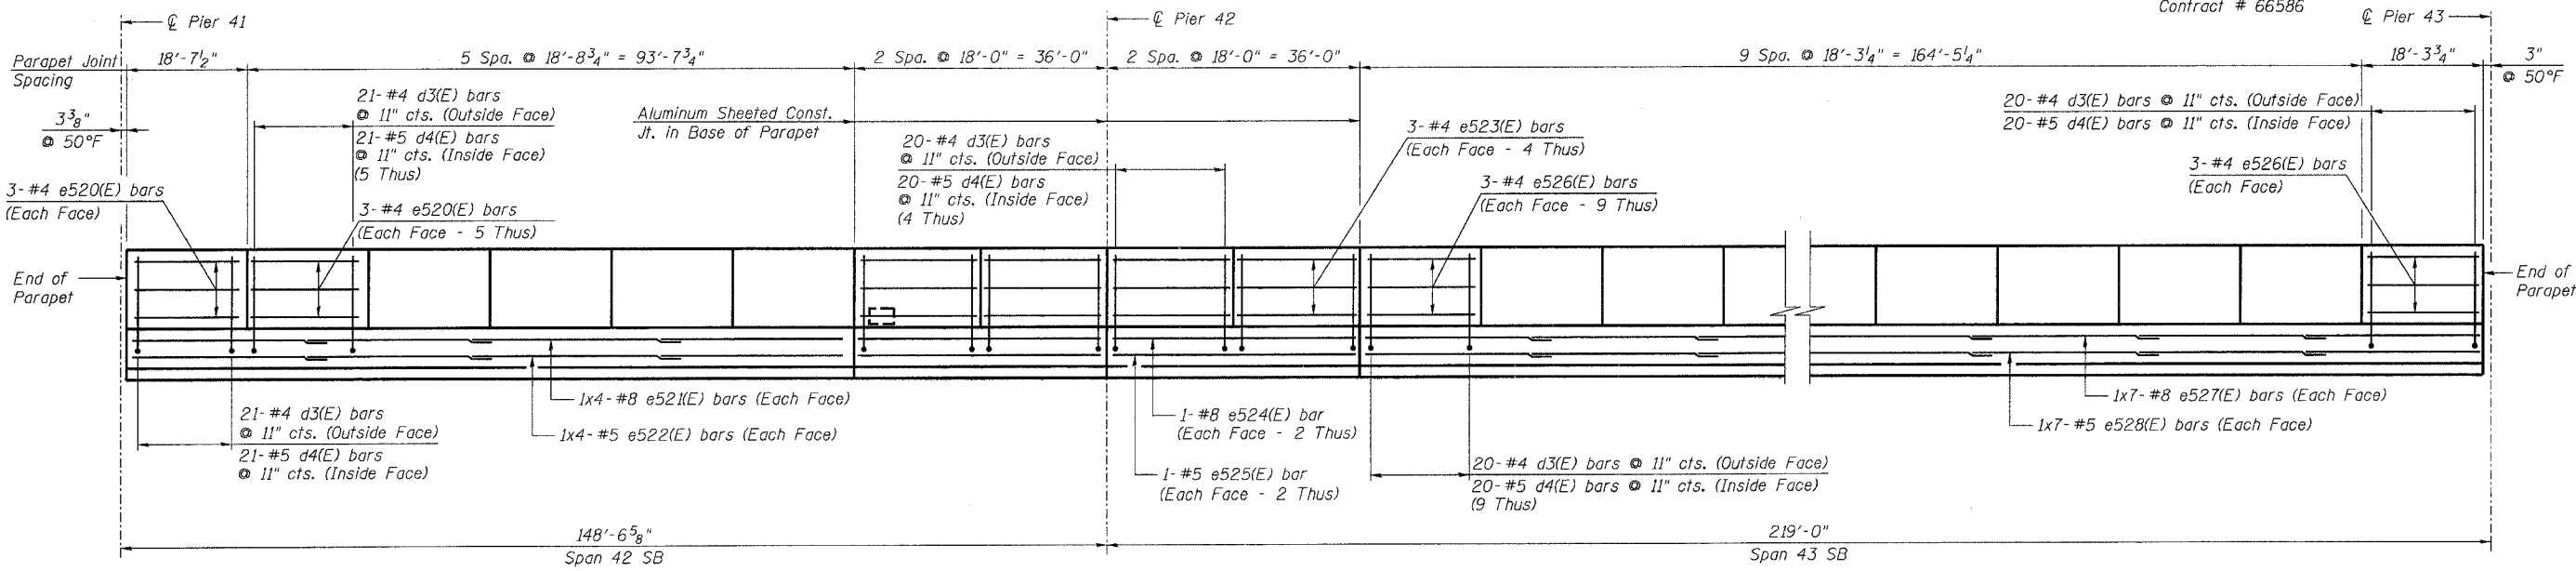

INSIDE ELEVATION OF OUTSIDE PARAPET - SB

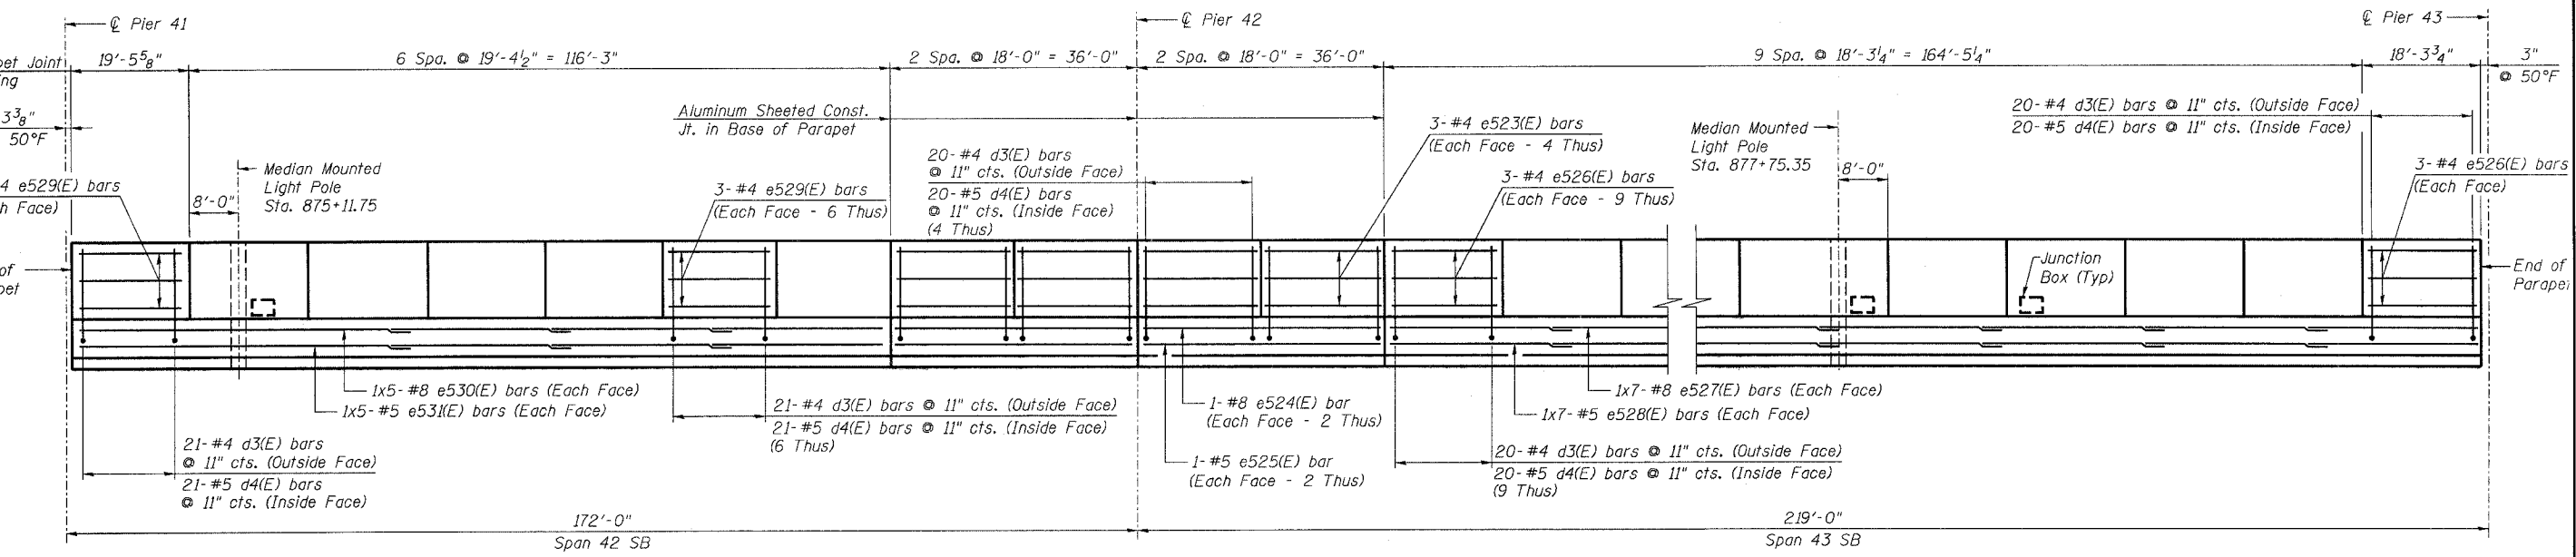

REFLECTED INSIDE ELEVATION OF MEDIAN PARAPET - SB

- NOTES:**
1. Reinforcement bars designated (E) shall be epoxy coated.
  2. Bars indicated thus 3x4 - #4 etc. indicates 3 lines of bars with 4 lengths per line.
  3. Use the following minimum lap lengths unless otherwise noted:
 

#4 - 1'-8"
#5 - 2'-2"
#8 - 4'-6"
  4. For Bill of Material and Reinforcement schedule see sheet 158.
  5. All edges have 3/4" chamfer.
  6. For section through parapet see sheets 166 and 168.
  7. For Median Mounted Light Pole details and additional reinforcement see sheet 169.
  8. For Junction Box locations, see Electrical Plans.
  9. For additional rebar at Junction Box, see sheet 169.

PARAPET ELEVATION - SPANS 42 AND 43 SB  
ABRAHAM LINCOLN MEMORIAL BRIDGE OVER  
THE ILLINOIS RIVER (PUBLIC WATERS)  
F.A.I. ROUTE 39 SEC. (50-4B) BR  
LASALLE COUNTY  
STATION 863+16.00  
STRUCTURE NO. 050-0191 (SB & NB)

**benesch**  
alfred benesch & company  
Engineers • Surveyors • Planners  
205 North Michigan Avenue, Suite 2400  
Chicago, Illinois 60601  
312-565-0450  
Job # 3856

DESIGNED -	AJK
CHECKED -	KWS
DRAWN -	AR
CHECKED -	MRB

10/16/2006 3:01:54 PM xx:\3800s\3856\structures\abe lincoln memorial\final\plans\al\_dkpp4243.sht