


F.A. RTE.	SECTION	COUNTY	TOTAL SHEETS	SHEET NO.
39	50-4B	LASALLE		343
STA.		TO STA.		
FED. ROAD DIST. NO.		ILLINOIS FED. AID PROJECT		

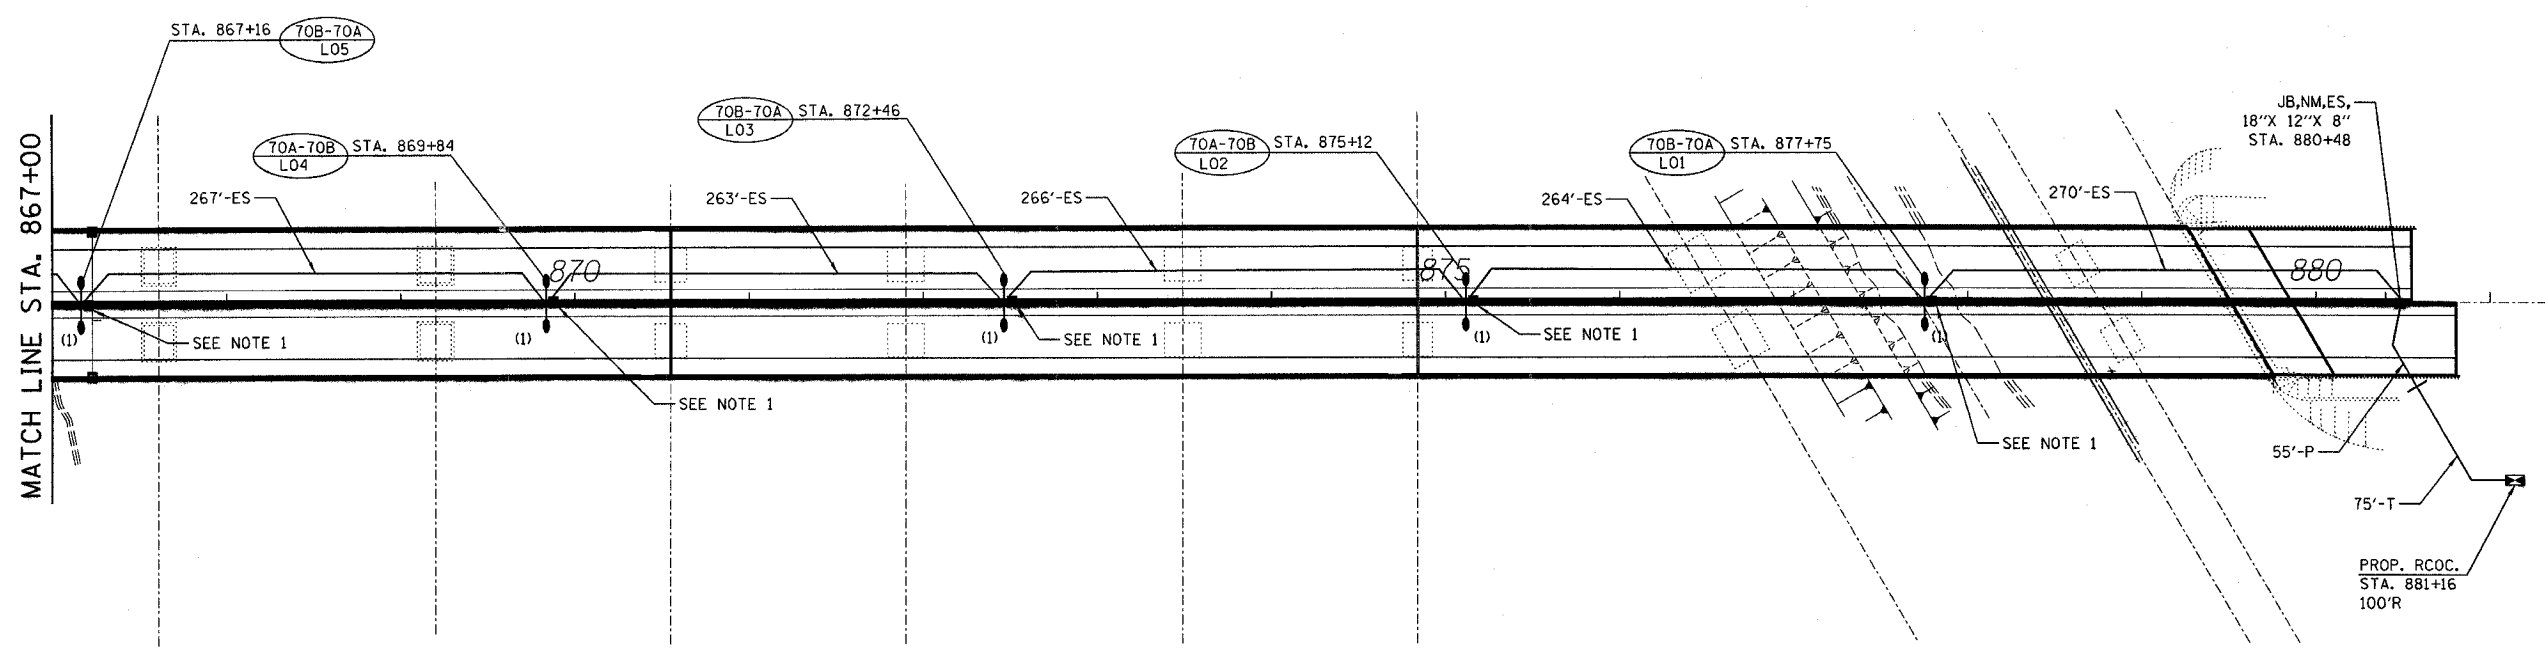

NOTES:

1. FOR JUNCTION BOX DETAIL NEXT TO PROPOSED LIGHTING UNIT, SEE 22 OF 22.

LIGHTING SHEET 7 OF 22

REVISIONS	
NAME	DATE

ILLINOIS DEPARTMENT OF TRANSPORTATION
 ABRAHAM LINCOLN MEMORIAL BRIDGE
 OVER THE ILLINOIS RIVER
 F.A.I. ROUTE 39
 PROPOSED LIGHTING PLAN
 STA. 866+00 TO STA. 881+00

SCALE: 1" = 50'
 DATE

DRAWN BY DJK
 CHECKED BY GHT

PLOT DATE = 10/17/2006
 FILE NAME = \\s380003\3856\electr\lca\lighting\plans\3856L\Plan05.dgn
 PLOT SCALE = 1/4" = 100'
 TIME = 3:04:46 PM