


F.A. RTE.	SECTION	COUNTY	TOTAL SHEETS	SHEET NO.
00-0094-03-BR	COOK		69	11
STA. 100+00	TO STA. 102+50			
FED. ROAD DIST. NO.	ILLINOIS	FED. AID PROJECT		
CONTRACT NO. 83850				

PLAN	SURVEYED	DATE
	ALIGNED	
	CHECKED	
	BY	
	NO.	

PROFILE	SURVEYED	DATE
	GRADES	
	NOTED	
	BY	
	NO.	

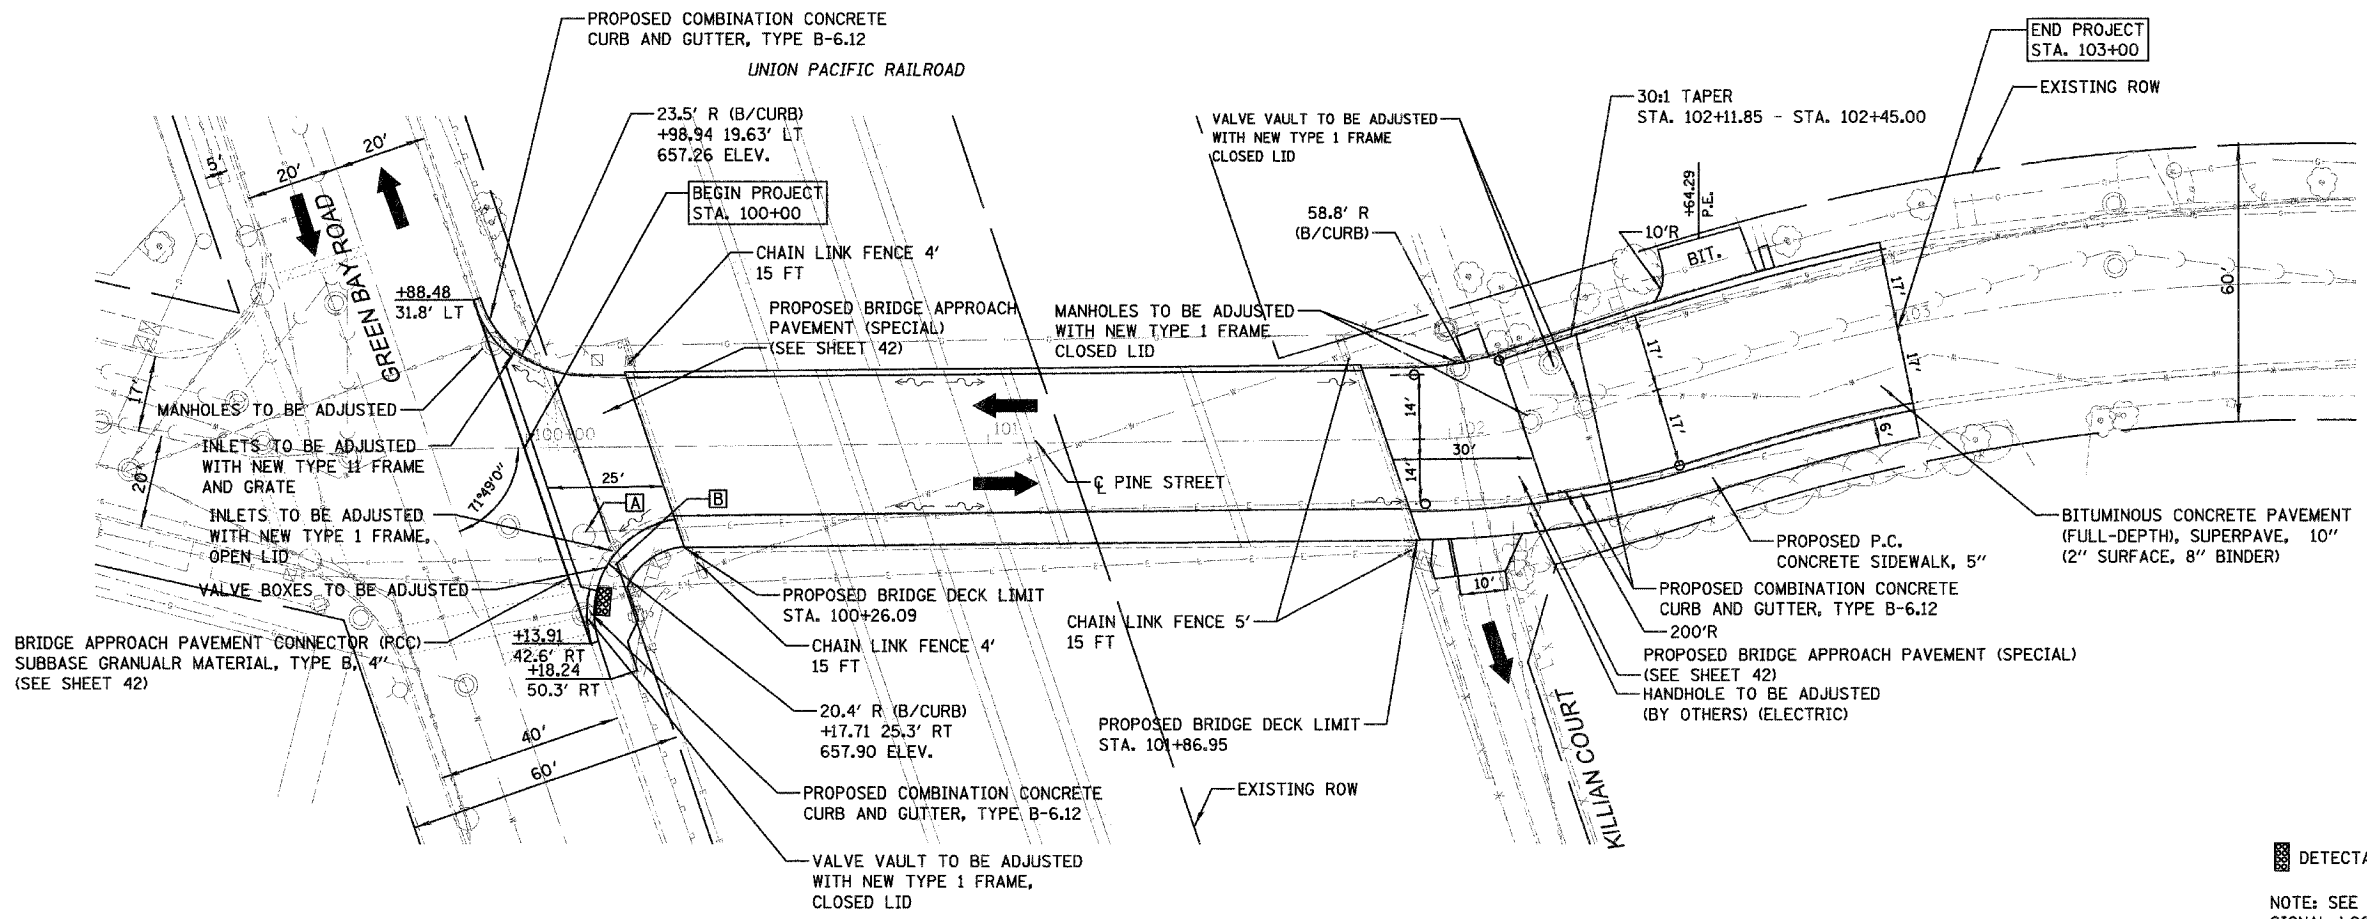


- [A] HANDHOLE TO BE ADJUSTED (BY OTHERS)
- [B] GAS VALVE TO BE ADJUSTED (BY OTHERS)

DETECTABLE WARNINGS

NOTE: SEE DETAIL SHEET FOR TRAFFIC SIGNAL LOOP DETECTOR INFORMATION.

# PINE STREET

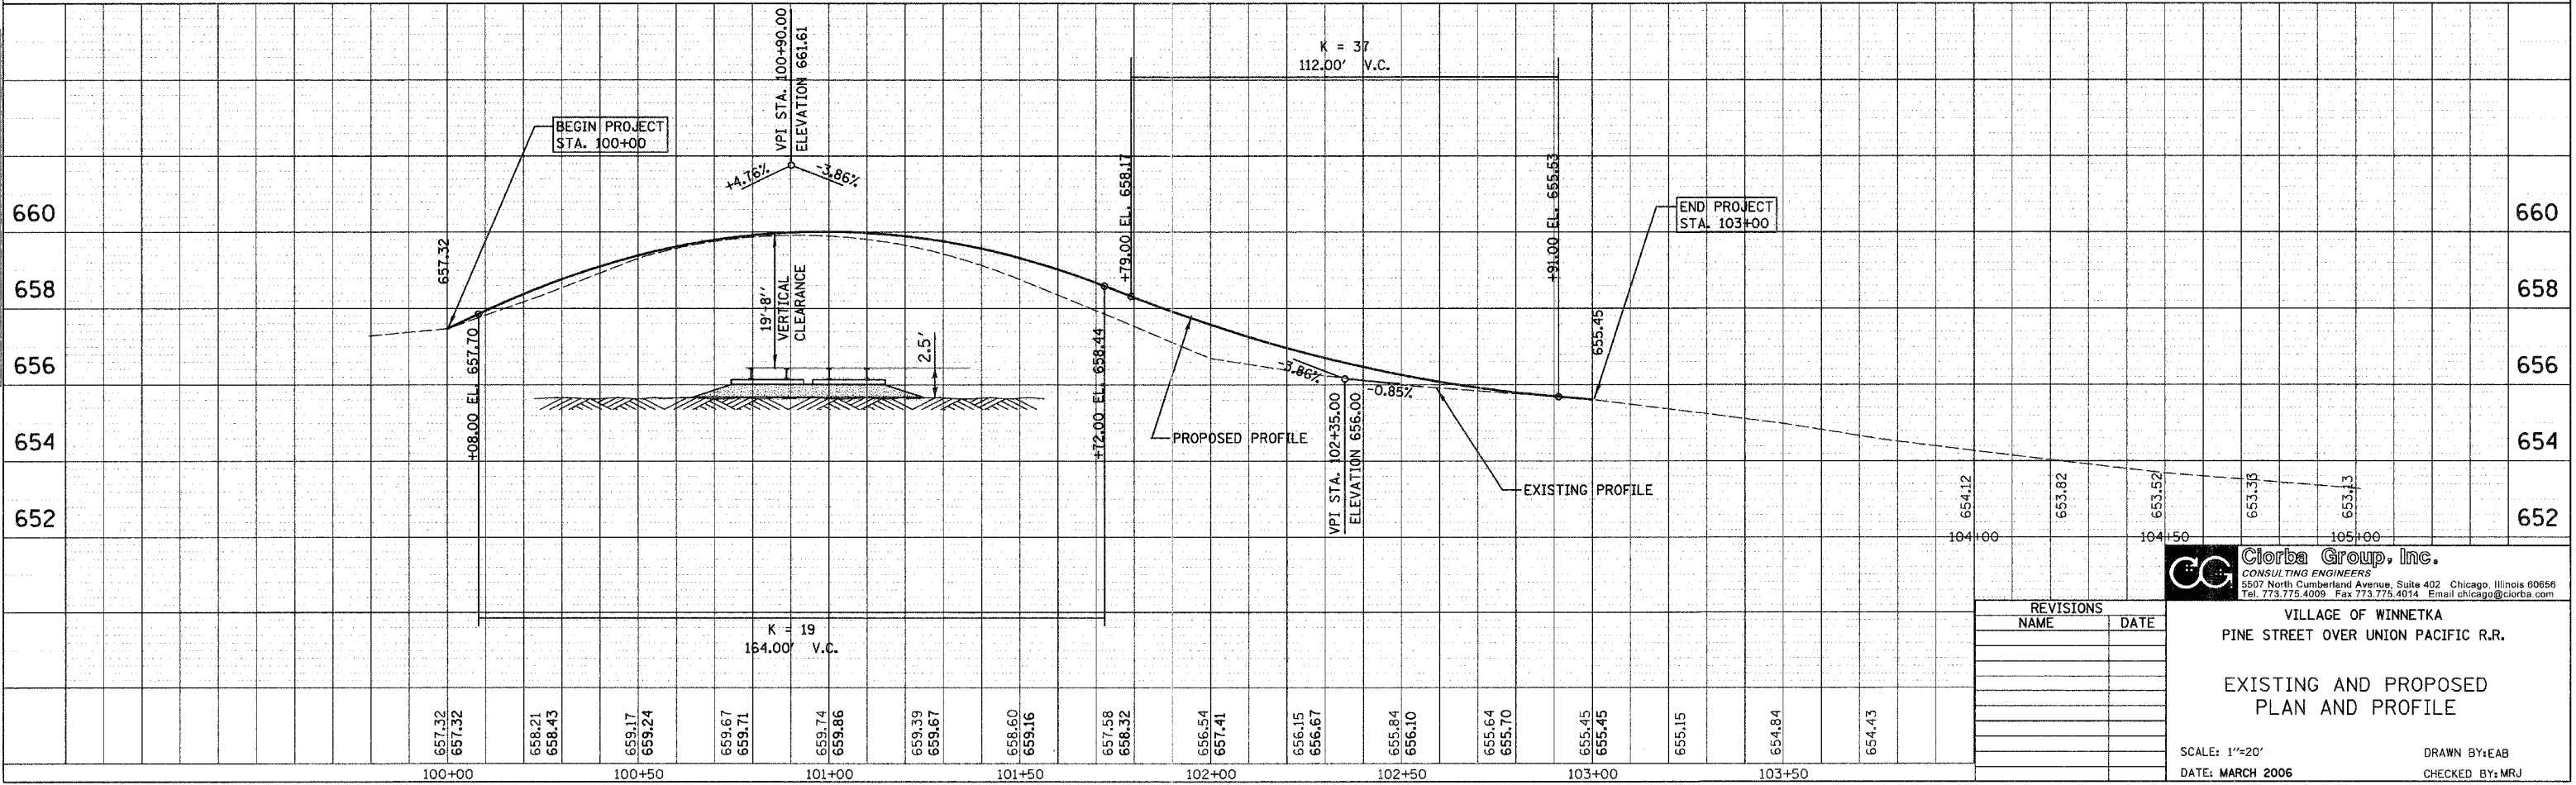

REVISIONS	
NAME	DATE

**CC** **Clorba Group, Inc.**  
CONSULTING ENGINEERS  
5507 North Cumberland Avenue, Suite 402 Chicago, Illinois 60656  
Tel. 773.775.4009 Fax 773.775.4014 Email chicago@clorba.com

VILLAGE OF WINNETKA  
PINE STREET OVER UNION PACIFIC R.R.

EXISTING AND PROPOSED  
PLAN AND PROFILE

SCALE: 1"=20'  
DATE: MARCH 2006

DRAWN BY: EAB  
CHECKED BY: MRJ