


F.A.S. RTE.	SECTION	COUNTY	TOTAL SHEETS	SHEET NO.
583	****	SCHUYLER	56	13
STA.		TO STA.		
FED. ROAD DIST. NO.		ILLINOIS FED. AID PROJECT **		

*** SECTION 02-00067-00-BR
** BRS-583(111)

SCALE IN FEET


LEGEND

- TYPE III BARRICADE
- TRAFFIC SIGNALS
- DRUM W/ STEADY BURNING LIGHT
- IMPACT ATTENUATORS (NON-REDIRECTIVE), TEST LEVEL 3
- DOUBLE VERTICAL PANEL
- TYPE C BIDIRECTIONAL REFLECTOR
- STEADY BURNING LIGHTS AND DOUBLE VERTICAL PANEL

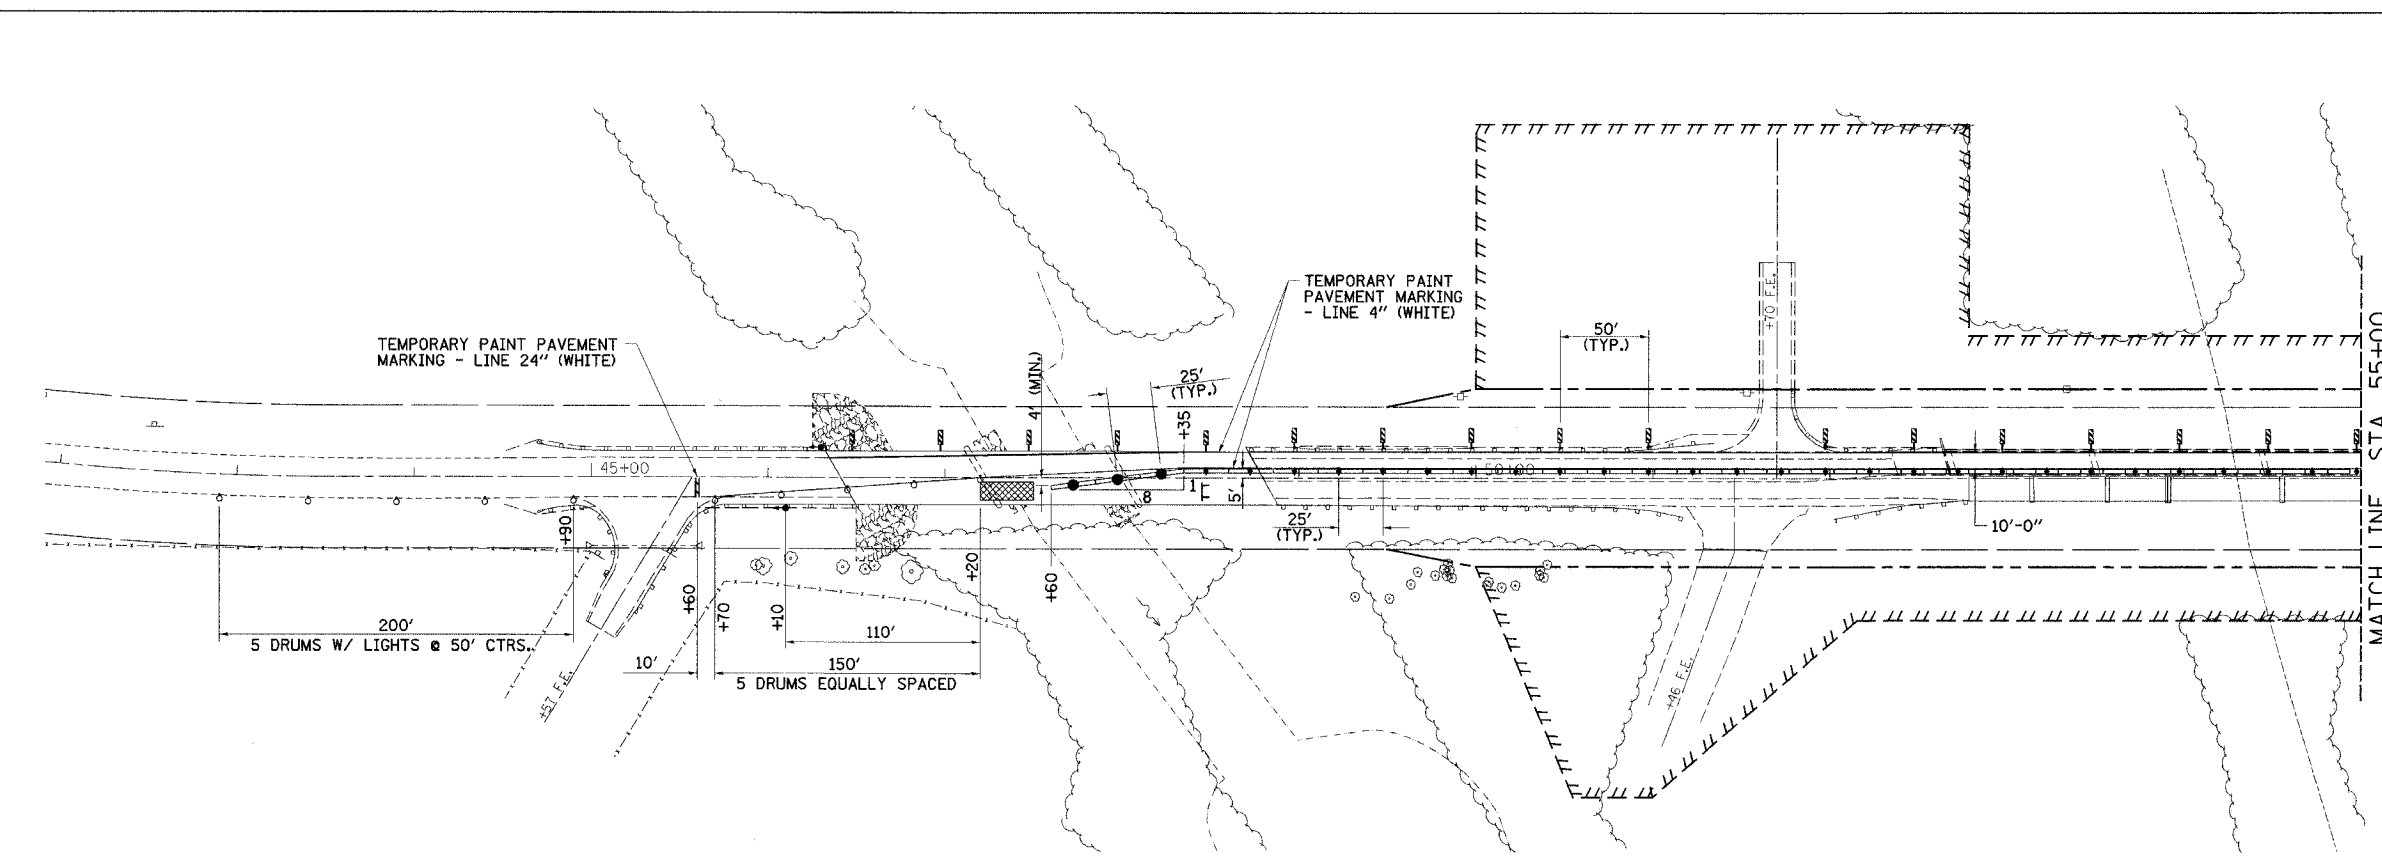

**STAGE 2
SEQUENCE OF OPERATIONS**

1. RELOCATE TEMPORARY CONCRETE BARRIERS, ATTENUATORS, DRUMS AND ALL OTHER ITEMS AS PER THESE DETAILS AND AS PER STANDARD 701321. BEGIN OPERATING UNDER STAGE 2 TRAFFIC CONDITIONS.
2. REMOVE SOUTH HALF OF EXISTING STRUCTURE, GUARDRAIL AND TRAFFIC BARRIER TERMINALS.
3. CONSTRUCT SOUTH HALF OF PROPOSED STRUCTURE, PLACE AND COMPACT ROADWAY FILL, AGGREGATE BASE COURSE, BITUMINOUS CONCRETE BINDER COURSE, BITUMINOUS SHOULDERS, AGGREGATE SHOULDERS, STEEL PLATE BEAM GUARD RAIL, AND TRAFFIC BARRIER TERMINALS.
4. REMOVAL TRAFFIC CONTROL DEVICES, PLACE BITUMINOUS CONCRETE SURFACE COURSE, PAVEMENT STRIPING, FINISH GRADING AND SEEDING. ALL WORK TO BE DONE IN ACCORDANCE WITH STANDARDS 701301, 701311, 701306 AND 702001.

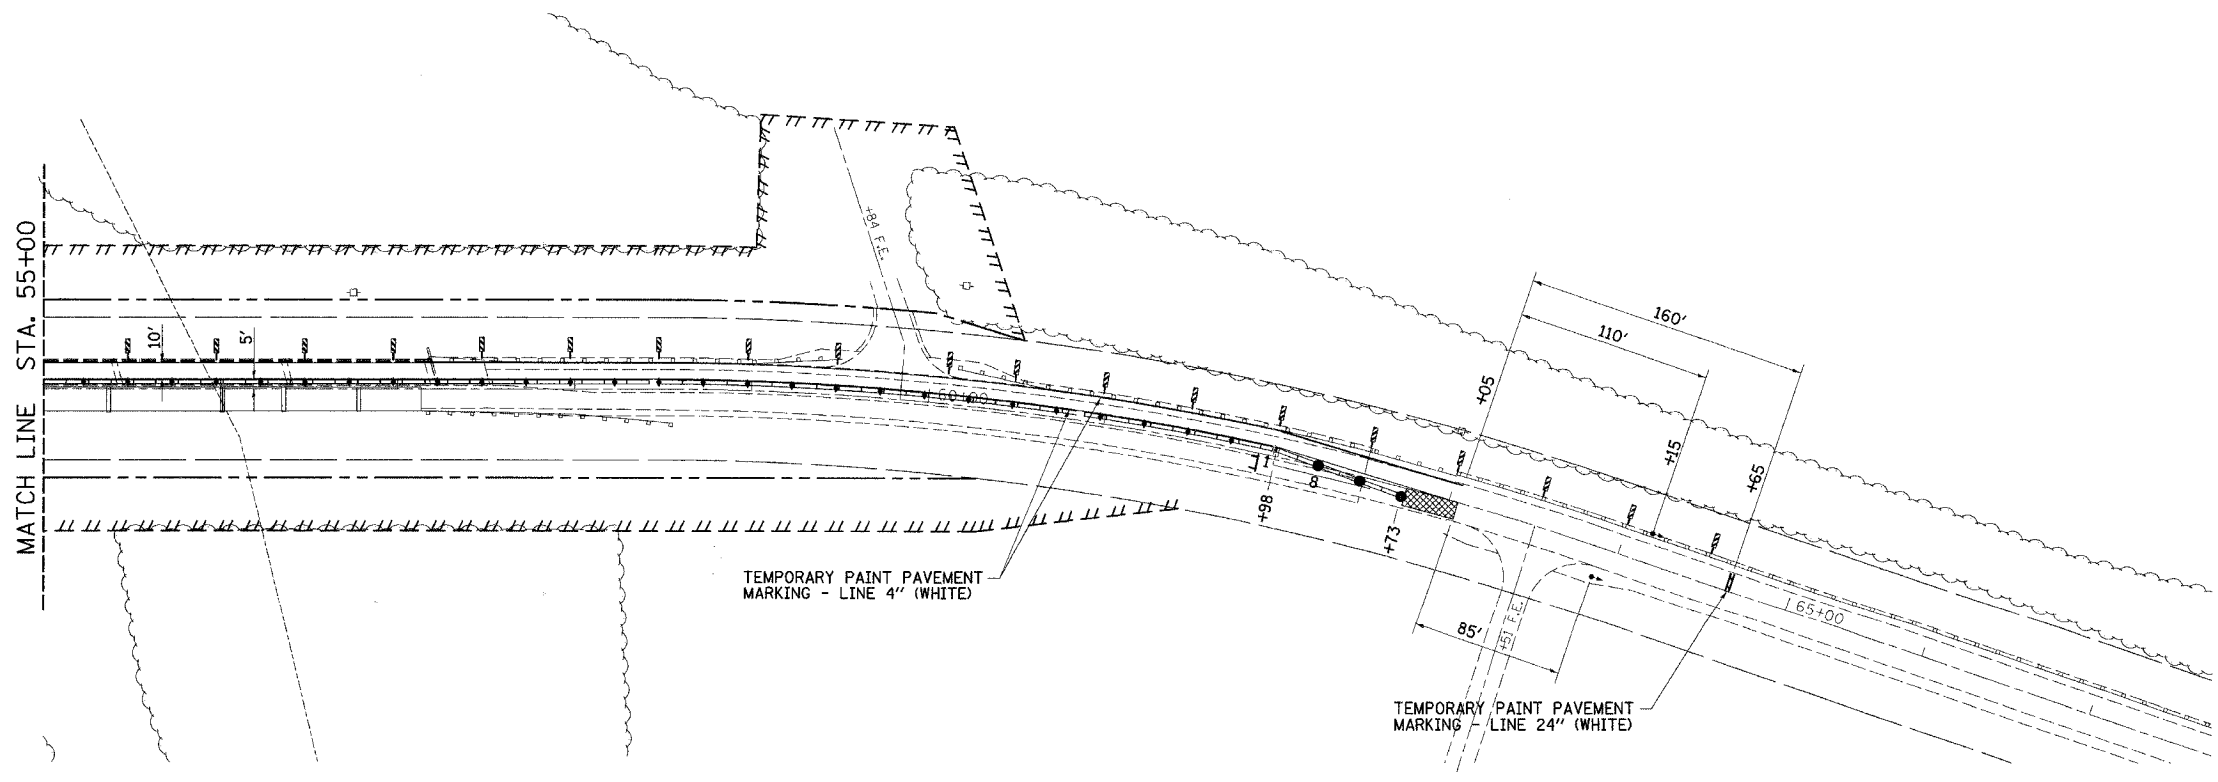

ILLINOIS DEPARTMENT OF TRANSPORTATION
**STAGE 2 CONSTRUCTION
TRAFFIC CONTROL**

FAS 583 (CHS) OVER LAMOINE RIVER
SECTION 02-00067-00-BR
SCHUYLER COUNTY

SCALE: VERT. _____ DRAWN BY SUTHEARD
DATE 5/9/06 CHECKED BY BOTT

	GREENE & BRADFORD, INC. OF SPRINGFIELD	COMPUTER FILE NO. 02157STG2
	CONSULTING ENGINEERS REGISTERED PROFESSIONAL ENGINEERS PROFESSIONAL SEAL NO. 061-00011 PROFESSIONAL SEAL NO. 061-00011 ILLINOIS PROFESSIONAL ENGINEERING BOARD	PROJECT 02157 5/11/06-MDS

REVISIONS	
NAME	DATE

PLOT DATE = #DATE#
FILE NAME = #FILE#
SCALE = #SCALE#
REFERENCE = #REF#
OPERATOR = #USER#