


F.A.I.	SECTION	COUNTY	TOTAL SHEETS	SHEET NO.
94/90	2003-028F	COOK	419	132
STA.	TO STA.			
FED. ROAD DIST. NO.	ILLINOIS	FED. AID PROJECT		
62580				

11/25/05 10:54:40 AM

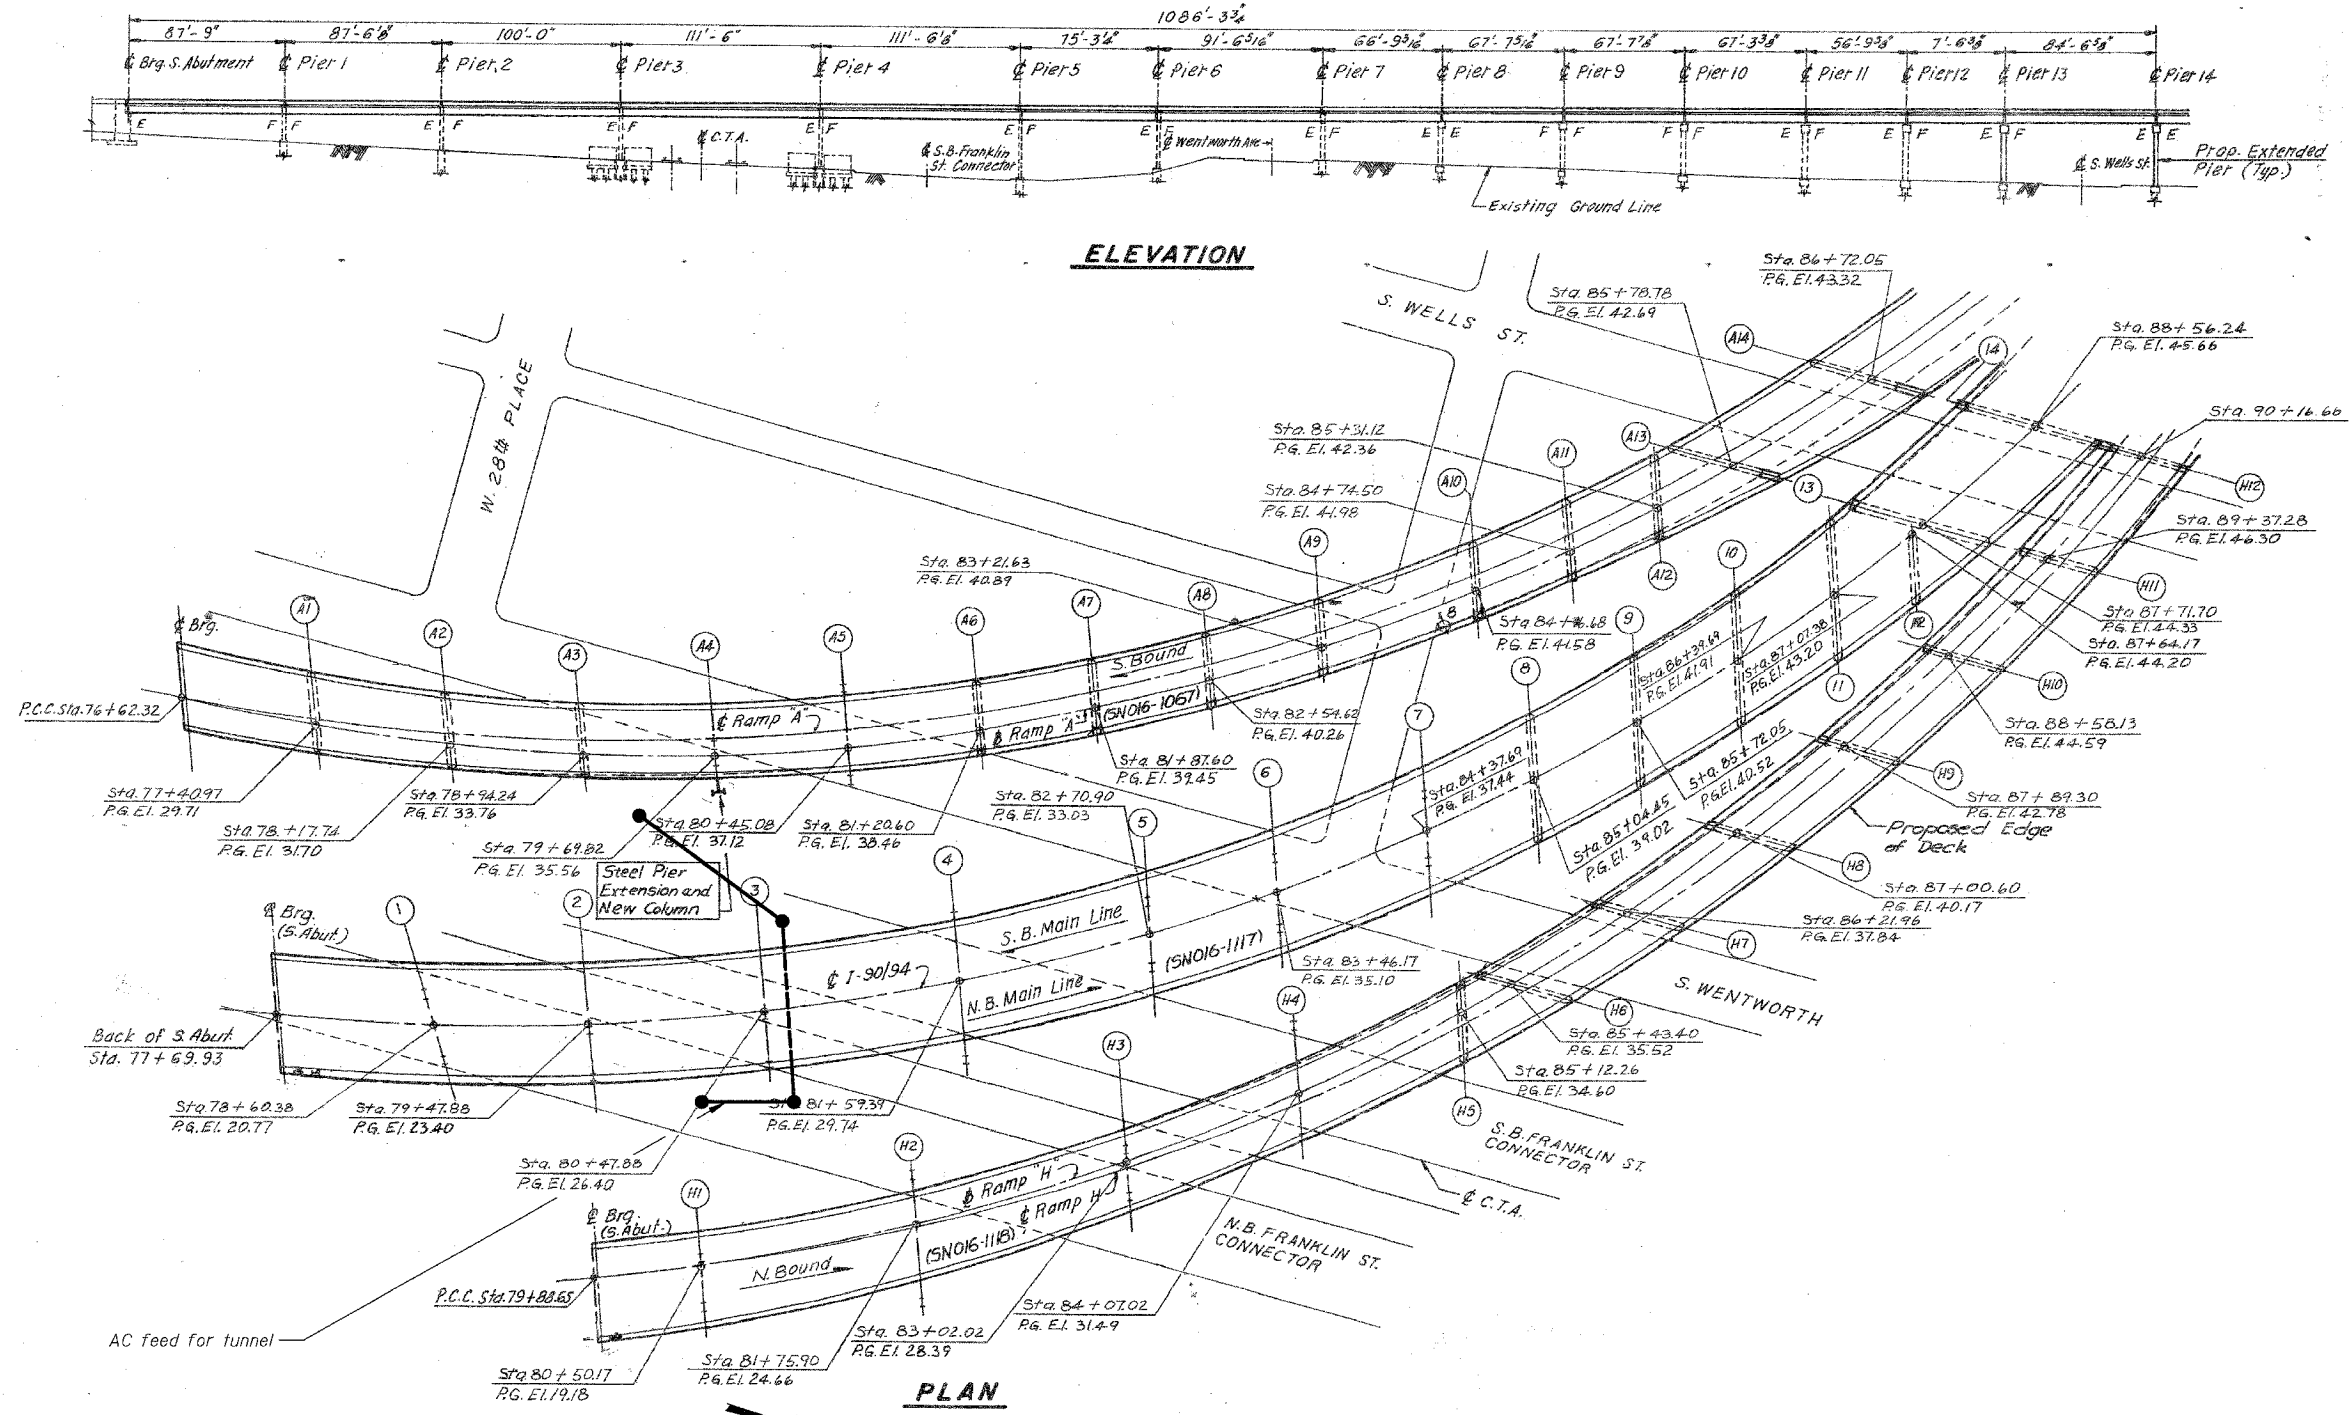

**Notes:**

This sheet created from original 1988-89 reconstruction as-builts. These are provided for general reference to structure number, span lengths, etc. Work Items for this contract are identified on the partial deck plans, framing plans and detail sheets that follow.

The Indicated Locations for the Detector Loops are approximate. The Contractor shall verify the exact locations and shall reference to Traffic System Drawings and Specifications for the work required for these Detector Loops.

An AC feed for the CTA's tunnel is shown above. The Contractor shall take all necessary safety precautions and exercise extra care not to damage the AC feed. The Contractor shall coordinate his work for the safety precautions according to CTA's regulations.

**BOWMAN, BARRETT & ASSOCIATES INC.**  
 CONSULTING ENGINEERS  
 Chicago, Illinois  
 312.228.0100  
 www.bbainc.com

**LEGEND**  
 □ Detector Loop

REVISIONS	
NAME	DATE

ILLINOIS DEPARTMENT OF TRANSPORTATION  
 F.A.I. 94/90 (DAN RYAN EXPRESSWAY)  
 NB DAN RYAN ELEVATED BRIDGE  
 REPAIR FROM 15TH TO 28TH STREETS  
 GENERAL PLAN AND ELEVATION  
 SN 016-1117, SN 016-1118

SCALE: NTS  
 DATE: 8/12/2005

DRAWN BY: BDC  
 CHECKED BY: BLU