


F.A.P. RTE.	SECTION	COUNTY	TOTAL SHEETS	SHEET NO.
649	(107)I-2	LIVINGSTON	7	4

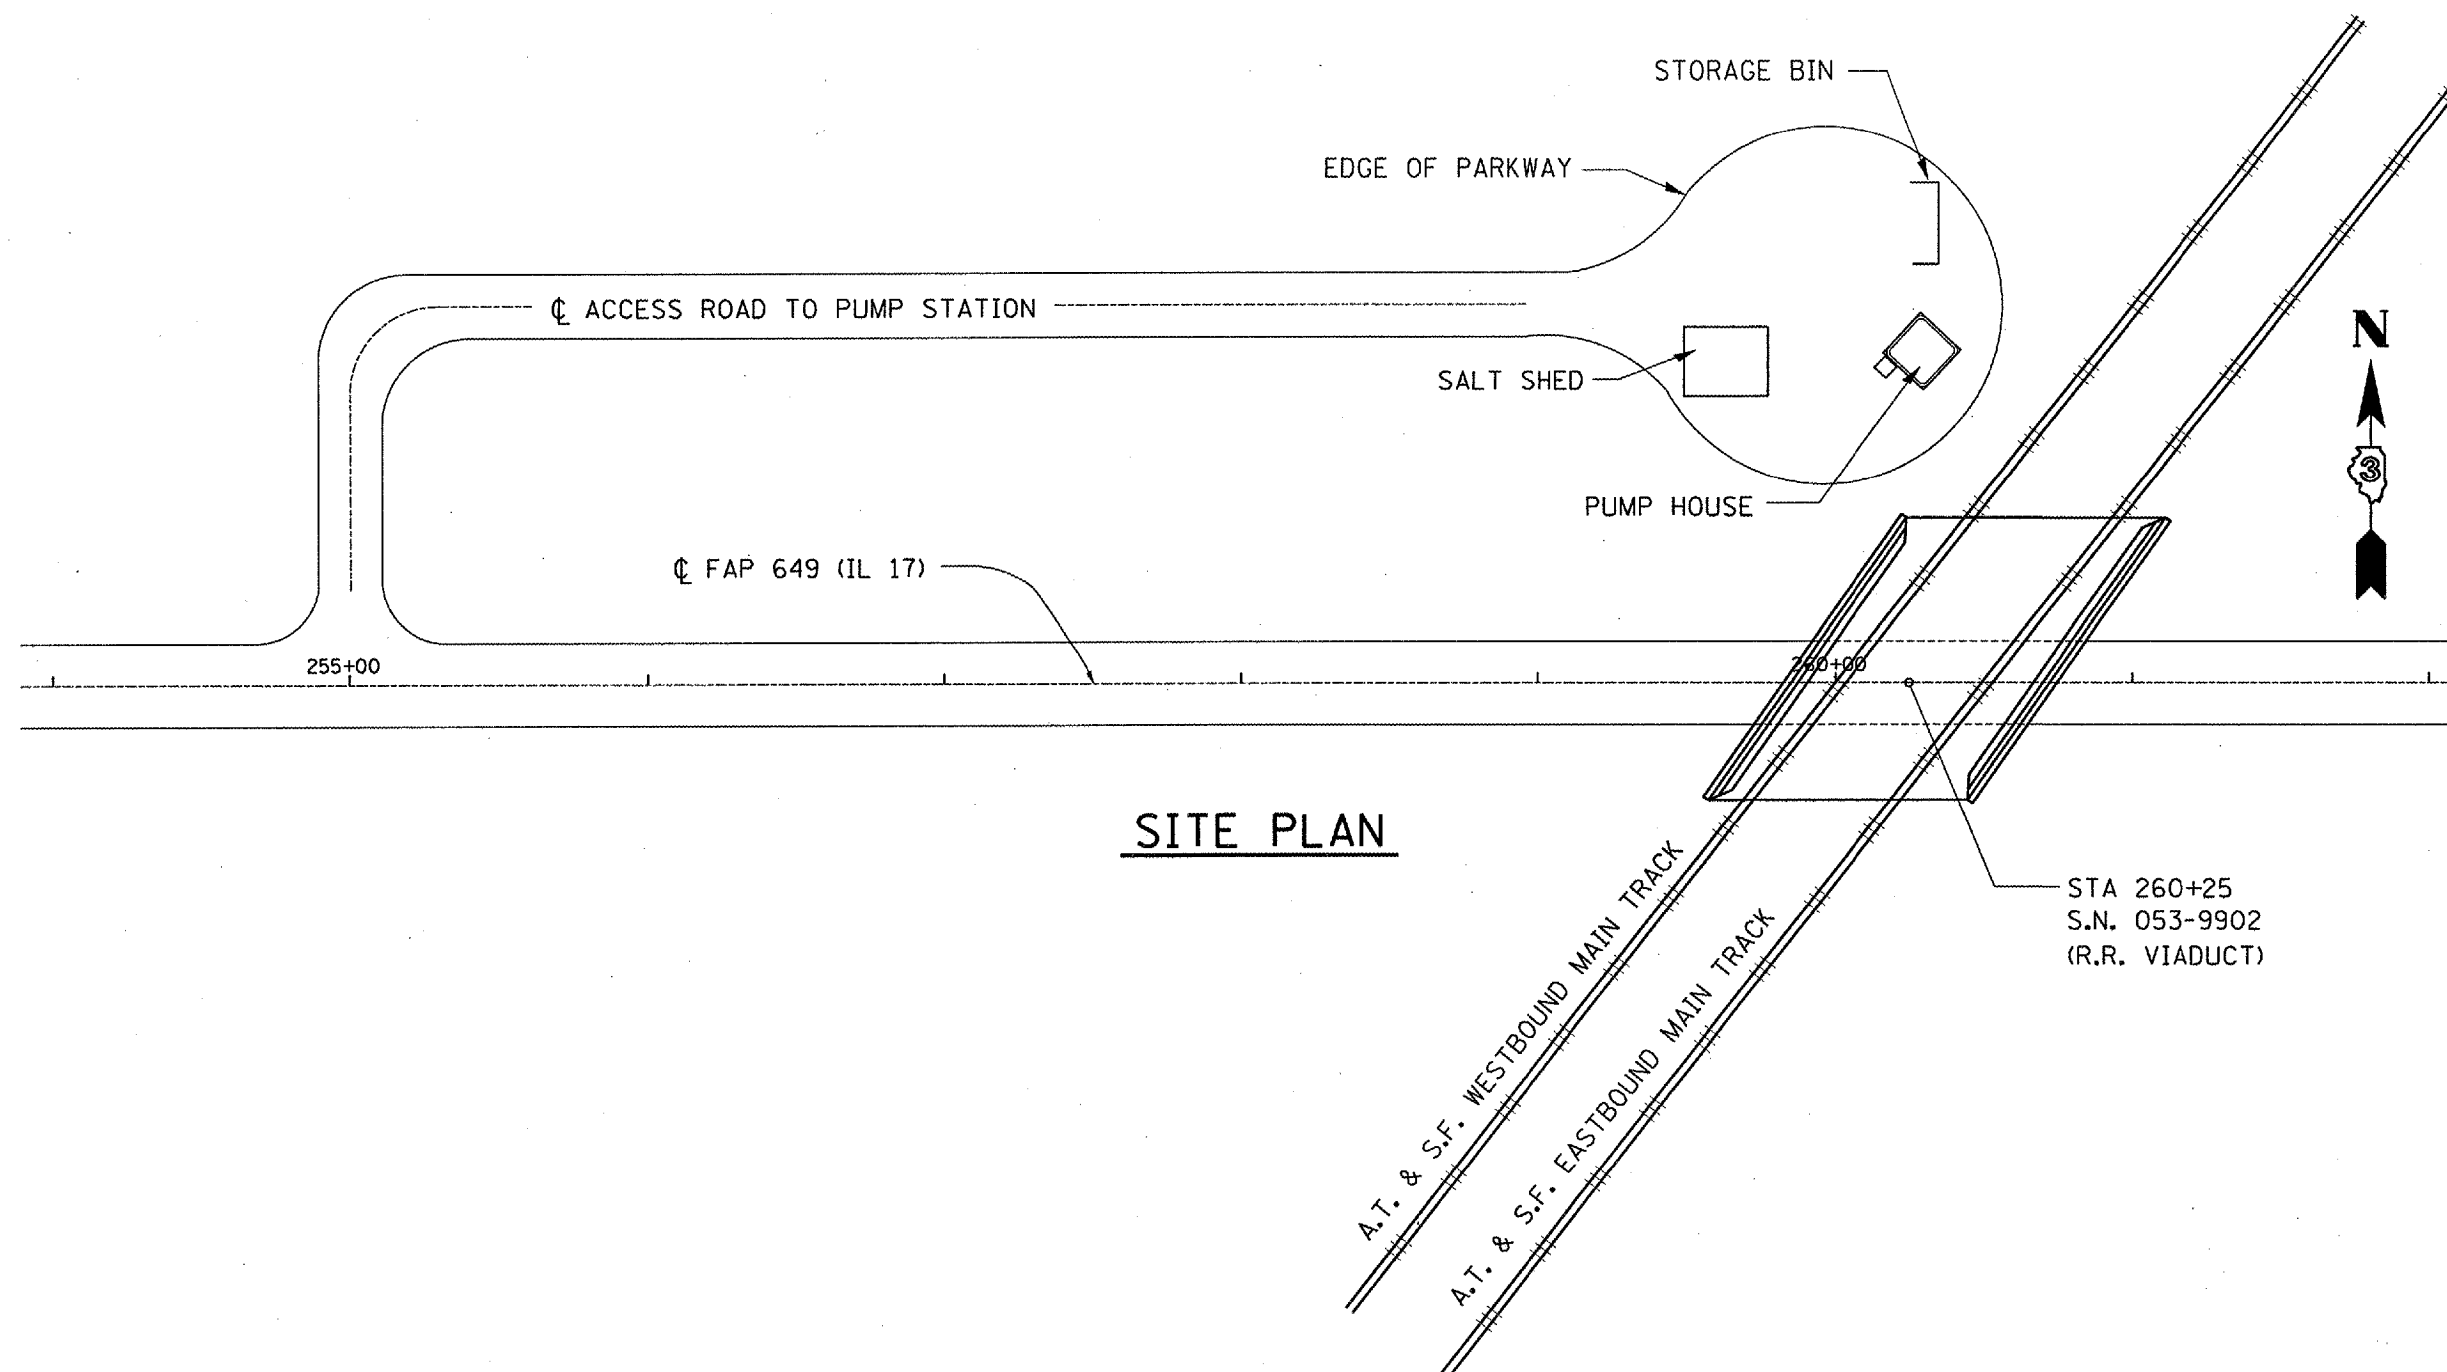

SITE PLAN

DATE: JULY 29, 2005  
 FILE: c:/projects/cmain06/cm319/details.dgn

REVISIONS	
NAME	DATE

ILLINOIS DEPARTMENT OF TRANSPORTATION  
**GENERAL SITE PLAN**  
 READING PUMPING STATION  
 FAP 649  
 SECTION (107)I-2  
 LIVINGSTON COUNTY  
 SCALE: VERT. \_\_\_\_\_  
 HORIZ. \_\_\_\_\_  
 DATE: 08/12/2005  
 DRAWN BY: RW  
 CHECKED BY: \_\_\_\_\_