
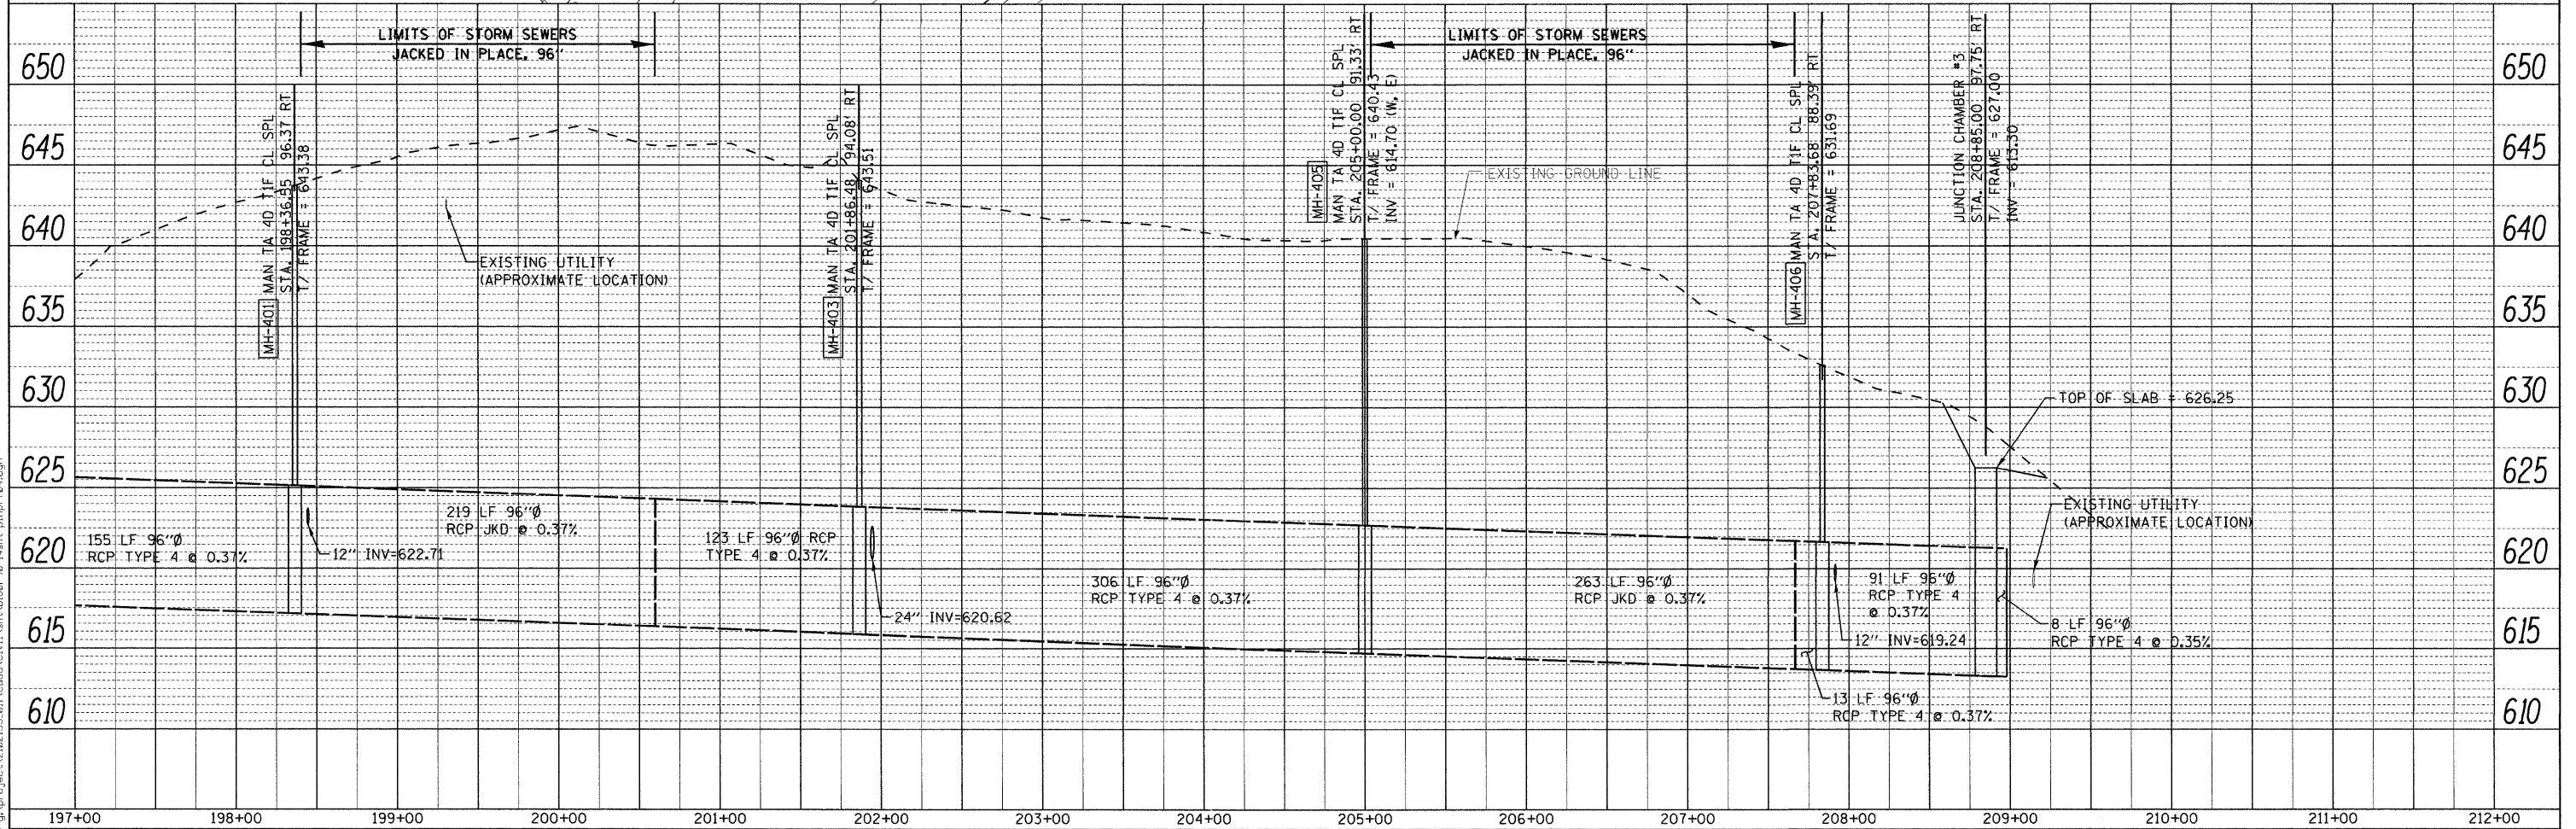


DATE	
BY	
REVISIONS	
NO.	
DESCRIPTION	
DATE	
BY	
NO.	
DESCRIPTION	
DATE	
BY	
NO.	
DESCRIPTION	
DATE	
BY	
NO.	
DESCRIPTION	

DATE	
BY	
REVISIONS	
NO.	
DESCRIPTION	
DATE	
BY	
NO.	
DESCRIPTION	
DATE	
BY	
NO.	
DESCRIPTION	

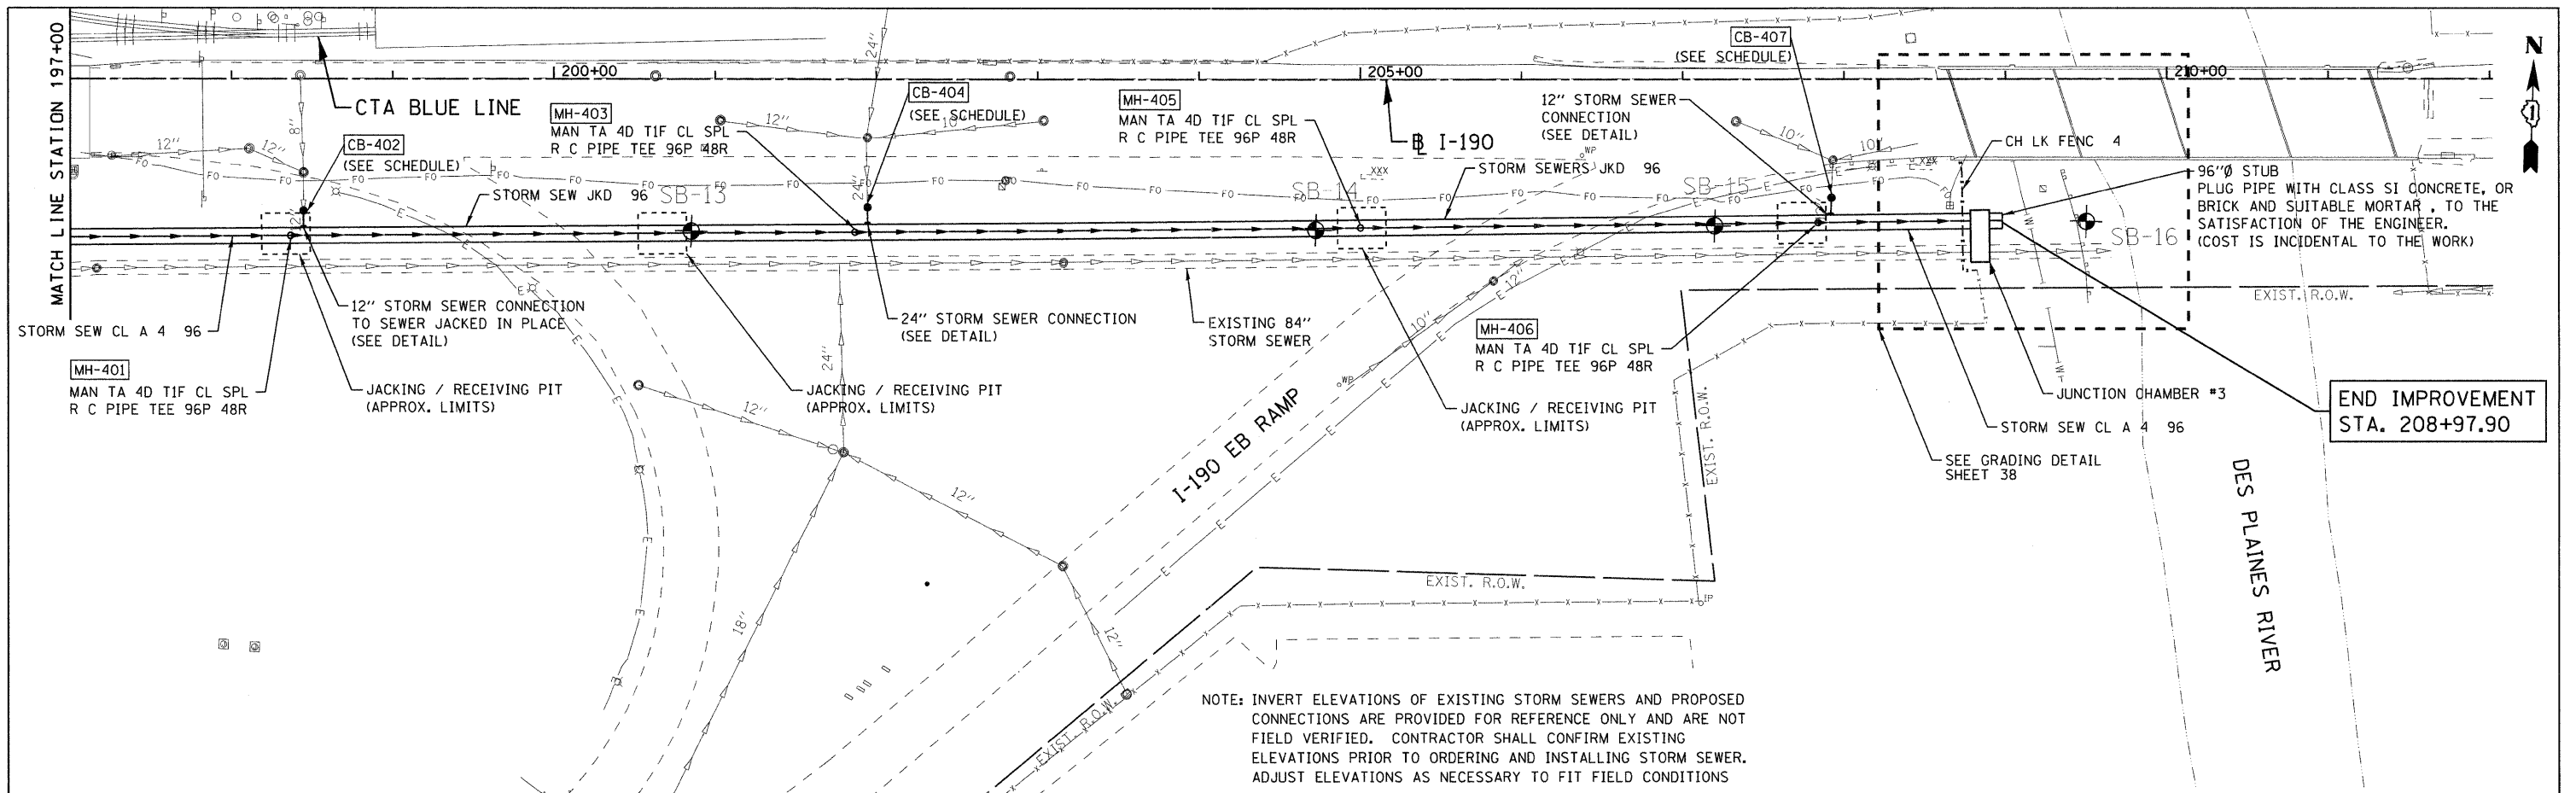

	USER NAME = 2bookd	DESIGNED - DJB	REVISED -	<b>STATE OF ILLINOIS</b> <b>DEPARTMENT OF TRANSPORTATION</b>	<b>PUMP STATION 24 STORM SEWER IMPROVEMENT</b> <b>STORM SEWER PLAN AND PROFILE</b>	F.A.T. RTE. 190	SECTION 0102.5-T	COUNTY COOK	TOTAL SHEETS 41	SHEET NO. 15
	PLOT SCALE = 50.00 ft / IN.	CHECKED - DAK	REVISED -			SCALE: 50.00 ft / IN. SHEET NO. OF SHEETS STA. TO STA.	CONTRACT NO. 60F90			ILLINOIS FED. AID PROJECT
	PLOT DATE = 10/11/2011	DATE - 09/07/11	REVISED -							