
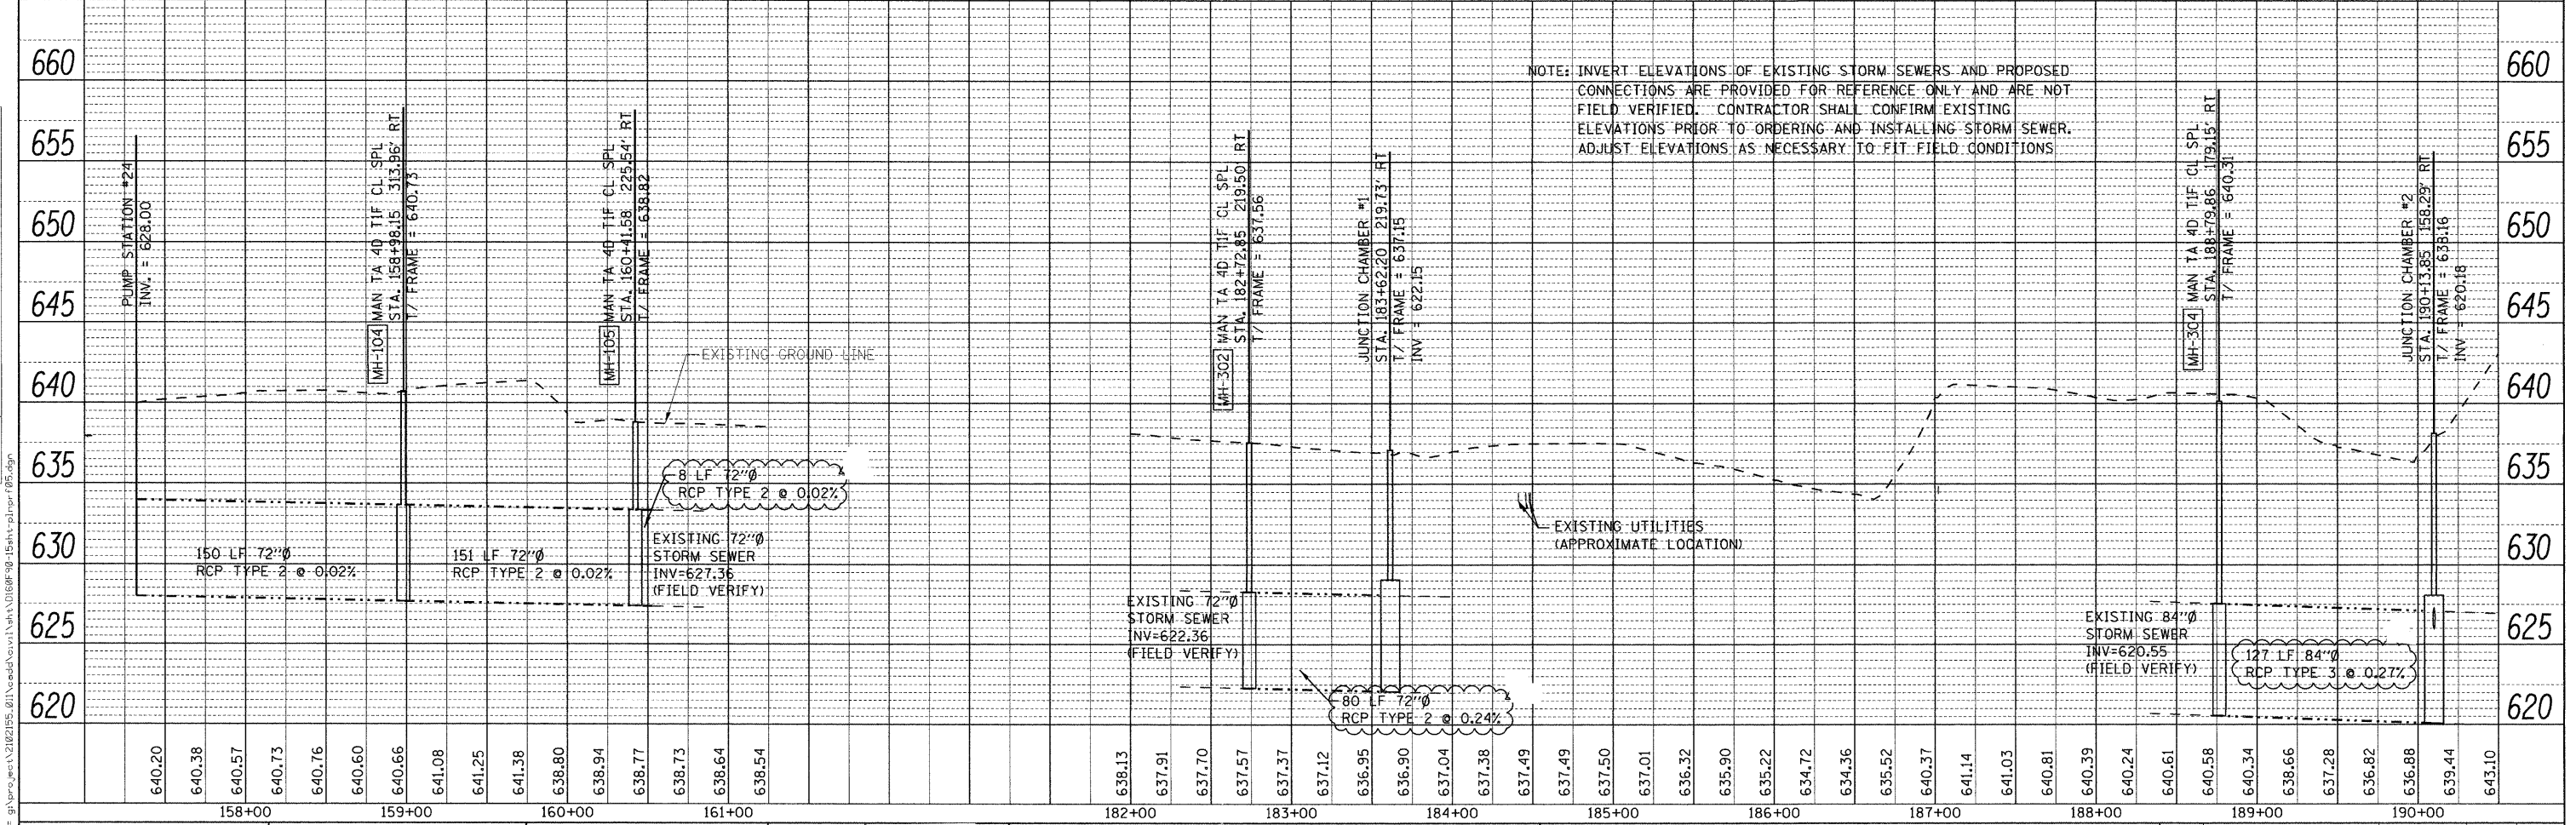
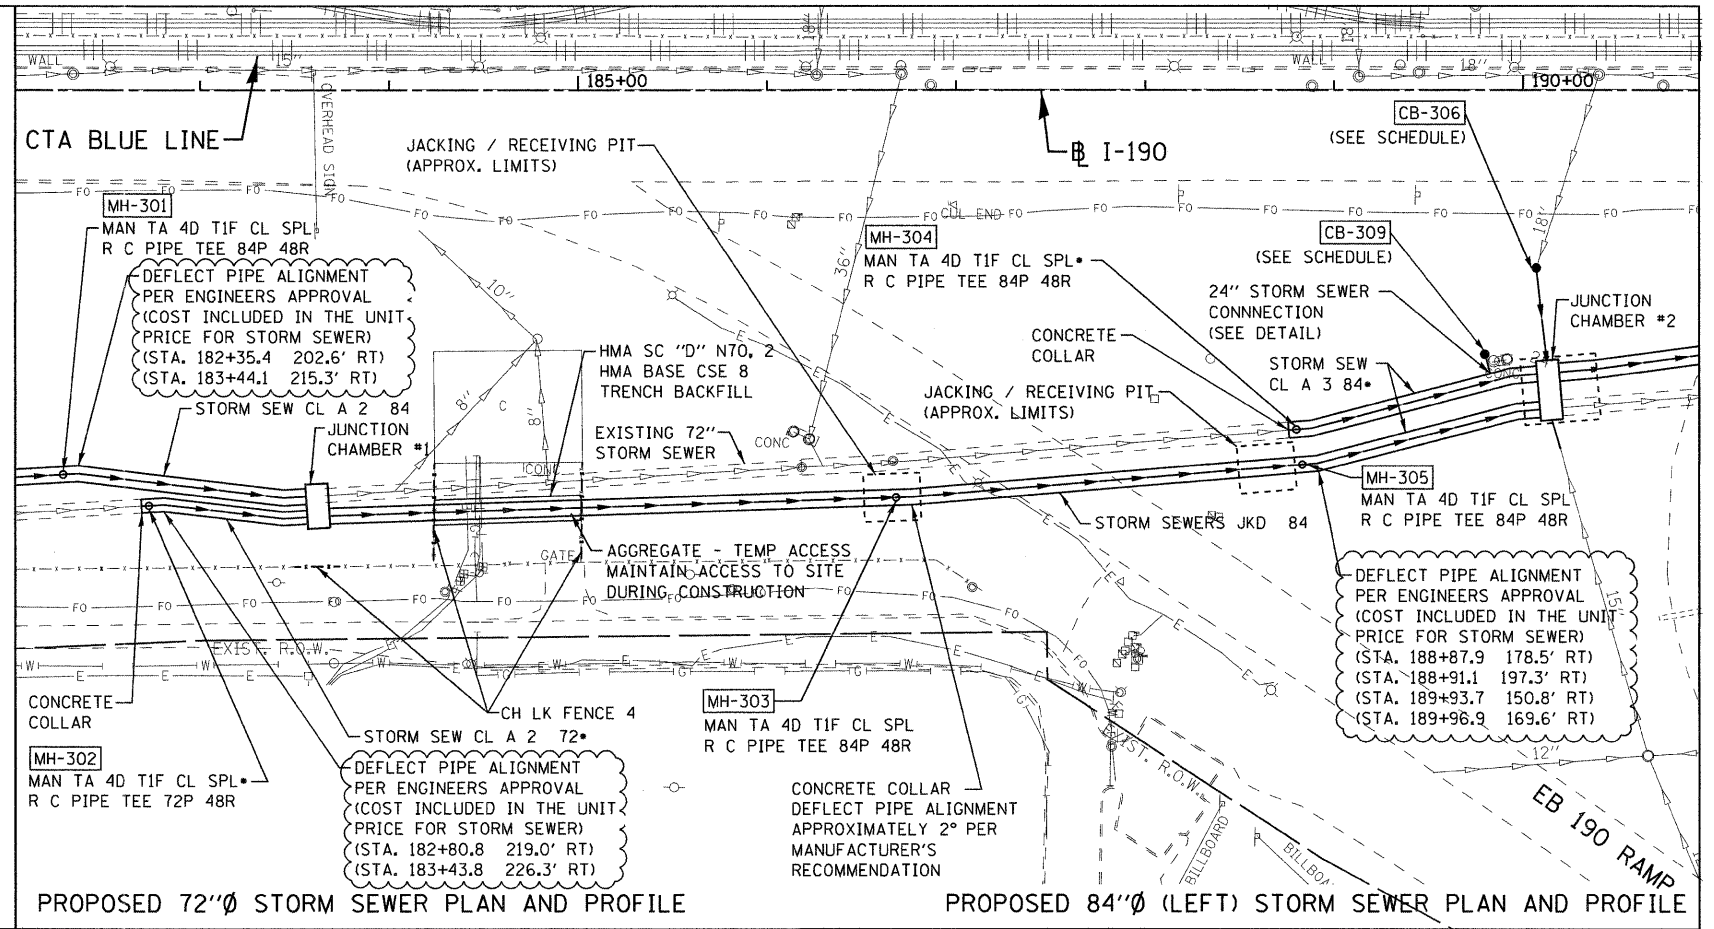


DATE	
BY	
PLAN	
NO.	
NO.	
NO.	
NO.	
NO.	
NO.	

DATE	
BY	
PROFILE	
NO.	
NO.	
NO.	
NO.	
NO.	
NO.	

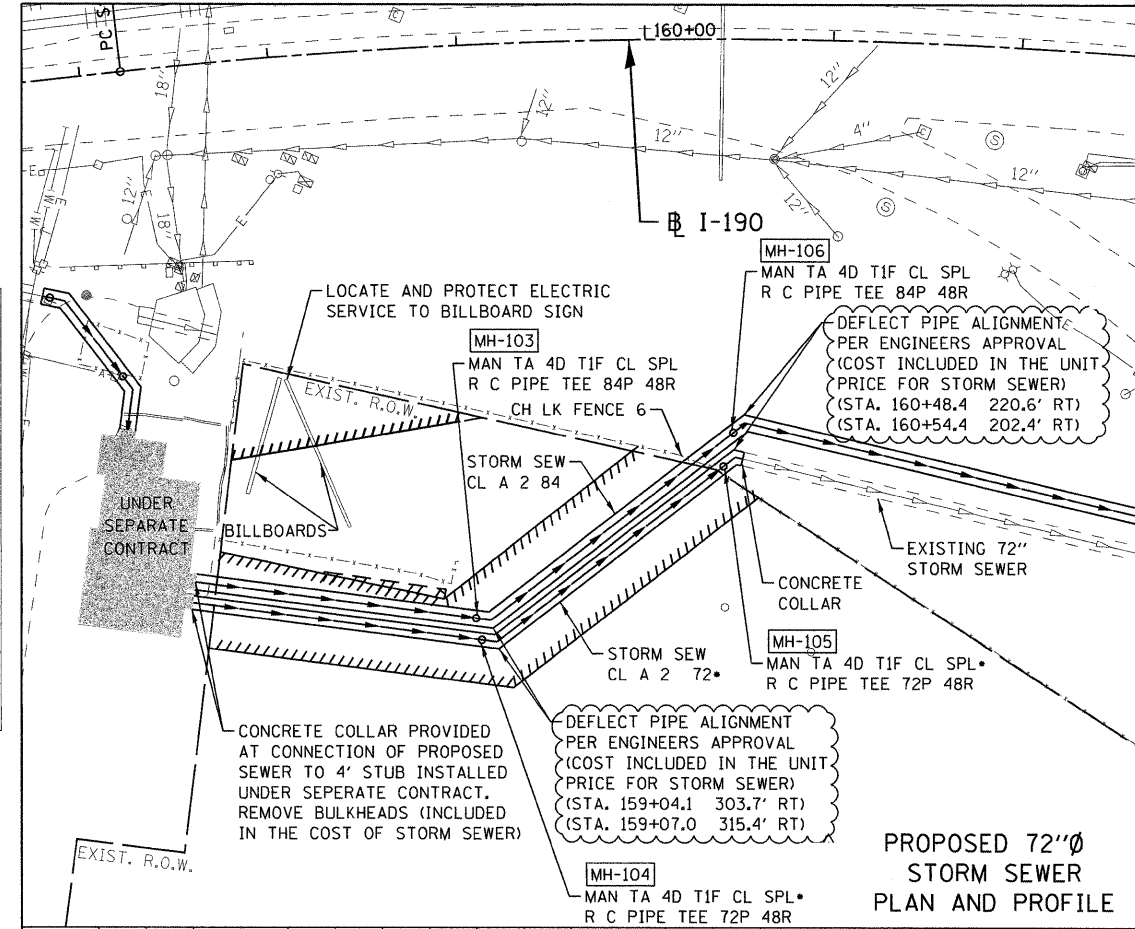

USER NAME = 2bookd	DESIGNED - DJB	REVISED -
FILE SCALE = 50.00 ft / IN.	DRAWN - ENTRAN	REVISED -
PLOT DATE = 10/25/2011	CHECKED - DAK	REVISED -
	DATE - 09/07/11	REVISED -

STATE OF ILLINOIS	DEPARTMENT OF TRANSPORTATION
-------------------	------------------------------

PUMP STATION 24 STORM SEWER IMPROVEMENT			
STORM SEWER PLAN AND PROFILE DETAIL			
SCALE: 50.00 ft / IN.	SHEET NO.	OF SHEETS	STA. TO STA.

F.A.I. RTE. 190	SECTION 0102.5-T	COUNTY COOK	TOTAL SHEETS 41	SHEET NO. 16
FED. ROAD DIST. NO. 1		ILLINOIS FED. AID PROJECT		
CONTRACT NO. 60F90				