


LEGEND OF SYMBOLS	
	EXISTING CONTROL CENTER
	EXISTING LIGHT POLE AND FIXTURE TO BE REMOVED
	PROPOSED 30' MOUNTING HEIGHT POLE WITH 8' MAST ARM AND 150 WATT HIGH PRESSURE SODIUM LAMP
	PROPOSED UNIT DUCT WITH 3-1/2 No. 6 & 1-1/2 No. 8 GROUND, 600V (XLP-TYPE USE), 1" DIAMETER, BORED & PULLED OR AS NOTED
	PROPOSED RIGID GALVANIZED STEEL CONDUIT IN TRENCH OR PUSHED AS NOTED
	CONTROLLER IDENTIFICATION (TYP.)
	CIRCUIT NUMBER (TYP.)
	POLE NUMBER (TYP.)
	SET BACK FROM BACK OF CURB (TYP.)
	STATION NUMBER (TYP.)

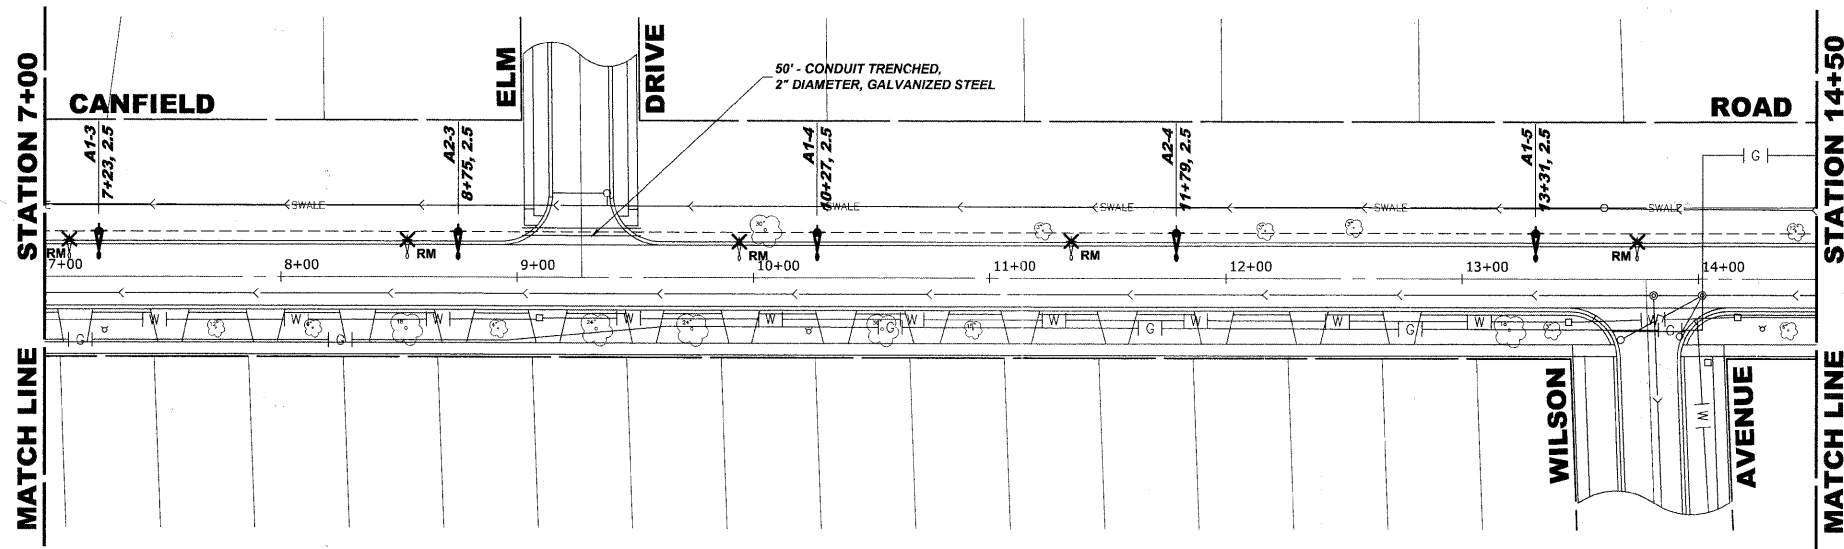

Drawing file: W:\Projects\61210209 - Canfield Road Recon\91_Canfield 40scale.dwg Aug 11, 2011 - 2:12pm

HANCOCK ENGINEERING

- Civil Engineers
- Municipal Consultants
- Established 1911

9933 Roosevelt Road
 Wheaton, Illinois 60154-2790
 Phone: 708/865-8390
 Fax: 708/865-1212

DESIGNED -	CB	REVISED -	
DRAWN -	LEV, DMM	REVISED -	
CHECKED -	JGG	REVISED -	
DATE -	7-1-2011	REVISED -	

**STATE OF ILLINOIS
 DEPARTMENT OF TRANSPORTATION**

STREET LIGHTING PLAN

SCALE: 1" = 40' SHEET NO. 1 OF 2 SHEETS STA. 0+71 TO STA. 14+50

F.A.U. RTE.	SECTION	COUNTY	TOTAL SHEETS	SHEET NO.
2763	10-00061-00-RS	COOK	41	27
FIELD BOOK NO. 1552		CONTRACT NO. 63631		
FED. ROAD DIST. NO. 1	ILLINOIS	FED. AID PROJECT		

E.H.E. PROJECT NO. 612-10-20901