



DATE	
BY	
PLAN	
SURVEYED	
PLOTTED	
NOTE BOOK	
NO.	
FILE NAME	

DATE	
BY	
PROFILE	
SURVEYED	
GRADES CHECKED	
NOTE BOOK	
NO.	
FILE NAME	

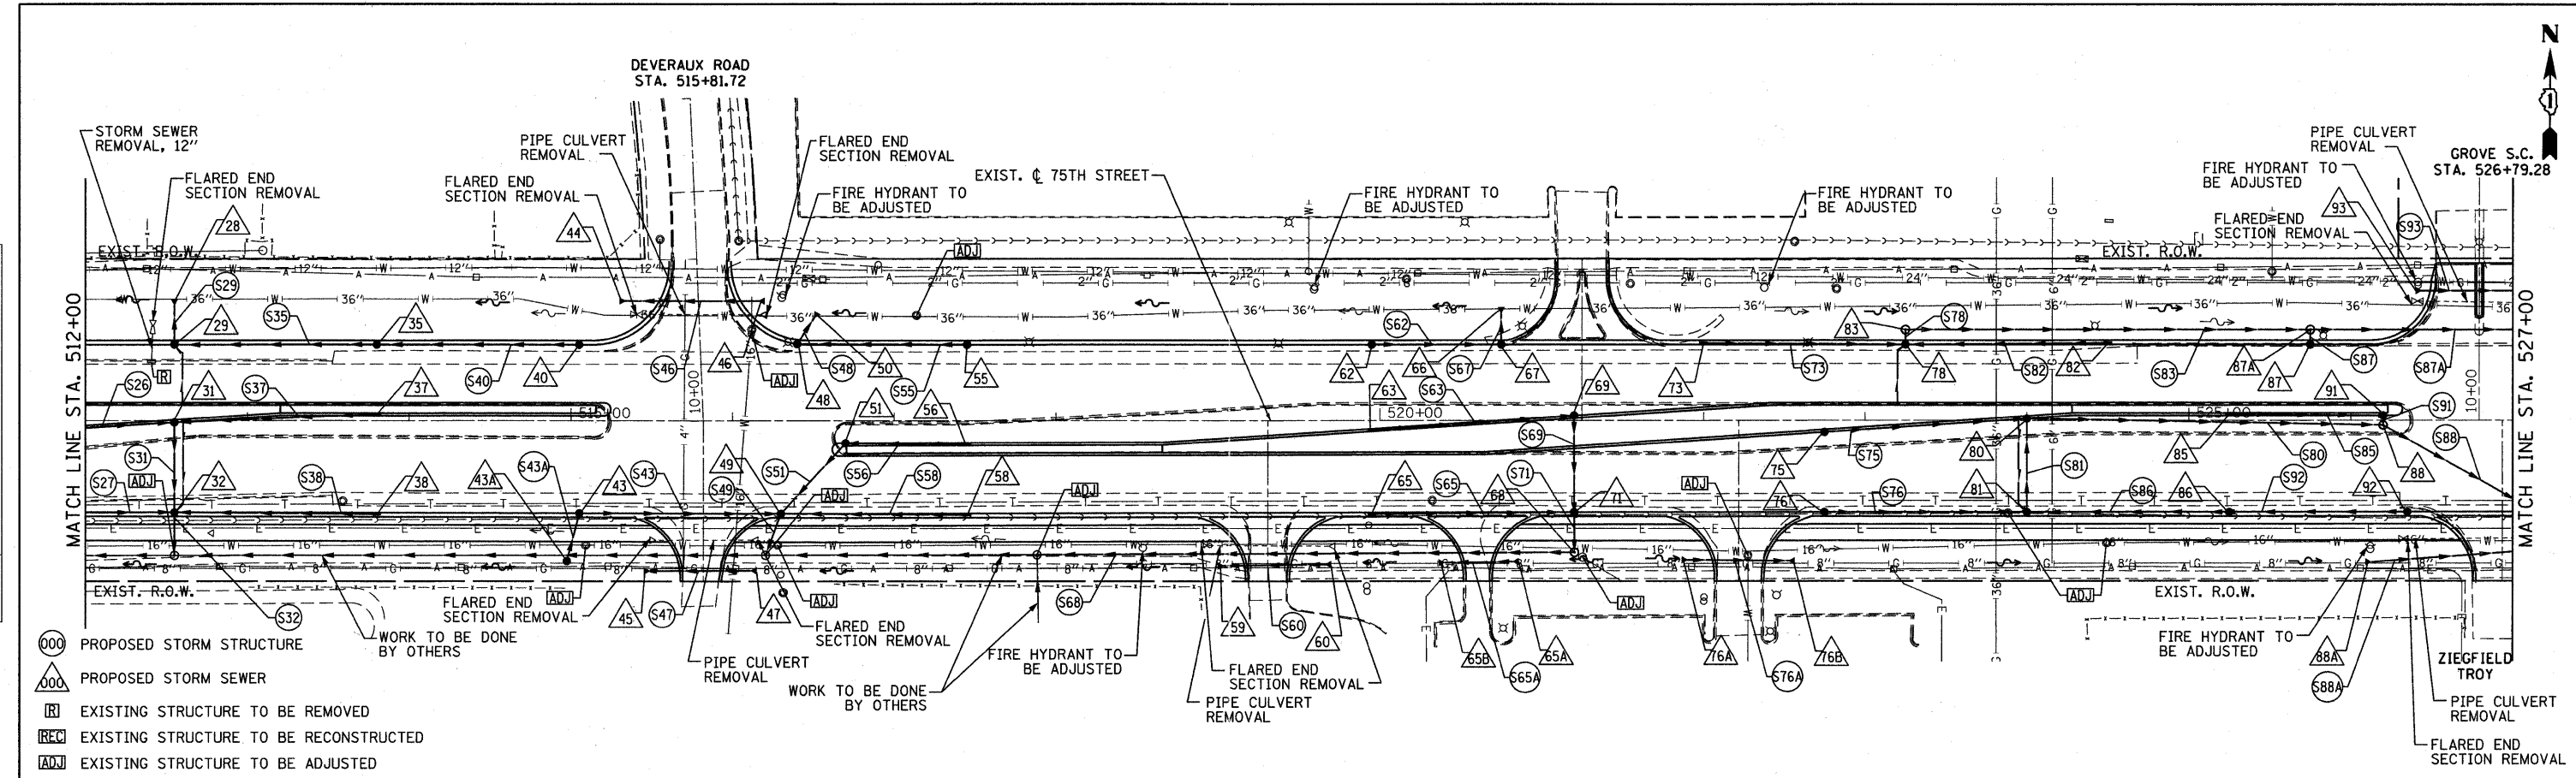

- ⊙ PROPOSED STORM STRUCTURE
- △ PROPOSED STORM SEWER
- ⊠ EXISTING STRUCTURE TO BE REMOVED
- ⊡ EXISTING STRUCTURE TO BE RECONSTRUCTED
- ⊞ EXISTING STRUCTURE TO BE ADJUSTED

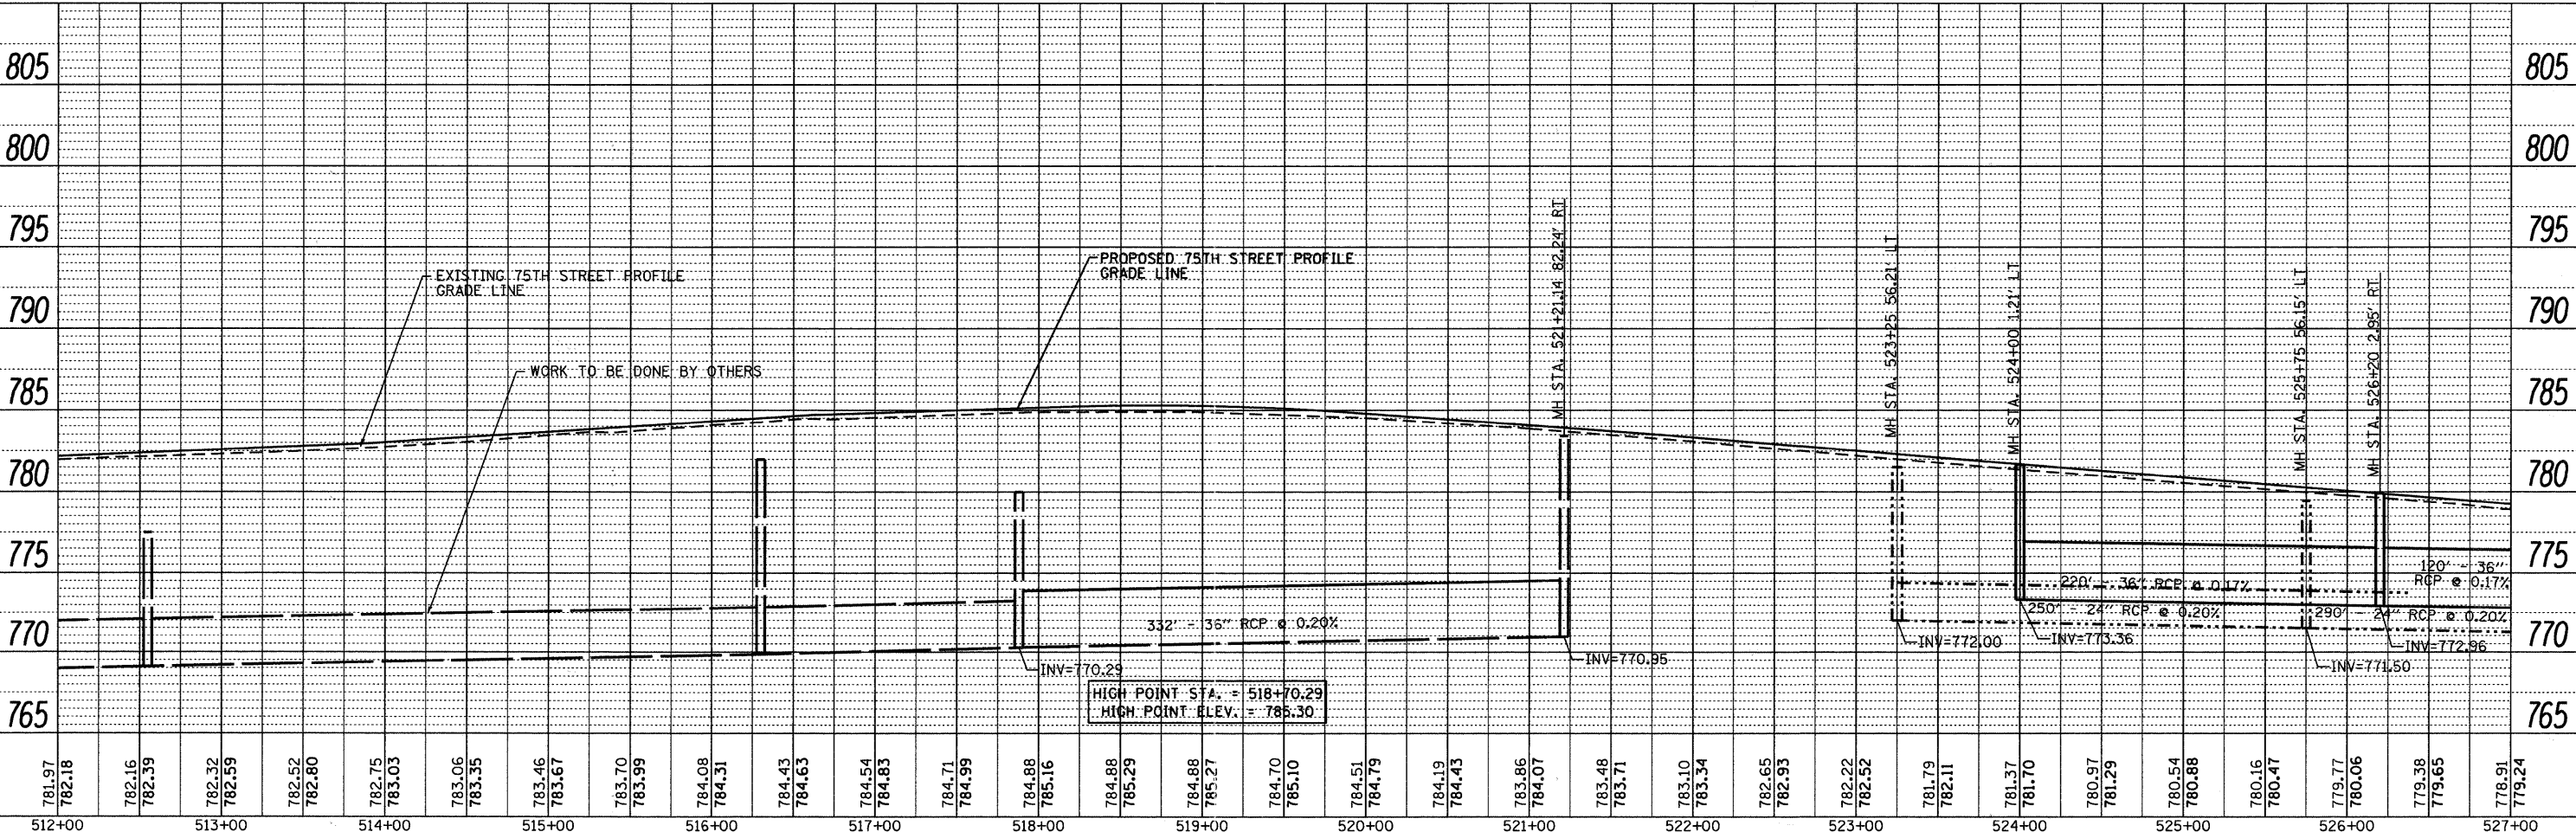

FILE NAME = c:\p1\030\_75th st.dwg; do:\engr\engr\dr\avg\451\030\75th-st-dwg.dwg

**B** Bollinger, Lach & Associates, Inc.  
ITASCA, ILLINOIS

USER NAME = gollwanger  
DESIGNED - GJE  
DRAWN - DC  
CHECKED - JP  
DATE - 09/08/11

REVISED -  
REVISED -  
REVISED -  
REVISED -

**STATE OF ILLINOIS  
DEPARTMENT OF TRANSPORTATION**

**DRAINAGE AND UTILITY PLAN  
75TH STREET**  
VERT. 1"=5'  
SCALE: HORZ. 1"=50' SHEET NO. 82 OF 198 SHEETS STA. 512+00 TO STA. 522+00

F.A.P. RTE.	SECTION	COUNTY	TOTAL SHEETS	SHEET NO.
	07-00232-04-WR	DuPAGE	198	82
CONTRACT NO. 63632			ILLINOIS FED. AID PROJECT	