



BURIED CABLE BETWEEN INTELLIGENT TRANSPORTATION SYSTEMS HANDHOLES ARE NOT SHOWN.

DATE	
BY	
PLAN	
SURVEYED	
PLOTTED	
GRADES CHECKED	
STRUCTURE NOTATIONS CHECKED	
NOTE BOOK NO.	
FILE NAME	


DATE	
BY	
PROFILE	
SURVEYED	
PLOTTED	
GRADES CHECKED	
STRUCTURE NOTATIONS CHECKED	
NOTE BOOK NO.	
FILE NAME	

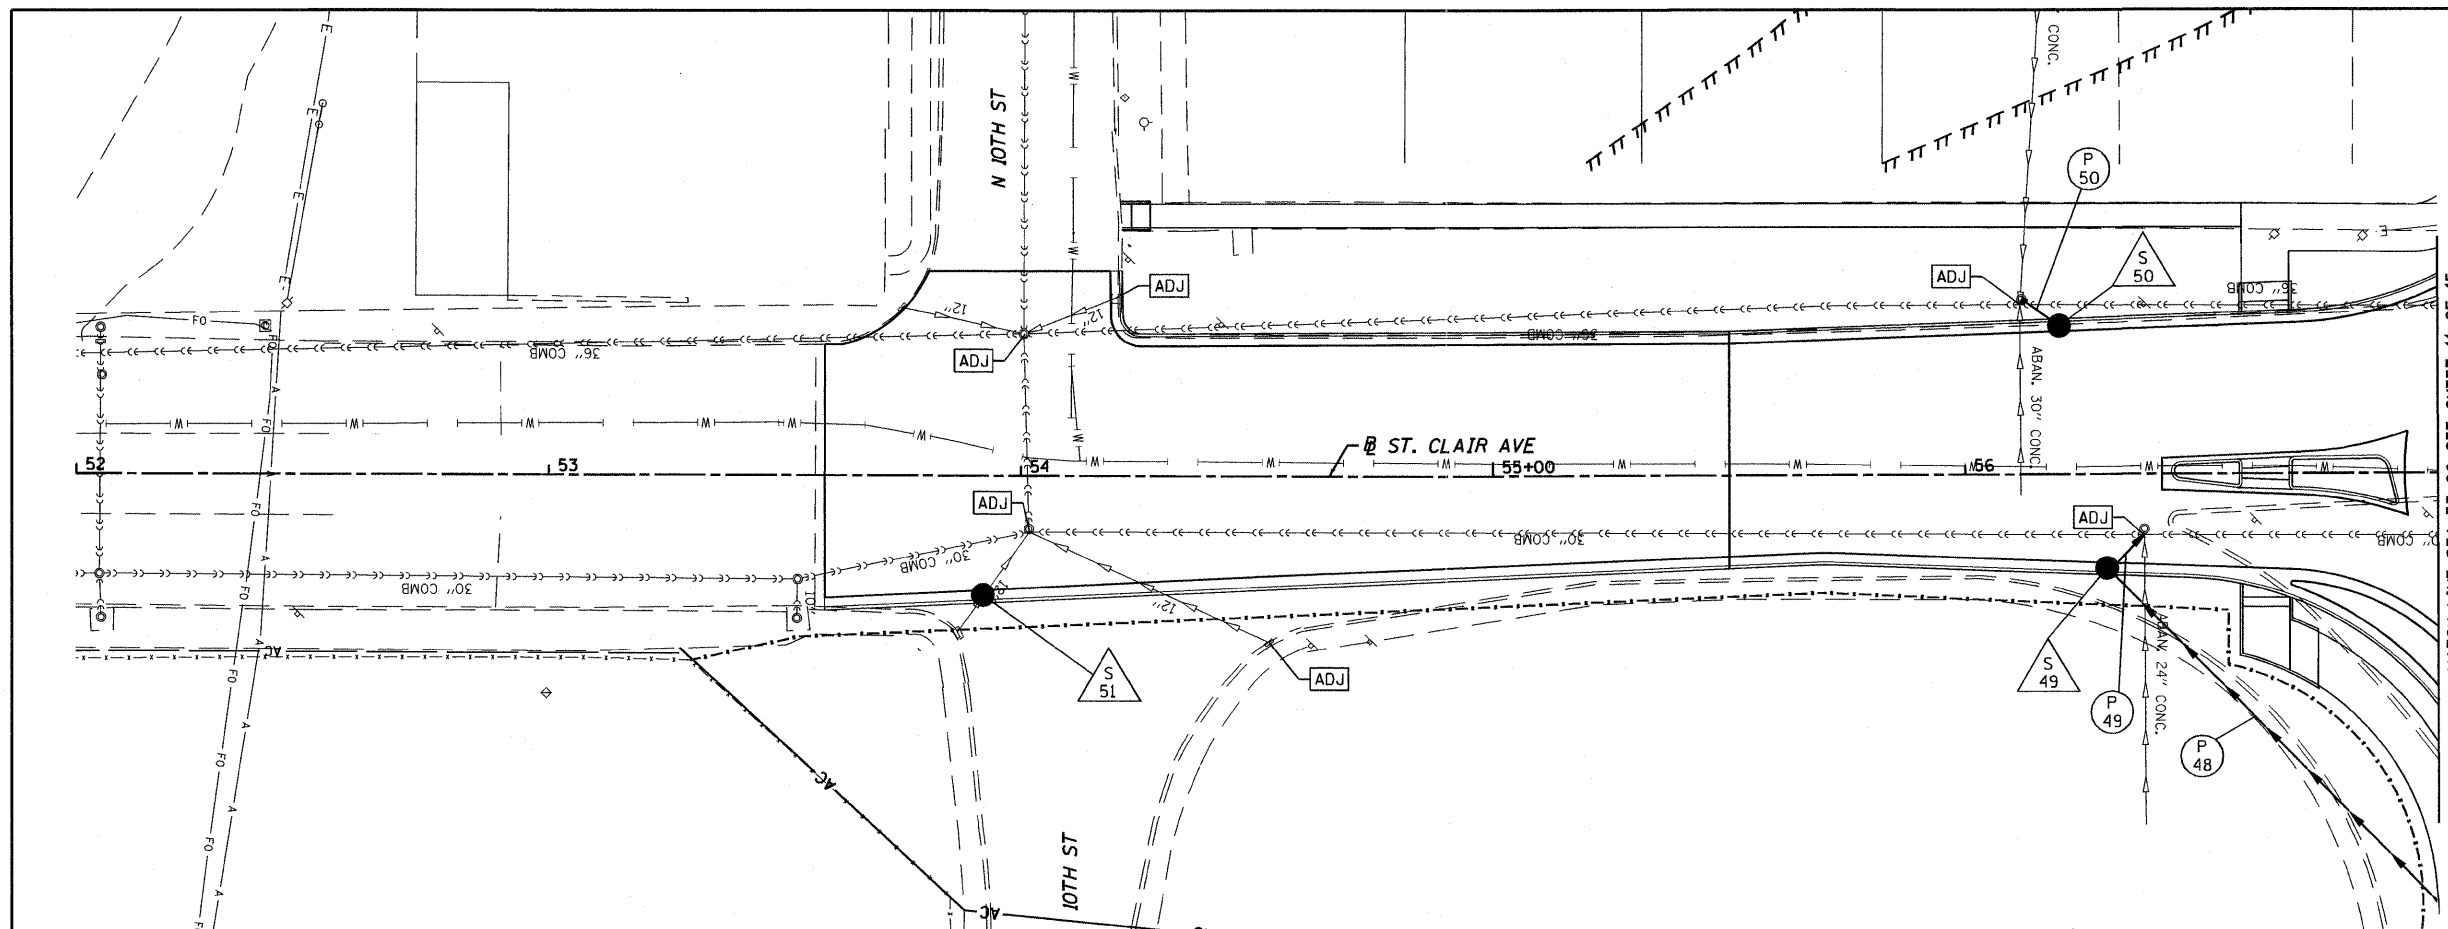

MATCH LINE STA 57+00 SEE SHEET 11 OF 15

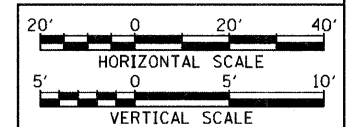

SEE STORM SEWER AND STRUCTURE SCHEDULES FOR DETAILED DRAINAGE DESIGN INFORMATION.

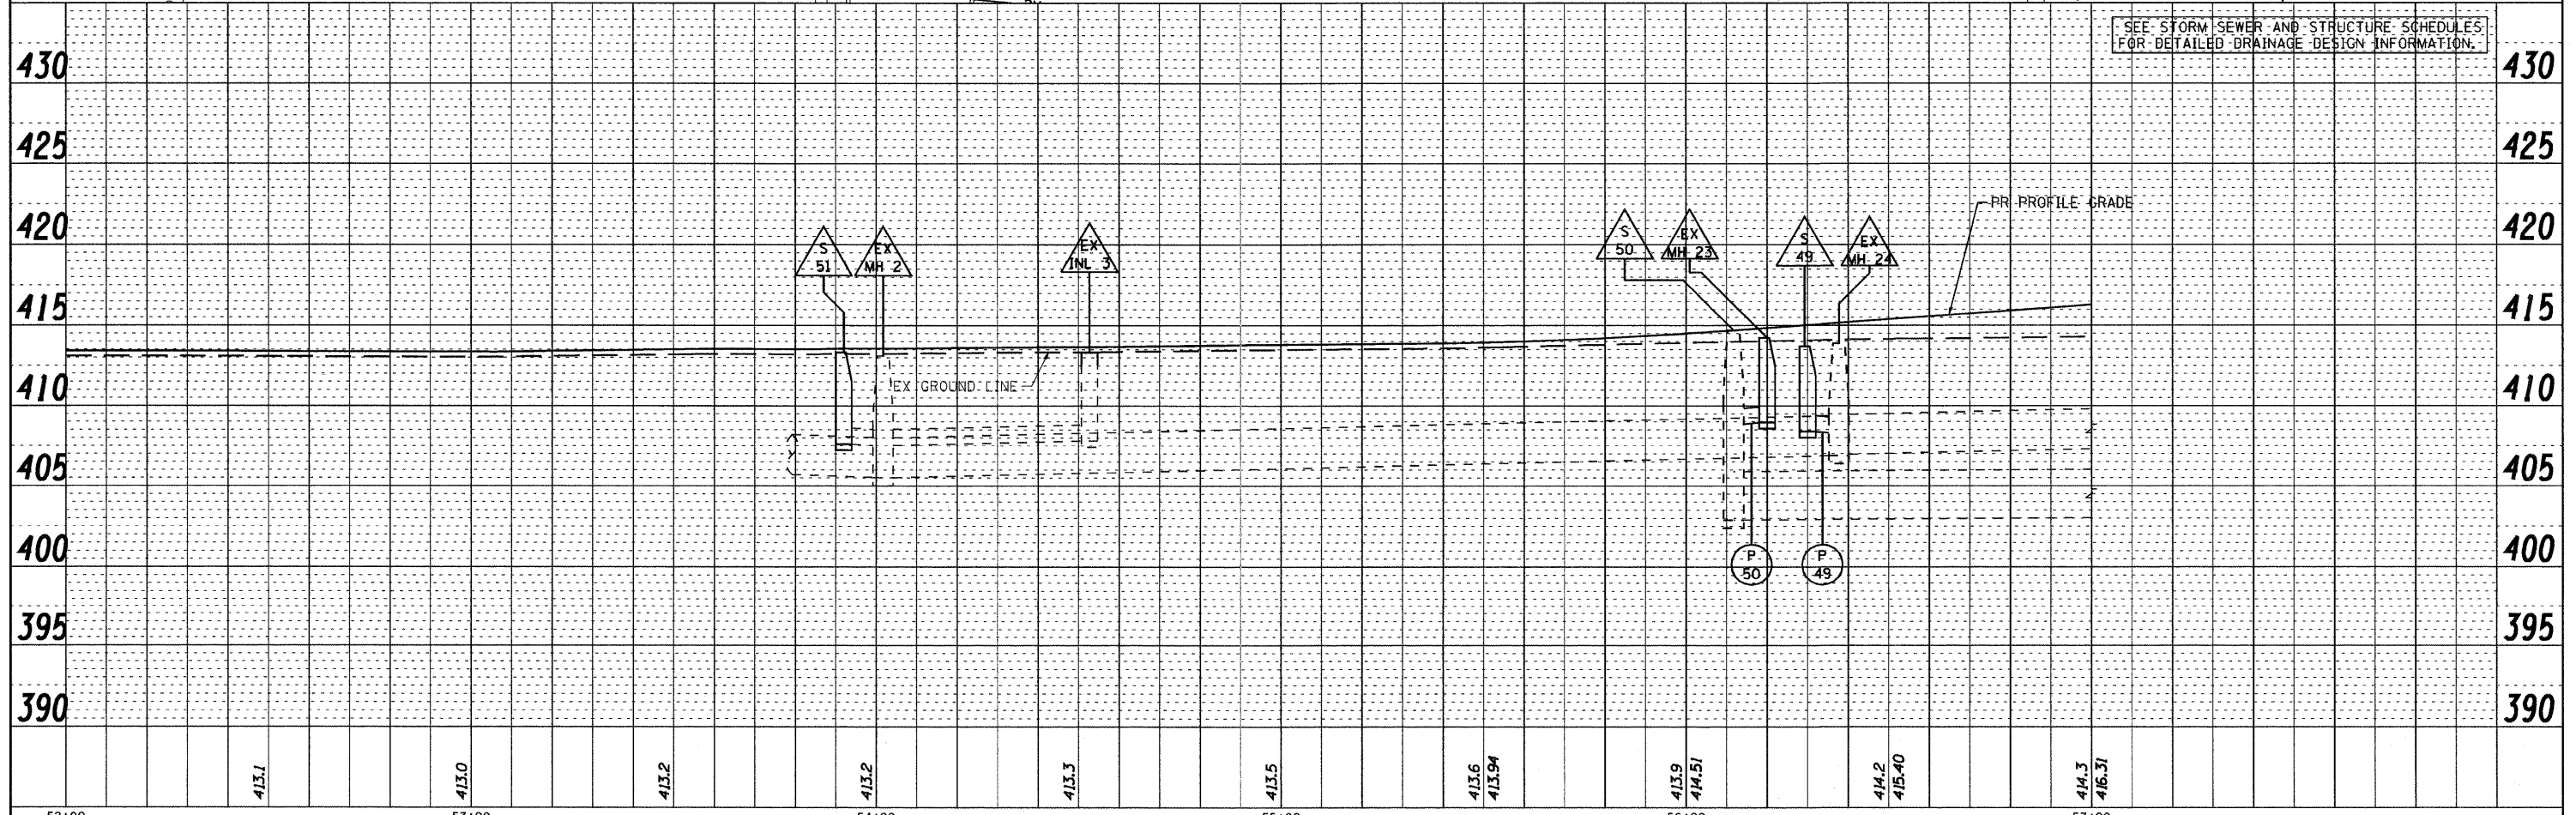

FILE NAME = DBTRI-76C51-sh1-drrnutil-001-014.dgn	USER NAME = jlt	DESIGNED - LDC	REVISED -	STATE OF ILLINOIS DEPARTMENT OF TRANSPORTATION	DRAINAGE AND UTILITY PLAN PROFILE ST. CLAIR AVENUE	F.A.U. RTE.	SECTION	COUNTY	TOTAL SHEETS	SHEET NO.
MODEL NAME = DBTRI-76C51-sh1-drrnutil-010	DRAWN - JDF	REVISED -	• 82-1-3HB, 82-2N, 82-1-12RS			ST. CLAIR	352	102		
PLOT SCALE = 1:40	CHECKED - GEB	REVISED -	• FAI 64/9166/9180			CONTRACT NO. 76C51				
PLOT DATE = 6/8/2011	DATE - 03/31/11	REVISED -	FED. ROAD DIST. NO.			ILLINOIS	FED. AID PROJECT			
SCALE: 1"=20'					SHEET NO. 10 OF 15 SHEETS		STA. 53+51.24 TO STA. 57+00.00			

6/8/2011 4:48:52 AM

P:\08-0030 CTE TRILEVEL\900 CAD\901 DRAWINGS\08 CONTRACT\SHEET\CV\LDRA\NAGE\08TRI-76C51-SH1-DRNUTL-001-014.DGN