



FILE NAME = G:\Illinois\110023\Work_Drwn_3_M0_Ave_P12\ACDD_Streams\DB76699-ahc-KL.A_Elec2.dgn

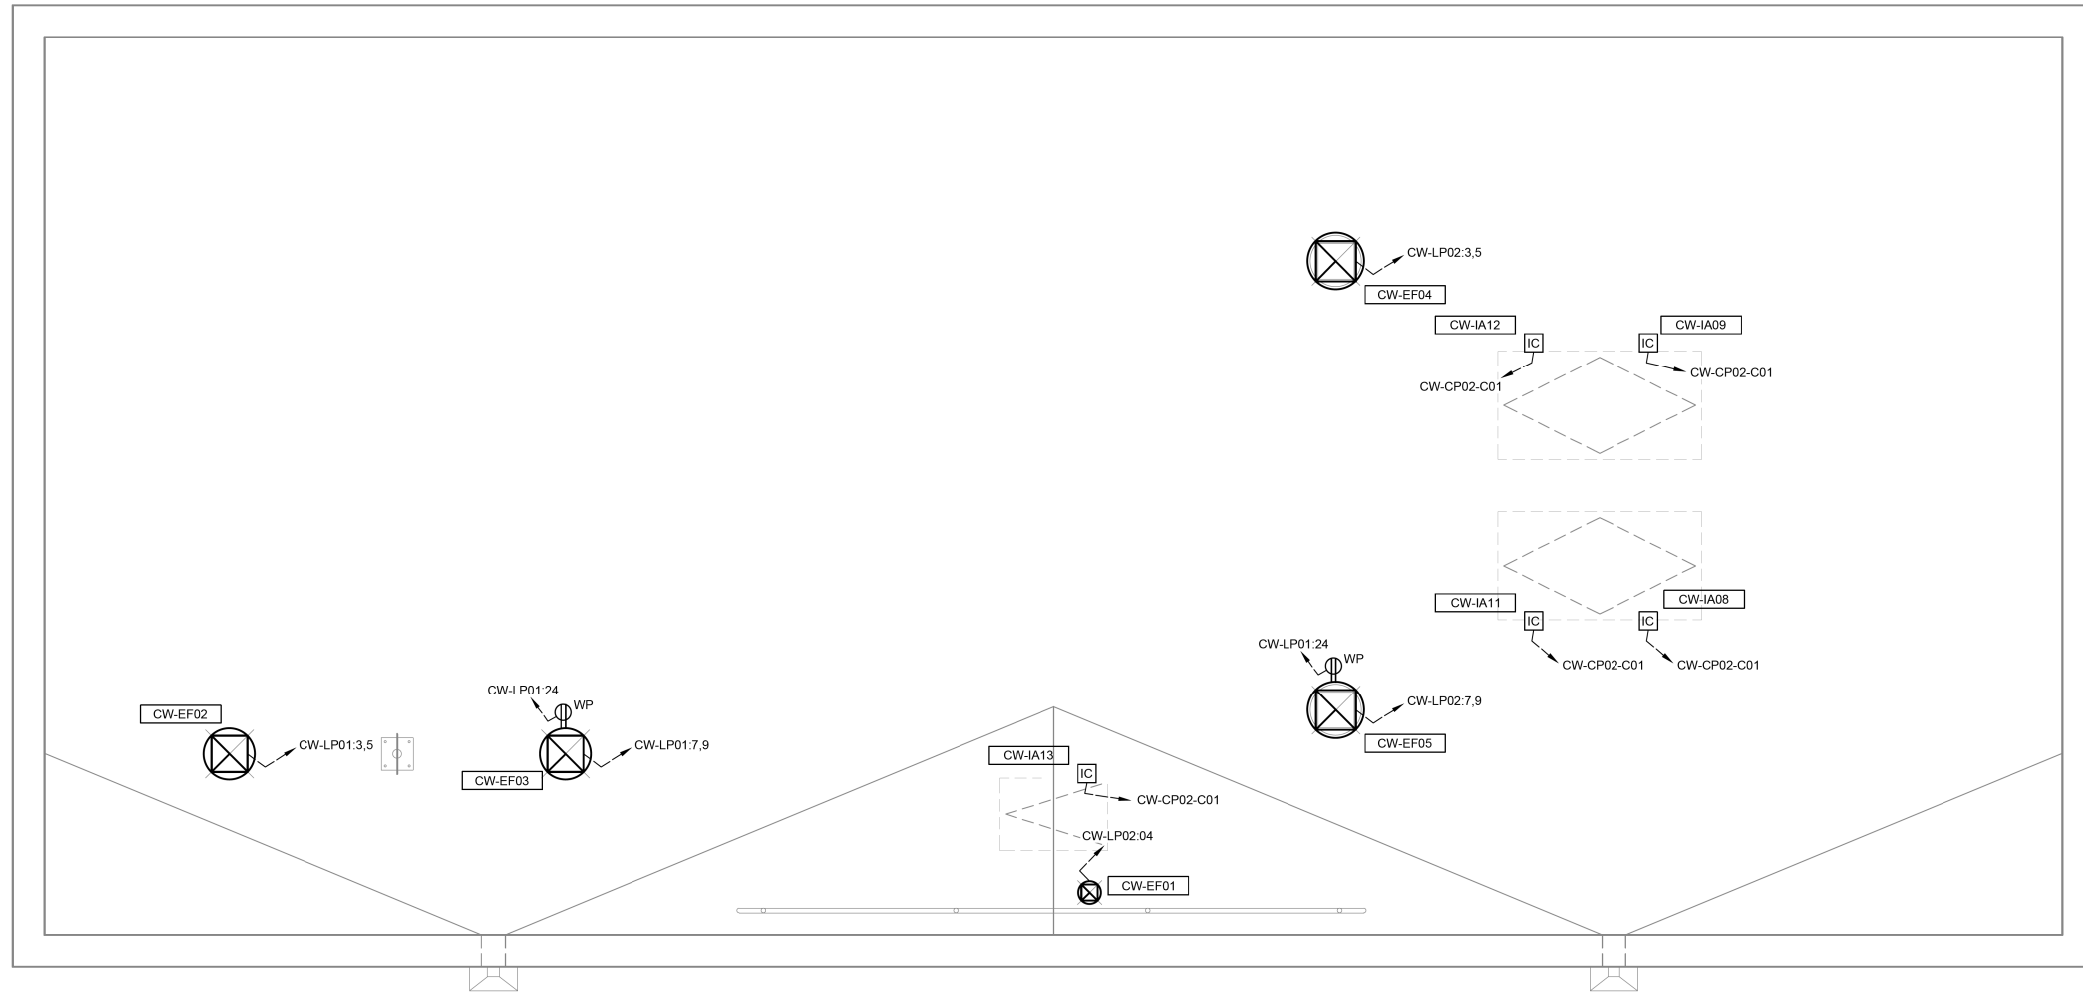

WELL HOUSE BUILDING - ROOF ELECTRICAL PLAN
SCALE: 1/4" = 1'-0"

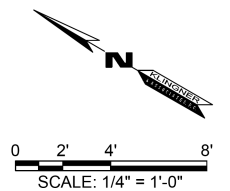

USER NAME = seb	DESIGNED - JUN	REVISED - JUN - 9/24/14
	DRAWN - JUN	REVISED -
PLOT SCALE = 40.0000' / in.	CHECKED -	REVISED -
PLOT DATE = 9/24/2014	DATE -	REVISED -

F.A.I. RTE.	SECTION	COUNTY	TOTAL SHEETS	SHEET NO.
64	82-4T-1	ST. CLAIR	185	161
CONTRACT NO. 76C99				
ILLINOIS FED. AID PROJECT				