


FILE NAME = G:\115\1150223\Work_Drwn_3_M0_Avg_P12\AC00D_Sheets\DB76599-ahc-KL4_Elec7.dgn

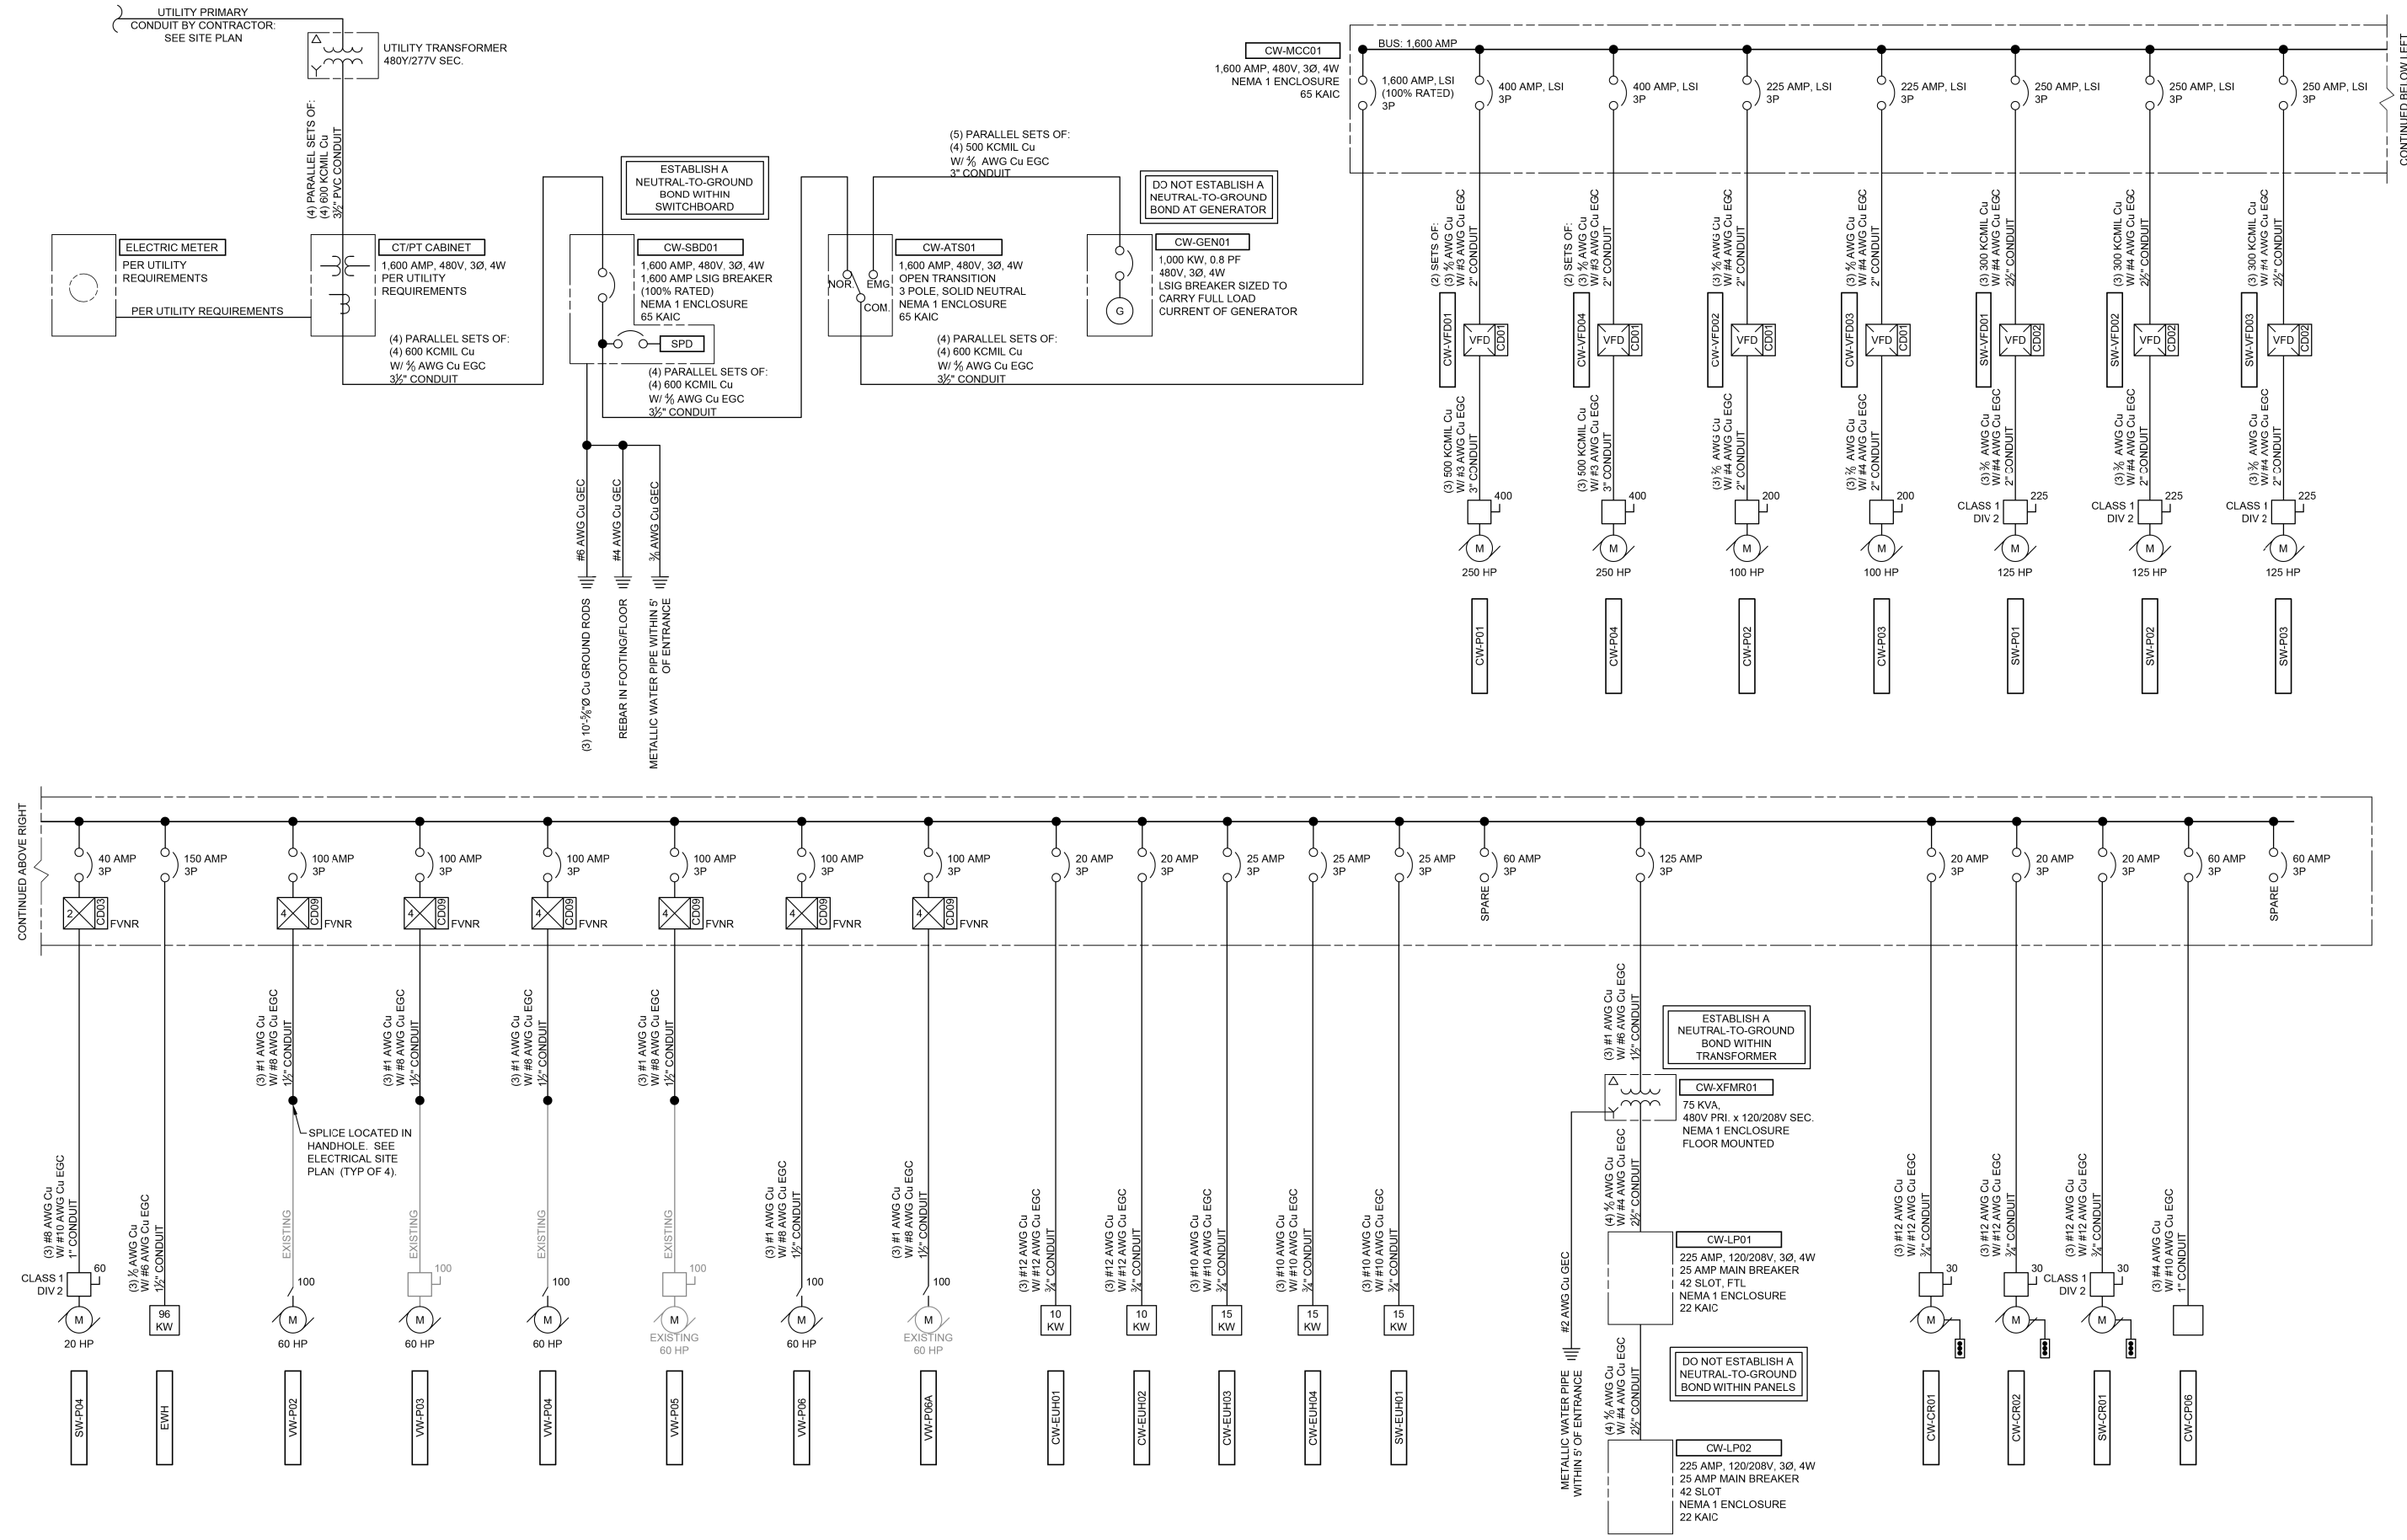

USER NAME = seb	DESIGNED - JUN	REVISED -
PLOT SCALE = 40.0000' / in.	DRAWN - JUN	REVISED -
PLOT DATE = 9/25/2014	CHECKED -	REVISED -
	DATE -	REVISED -

**STATE OF ILLINOIS
DEPARTMENT OF TRANSPORTATION**

ELECTRICAL ONE-LINE DIAGRAM		
MISSOURI AVENUE DEEP WELL FACILITY		
SCALE: AS NOTED	SHEET 1 OF 1 SHEETS	STA. TO STA.

F.A.I. RTE. 64	SECTION 82-4T-1	COUNTY ST. CLAIR	TOTAL SHEETS 185	SHEET NO. 169
ILLINOIS FED. AID PROJECT				