


FILE NAME = G:\115\110223\Work_Drwn_3_M0_Ave_Ph2\ACDD_Strengths\DB76599-ahc-KL.A_Elec_S.dgn

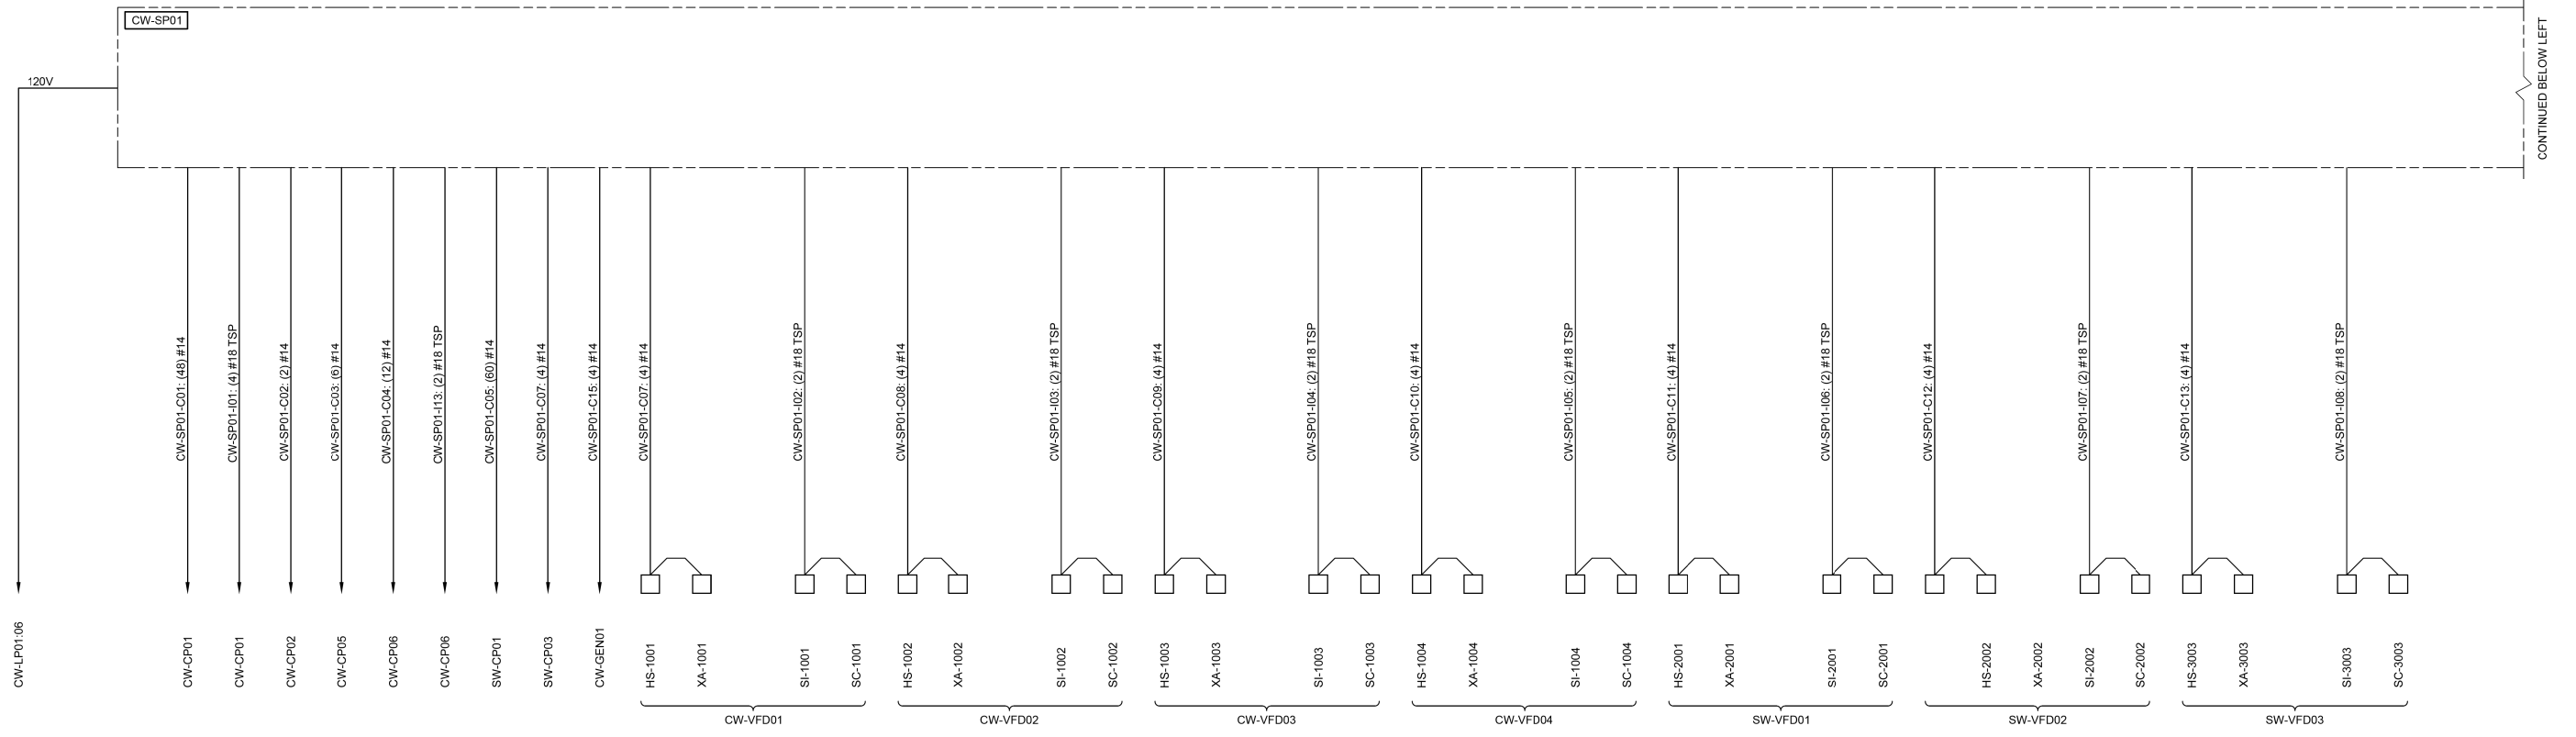

USER NAME = seb
 PLOT SCALE = 40.0000' / in.
 PLOT DATE = 9/25/2014

DESIGNED - JJN
 DRAWN - JJN
 CHECKED -
 DATE -

REVISED - JUN - 9/24/14
 REVISED -
 REVISED -
 REVISED -

STATE OF ILLINOIS
 DEPARTMENT OF TRANSPORTATION

CONTROL ONE-LINE DIAGRAM
 MISSOURI AVENUE DEEP WELL FACILITY

SCALE: SHEET 3 OF 3 SHEETS STA. TO STA.

F.A.I. RTE.	SECTION	COUNTY	TOTAL SHEETS	SHEET NO.
64	82-4T-1	ST. CLAIR	185	179
CONTRACT NO. 76C99				
ILLINOIS FED. AID PROJECT				

E905