



THIS SEAL APPLIES TO THIS SHEET ONLY



D. E. Mertz
 DAVID E. MERTZ, P.E.
 IL. REG. NO. 062-052068
 EXPIRES: 30 NOV 2005
 DATE: 17 August 2005


ALL DIMENSIONS IN METERS EXCEPT PAY ITEMS AND UNLESS NOTED OTHERWISE.

F.A.I. RTE.	SECTION	COUNTY	TOTAL SHEETS	SHEET NO.
80/94	(0203.1 & 0312-708W) R-3	COOK	870	429A
STA.	TO STA.			
FED. ROAD DIST. NO.	ILLINOIS	FED. AID PROJECT		
		CONTRACT #62108		

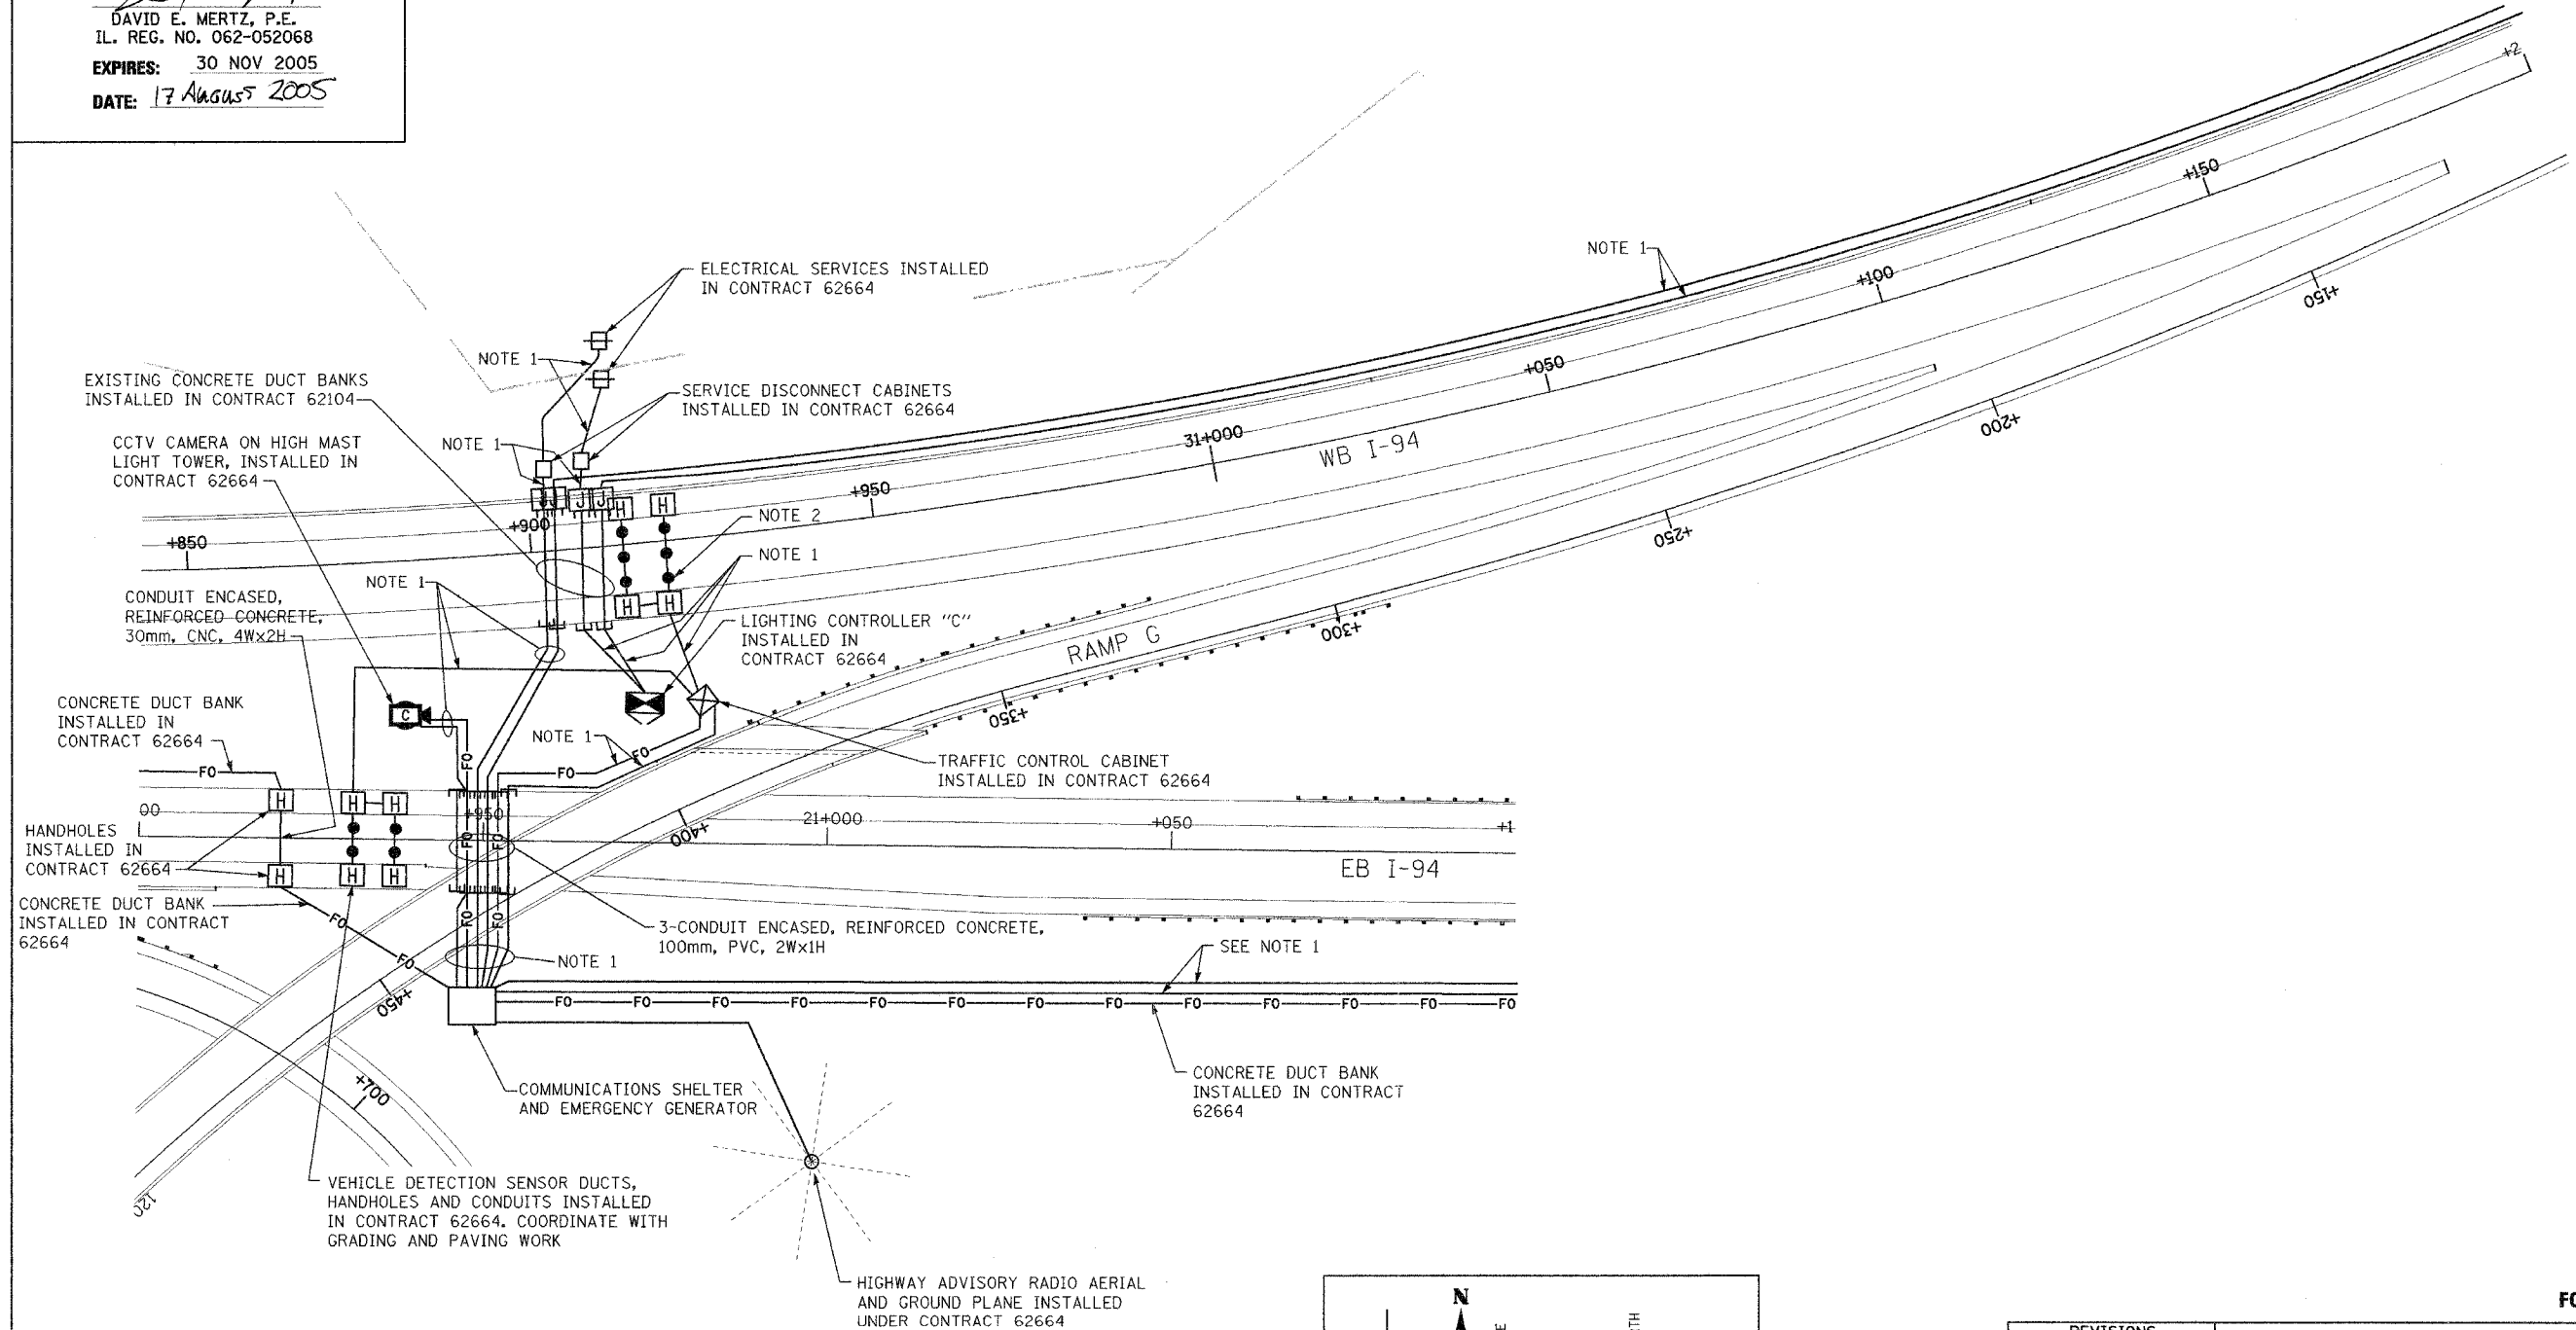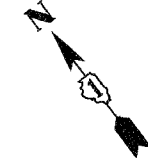

NOTES

1. CONDUITS IN TRENCH INSTALLED IN CONTRACT 62664.
2. EXISTING VEHICLE DETECTION SENSOR DUCTS, HANDHOLES AND CONDUITS IN EXISTING PAVEMENT.

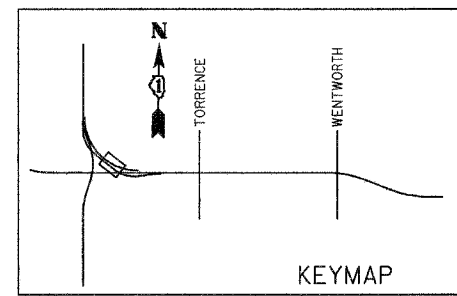

REVISIONS	
NAME	DATE

F019-01

ILLINOIS DEPARTMENT OF TRANSPORTATION
 I-94 EAST BOUND/IL 394 SOUTH BOUND

PROPOSED ELECTRICAL PLAN
 EB I-94
 STA. 20+900 TO STA. 21+100

SCALE 1:500
 DATE 01-16-04

DRAWN BY JRH/MAP
 CHECKED BY DEM/CMW