


ALL DIMENSIONS IN METERS EXCEPT PAVEMENT ITEMS AND UNLESS NOTED OTHERWISE


F.A.I. RTE.	SECTION	COUNTY	TOTAL SHEETS	SHEET NO.
80/94	2626.2-R-2	COOK/LAKE	1207	57
STA.	TO STA.			
FED. ROAD DIST. NO.	ILLINOIS FED. AID PROJECT			
CONTRACT NO. 62114	INDOT DES. NO. 0100987			

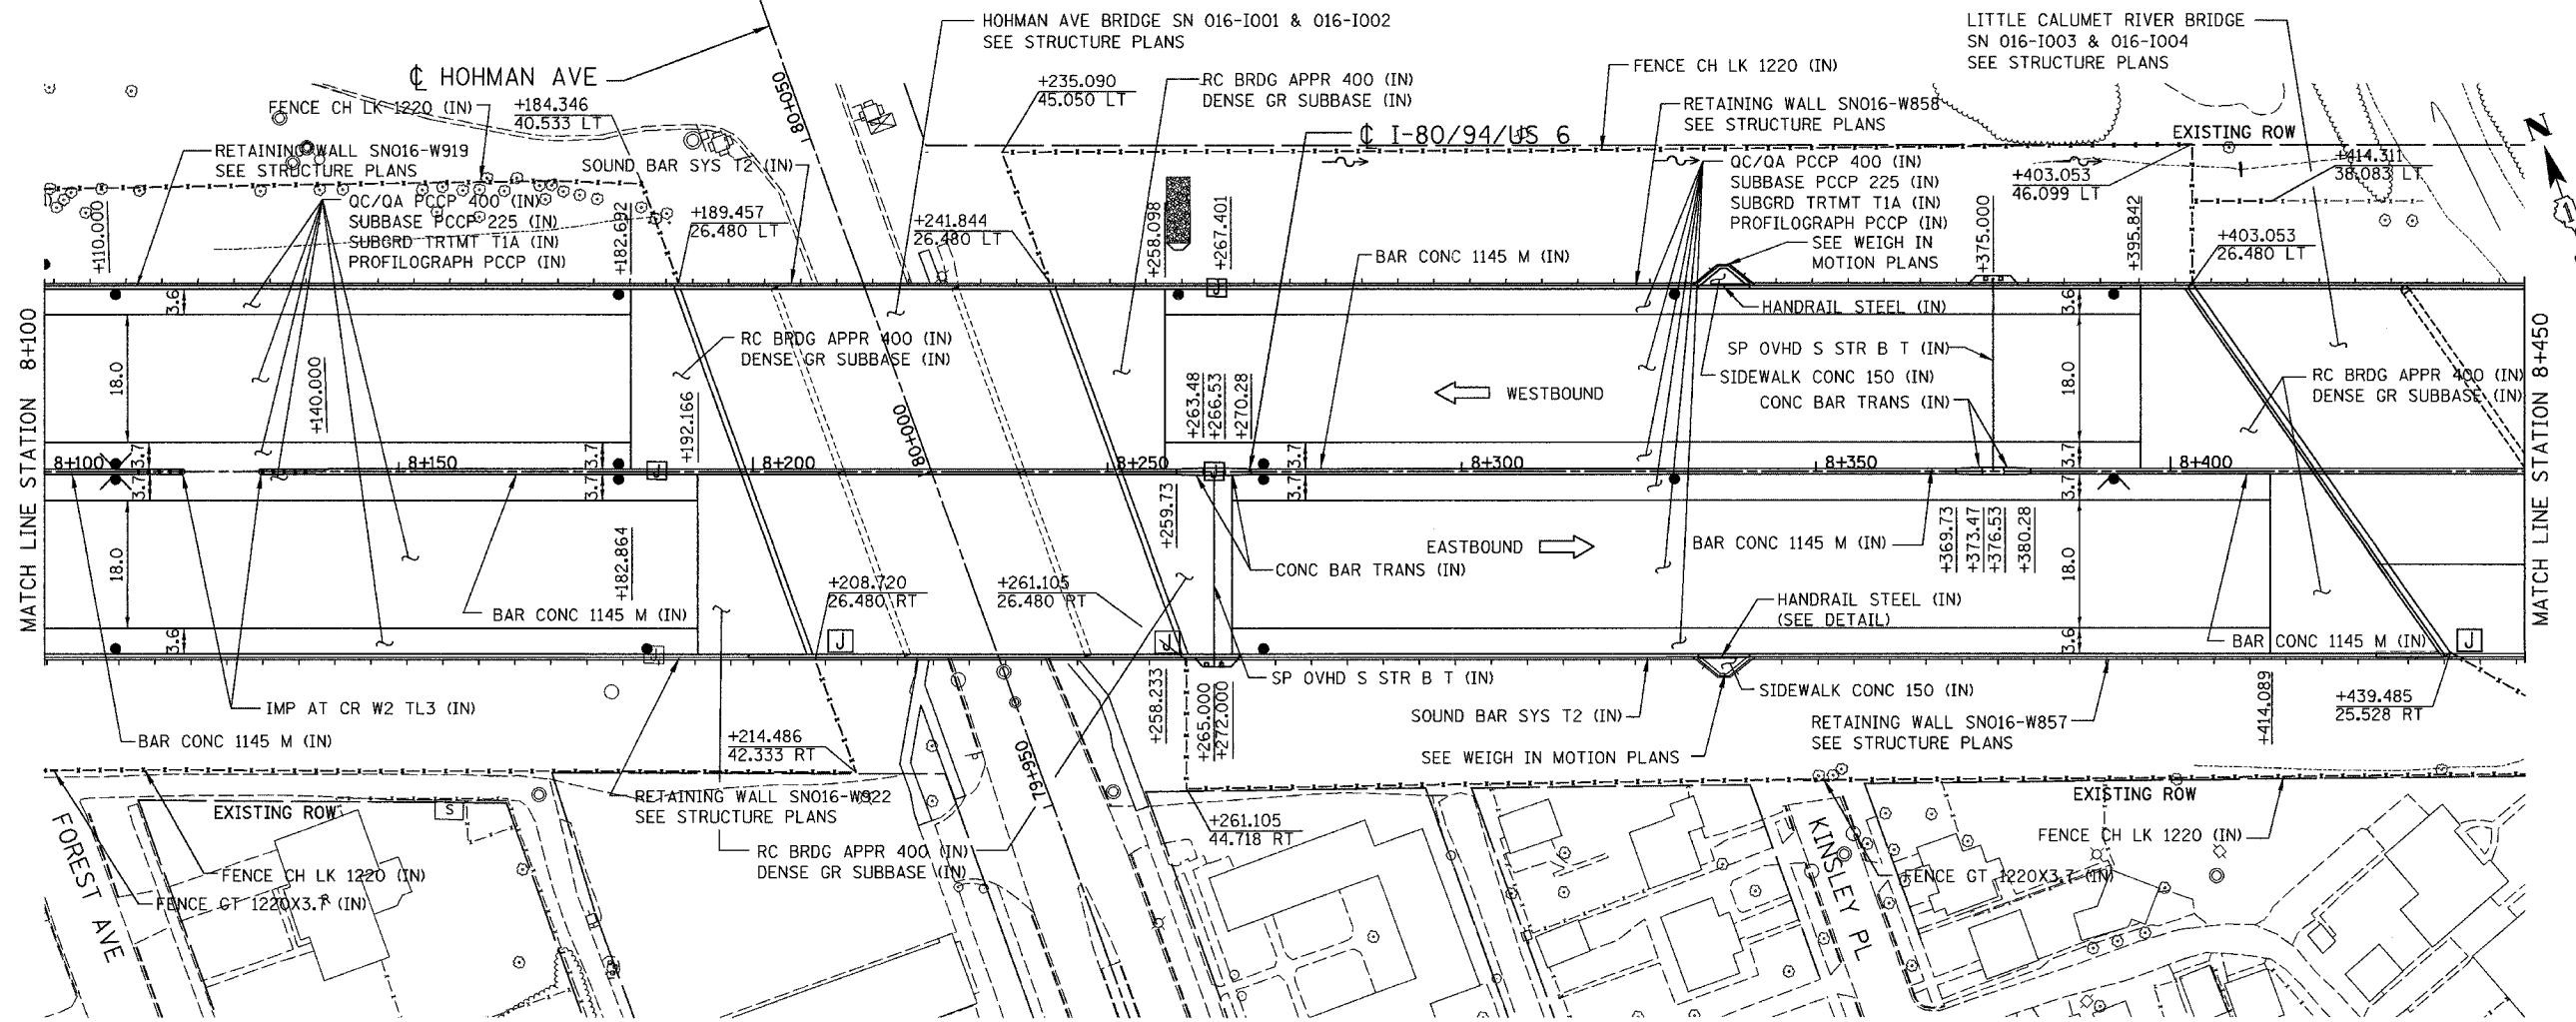

PROPOSED LEGEND:

- NOISE ABATEMENT (SOUND) WALL
- QC/OA PCCP 330
- SUBBASE PCCP 225 (IN)
- SUBGRD TRTMT T1A (IN)

NOTE: FOR ELECTRICAL WORK IN CONTRACT, SEE "ELECTRICAL INSTALLATION PLANS".  
FOR ELECTRICAL WORK BY OTHERS, SUBJECT TO CONTRACTOR MODIFICATION,  
SEE "EXISTING LIGHTING PLAN" SHEETS.

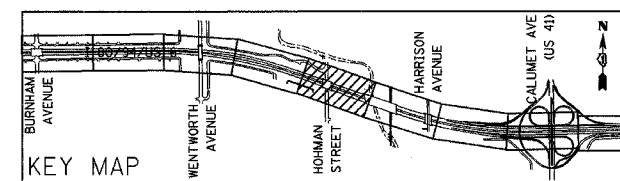

REVISIONS	
NAME	DATE

ILLINOIS DEPARTMENT OF TRANSPORTATION  
I-80/94/US 6  
KINGERY-BORMAN EXPRESSWAY  
BURNHAM ROAD TO US 41  
**PROPOSED PLAN**

**STA. 8+100 TO STA. 8+450**

SCALE 1:500 DRAWN BY ACE/CAD  
DATE 07/05 CHECKED BY TAE

**AMERICAN**  
CONSULTING ENGINEERS