



ALL DIMENSIONS IN METERS EXCEPT PAY ITEMS AND UNLESS NOTED OTHERWISE.


F.A.I. RTE.	SECTION	COUNTY	TOTAL SHEETS	SHEET NO.
80/94	2626.2-R-2	COOK	1207	473
STA.	TO STA.			
FED. ROAD DIST. NO.	ILLINOIS	FED. AID PROJECT		
CONTRACT #62114	INDOT DES. NO. 0100987			

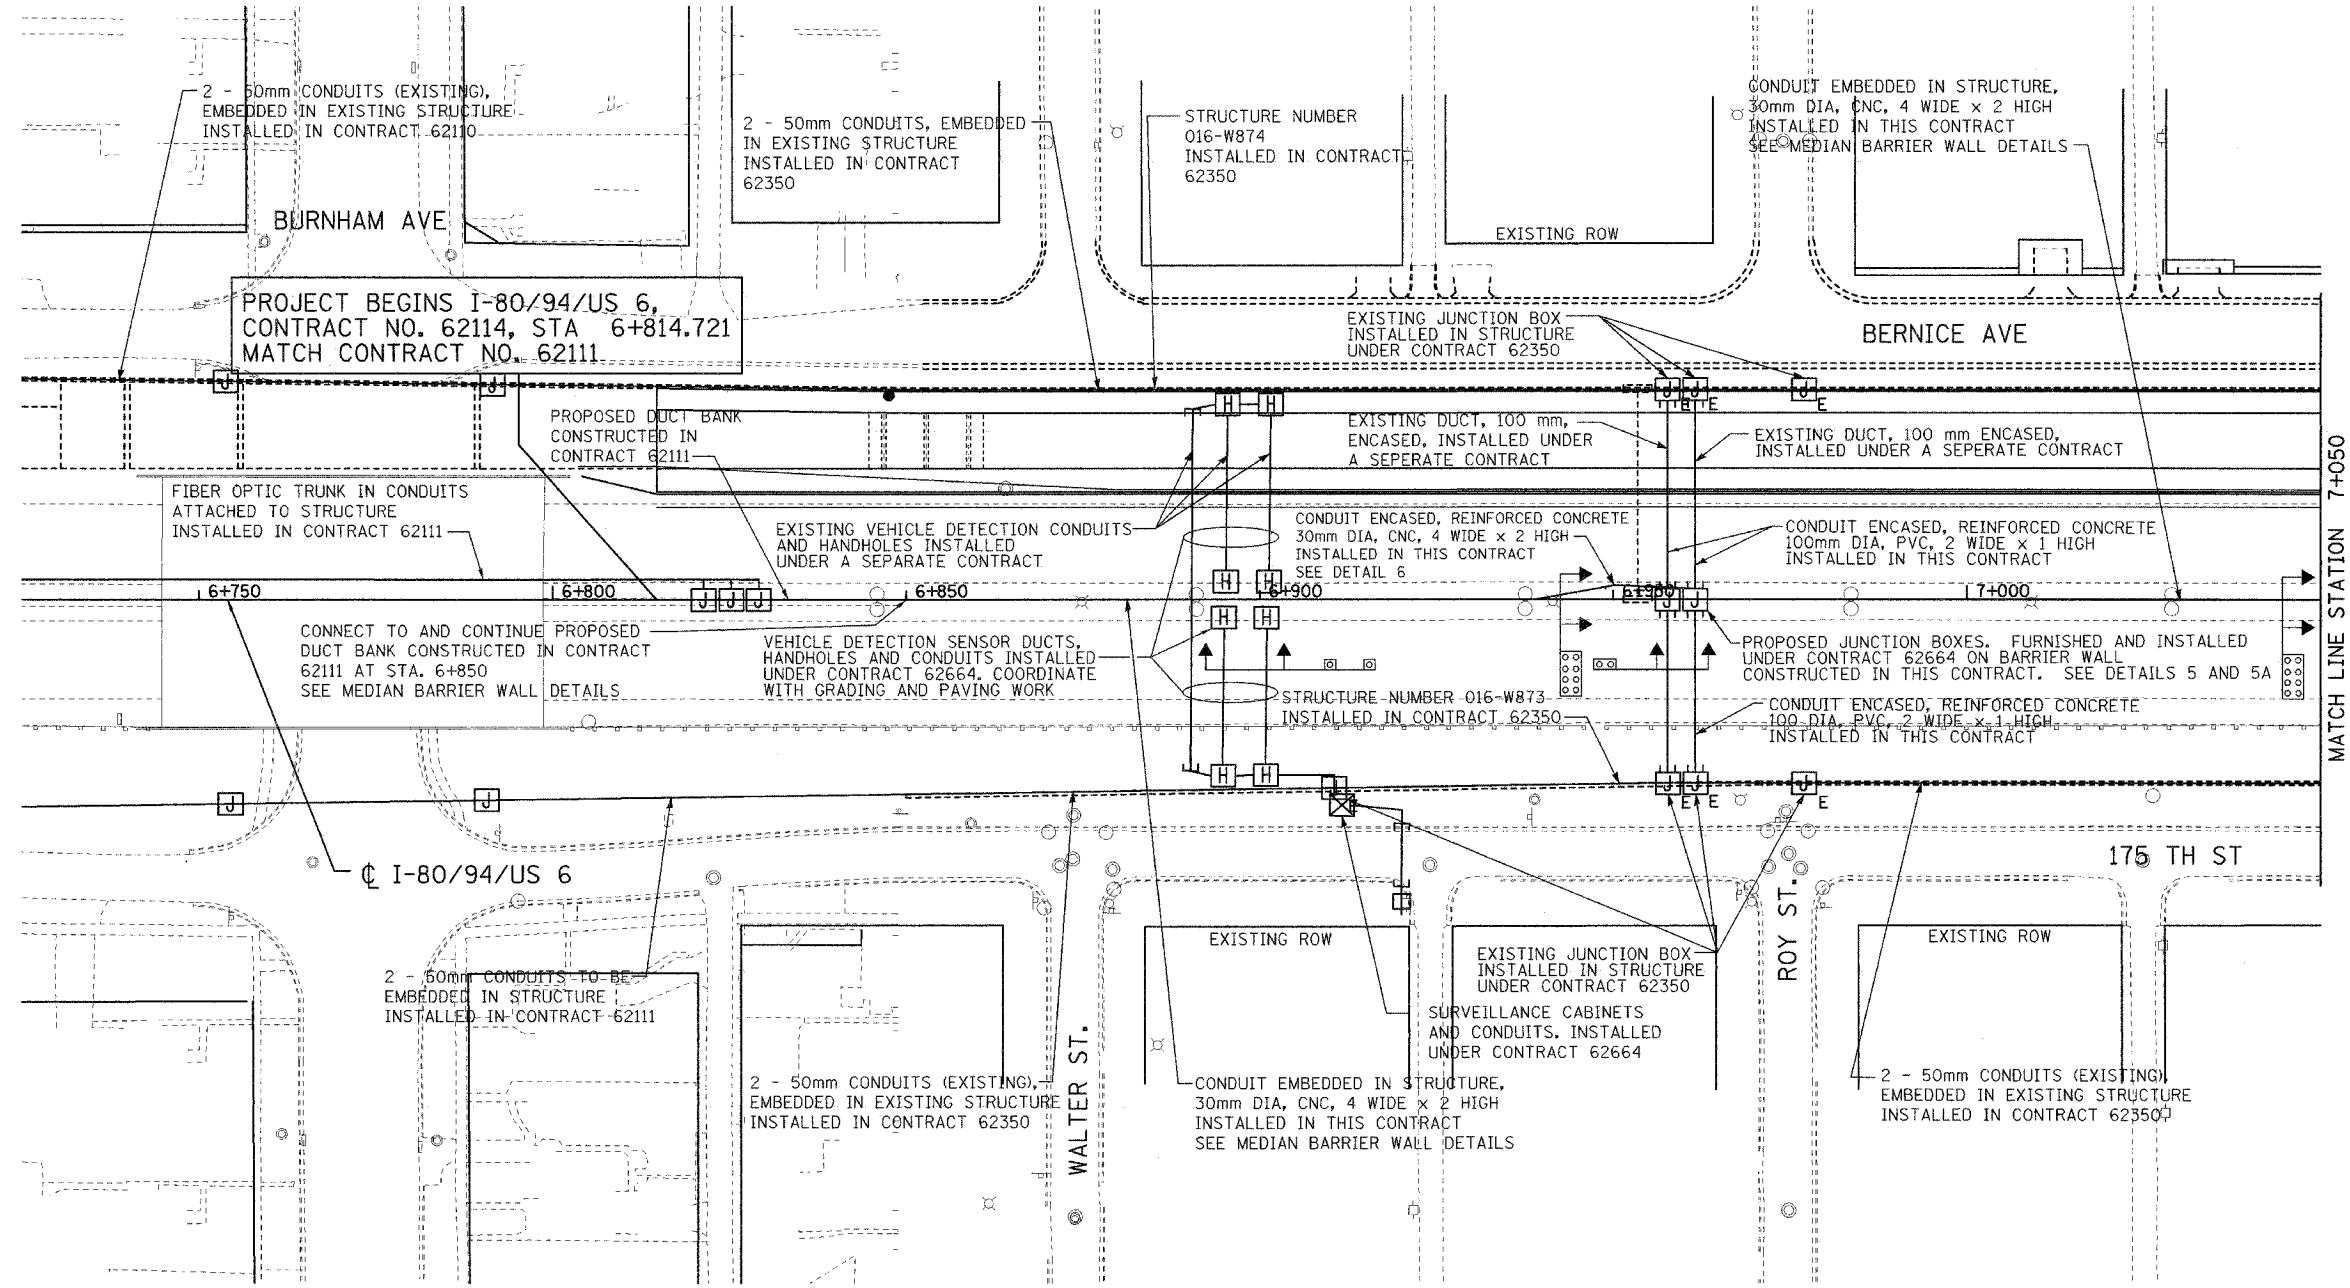

THESE SEALS APPLY TO SHEETS 473 THRU 488 ONLY

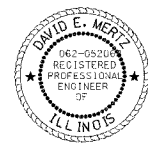


David E. Mertz
 DAVID E. MERTZ, P.E.
 IL. REG. NO. 062-052068
 EXPIRES: 30 NOV 2005
 DATE: 15 August 2005

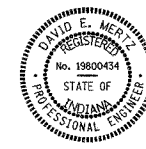

David E. Mertz
 DAVID E. MERTZ, P.E.
 IN. REG. NO. 19800434
 EXPIRES: 31 JULY 2006
 DATE: 15 August 2005

NOTE:
 SEE SHEET GE-1 FOR ELECTRICAL LEGEND.
 (TYPICAL FOR ALL ELECTRICAL SHEETS)

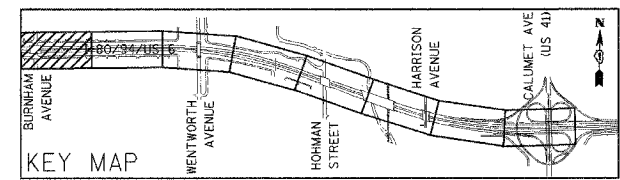

REVISIONS	
NAME	DATE

SHEET 1 OF 16

ILLINOIS DEPARTMENT OF TRANSPORTATION
 I-80/94/US 6
 KINGERY-BORMAN EXPRESSWAY
 BURNHAM ROAD TO US 41
 ELECTRICAL INSTALLATION PLAN

STA. 6 + 814.721 TO STA. 7 + 050
 SCALE 1:500
 DATE 07/05
 DRAWN BY JRH
 CHECKED BY DEM