


SIGN DETAIL  
1:75

EB-BM-101  
STA. 997+70

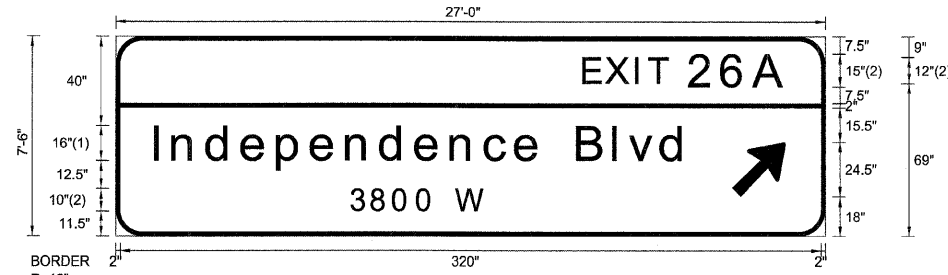

BORDER  
R=12"  
TH=2"

FONT:  
(1) ClearviewHwy-5-W-R  
(2) ClearviewHwy-5-W

SIGN NUMBER	name
WIDTH x HGHT.	27'-0" x 7'-6"
BORDER WIDTH	2"
CORNER RADIUS	12"
MOUNTING	Overhead
BACKGROUND	TYPE: Reflective COLOR: Green
LEGEND/BORDER	TYPE: Reflective COLOR: White/White

SYMBOL	ROT	X	Y	WID	HT
ARMED	45	281.5	18	20	31.5

Panel Style: sign\_default.ssi  
Dimensions are in inches.tenths

Letter locations are panel edge to lower left corner

LETTER POSITIONS (X)

LETTER POSITIONS (X)																		LENGTH	SERIESSIZE
E	X	I	T	2	6	A												92	ClearviewHwy-5-W 12,15
214	224.3	237.9	243.8	262.5	277.6	292												243	ClearviewHwy-5-W-R 1613
I	n	d	e	p	e	n	d	e	n	c	e	B	I	v	d			61.3	ClearviewHwy-5-W-R 10
18	26.4	41.9	57.9	74.1	89.5	105.7	121.3	137.3	153.5	169	182.9	194.6	211.2	227.8	234.7	249.4			
3	8	0	0		W														
107.4	116.9	126.9	137.8	146	155.5														

FILE NAME =	DESIGNED - SEW	REVISED -
*FILEL*	DRAWN - SEW	REVISED -
USER NAME = #USER*	CHECKED - SEW	REVISED -
PLOT DATE = #DATE*	DATE - 12/2009	REVISED -



STATE OF ILLINOIS  
DEPARTMENT OF TRANSPORTATION

SIGNING DETAILS

SCALE: N.T.S. SHEET NO. 6 OF 79 SHEETS STA. TO STA.

F.A.I. RTE.	SECTION	COUNTY	TOTAL SHEETS	SHEET NO.
290	(2828B,D, ETC., 3031.1)RS-6	COOK	300	219
FED. ROAD DIST. NO.			ILLINOIS FED. AID PROJECT	
CONTRACT NO. 60G53				