


SIGN DETAIL
1:75

EB-BM-128
STA. 1184+20

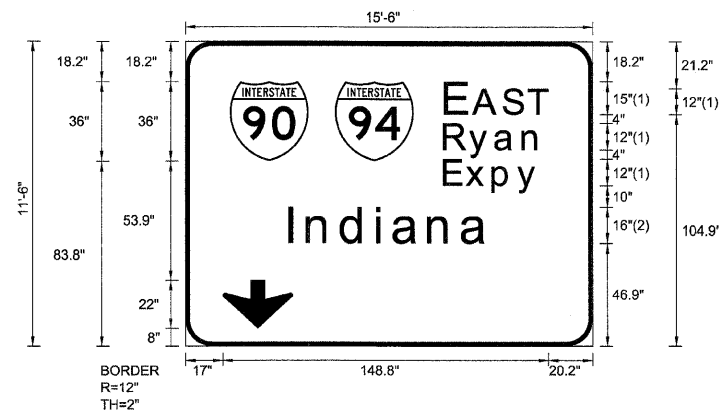

SIGN NUMBER	name
WIDTH x HGHT.	15'-6" x 11'-6"
BORDER WIDTH	2"
CORNER RADIUS	12"
MOUNTING	Overhead
BACKGROUND	TYPE: Reflective
	COLOR: Green
LEGEND/BORDER	TYPE: Reflective
	COLOR: White/White

SYMBOL	ROT	X	Y	WID	HT
M1_1	0	20.3	83.8	36	36
M1_1	0	68.3	83.8	36	36
ARDOWN	0	17	8	32	22

Panel Style: sign_default.ssi
Dimensions are in inches.tenths

FONT:
(1) ClearviewHwy-5-W
(2) ClearviewHwy-5-W-R

Letter locations are panel edge to lower left corner

LETTER POSITIONS (X)

										LENGTH	SERIESSIZE
E	A	S	T								ClearviewHwy-5-W
119.3	132	145.7	157.1							46.5	15,12
R	y	a	n								ClearviewHwy-5-W
118.7	130.2	142	154.7							44.3	129.8
E	x	p	y								ClearviewHwy-5-W
118.7	128.7	140.9	152.2							42.9	129.8
I	n	d	i	a	n	a					ClearviewHwy-5-W-R
47.6	56	71.5	87.9	95.4	111.4	126.6				90.8	1613

FILE NAME =	DESIGNED - SEW	REVISED -
\$FILEL\$	DRAWN - SEW	REVISED -
USER NAME = \$USER\$	CHECKED - SEW	REVISED -
PLOT DATE = \$DATE\$	DATE - 12/2009	REVISED -



STATE OF ILLINOIS
DEPARTMENT OF TRANSPORTATION

SIGNING DETAILS			
SCALE: N.T.S.	SHEET NO. 27 OF 79 SHEETS	STA.	TO STA.

F.A.I. RTE.	SECTION	COUNTY	TOTAL SHEETS	SHEET NO.
290	(2828B,D, ETC., 3031,1)RS-6	COOK	300	240
FED. ROAD DIST. NO. ILLINOIS FED. AID PROJECT			CONTRACT NO. 60653	