

STATE OF ILLINOIS
DEPARTMENT OF TRANSPORTATION
DIVISION OF HIGHWAYS

PLANS FOR PROPOSED FEDERAL AID HIGHWAY

**FAU 1683 (BERNICE ROAD)
STREET LIGHTING
OAK AVENUE TO WENTWORTH AVENUE (FAU 2946)
SECTION NO.: 09-00166-01-LT
C-91-650-09
VILLAGE of LANSING
COOK COUNTY
ARA - 9003(335)**

F. A. U. NO.	SECTION	COUNTY	TOTAL SHEETS	SHEET NO.
1683	09-00166-01-LT	COOK	12	1
STA. 14+75		TO STA. 86+25		
FED. ROAD DIST. NO. 1		ILLINOIS	FED. AID PROJECT 9003(335)	


CONTRACT #63285

INDEX OF SHEETS

1. COVER SHEET
2. SUMMARY OF QUANTITIES & GENERAL NOTES
- 3.-6. STREET LIGHTING PLANS
7. SINGLE LINE DIAGRAM
- 8.-12. DETAIL DRAWINGS


STATE STANDARDS

- 000001-05 STANDARD SYMBOLS, ABBREVIATIONS AND PATTERNS
- 701501-05 URBAN LANE CLOSURE, 2L, 2W, UNDIVIDED
- 701606-06 URBAN LANE CLOSURE, MULTILANE, 2W, WITH MOUNTABLE MEDIAN
- 701701-06 URBAN LANE CLOSURE, MULTILANE INTERSECTION
- 701801-04 LANE CLOSURE, MULTILANE 1W OR 2W CROSSWALK OR SIDEWALK CLOSURE
- 701901-01 TRAFFIC CONTROL DEVICES

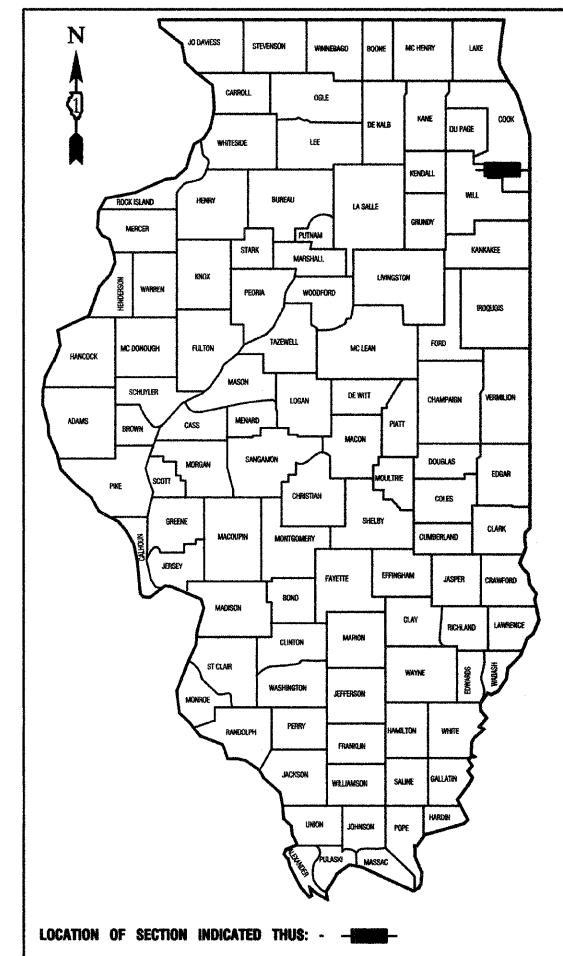

SCALES


- PLAN - 1"=50'
- PROFILE HORIZ. - 1"=50'
- PROFILE VERT. - 1"=5'
- CROSS SECTIONS - 1"=10'

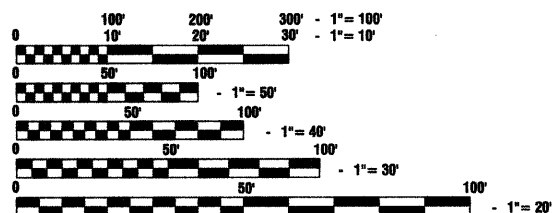

FULL SIZE PLANS HAVE BEEN PREPARED USING STANDARD ENGINEERING SCALES, REDUCED SIZED PLANS WILL NOT CONFORM TO STANDARD SCALES, IN MAKING MEASUREMENTS ON REDUCED PLANS, THE ABOVE SCALES MAY BE USED.

J. U. L. I. E.
JOINT UTILITY LOCATION INFORMATION FOR EXCAVATION
1-800-892-0123 or 811

CONTRACT NO. 63285

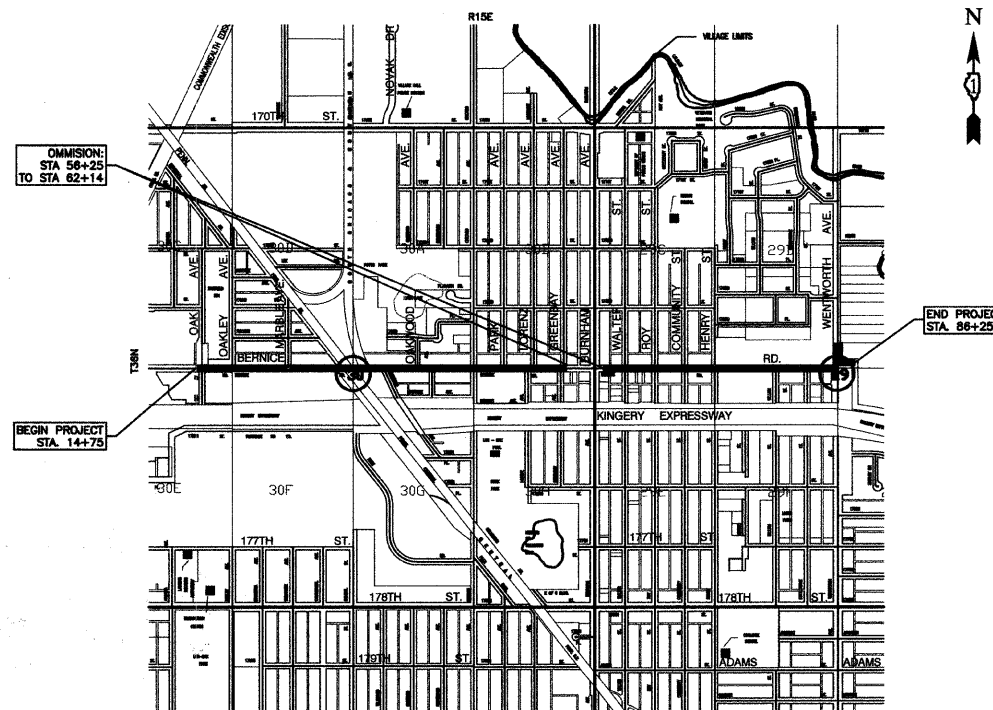

PROJECT LOCATION

GROSS LENGTH= 7,150 FEET = 1.35 MILES
NET LENGTH= 6,561 FEET = 1.24 MILES

BERNICE ROAD COLLECTOR
ADT=12,300 (2009)
=15,000 (2030)
DESIGN SPEED=35 MPH
SPEED LIMIT= 30 MPH

STATE OF ILLINOIS DEPARTMENT OF TRANSPORTATION
DIVISION OF HIGHWAYS

Approved 10-19-09
Vernon F. Ralston
Mayor, Village of Lansing

Passed OCTOBER 26, 2009
Cheryl Christofferholt
District 1 Engineer of Local Roads & Streets

Released for Bid
Based on Limited
Review OCTOBER 26, 2009
Diana M. O'Keefe
Deputy Director of Highways, Region 1 Engineer

PRINTED BY THE AUTHORITY OF
THE STATE OF ILLINOIS

PREPARED BY OR UNDER THE
DIRECT SUPERVISION OF:

Edward J. Fundulis
10/20/09



LICENSE EXPIRES: 11/30/11

I.D.O.T. FIELD ENGINEER: MELCHOR MANGOBA: 847-705-4408
CONSULTANTS: ROBINSON ENGINEERING, LTD. 708-331-6700