


REVISIONS	DATE
PLANNED	
CHECKED	
BY	
NO.	

REVISIONS	DATE
PLANNED	
CHECKED	
BY	
NO.	

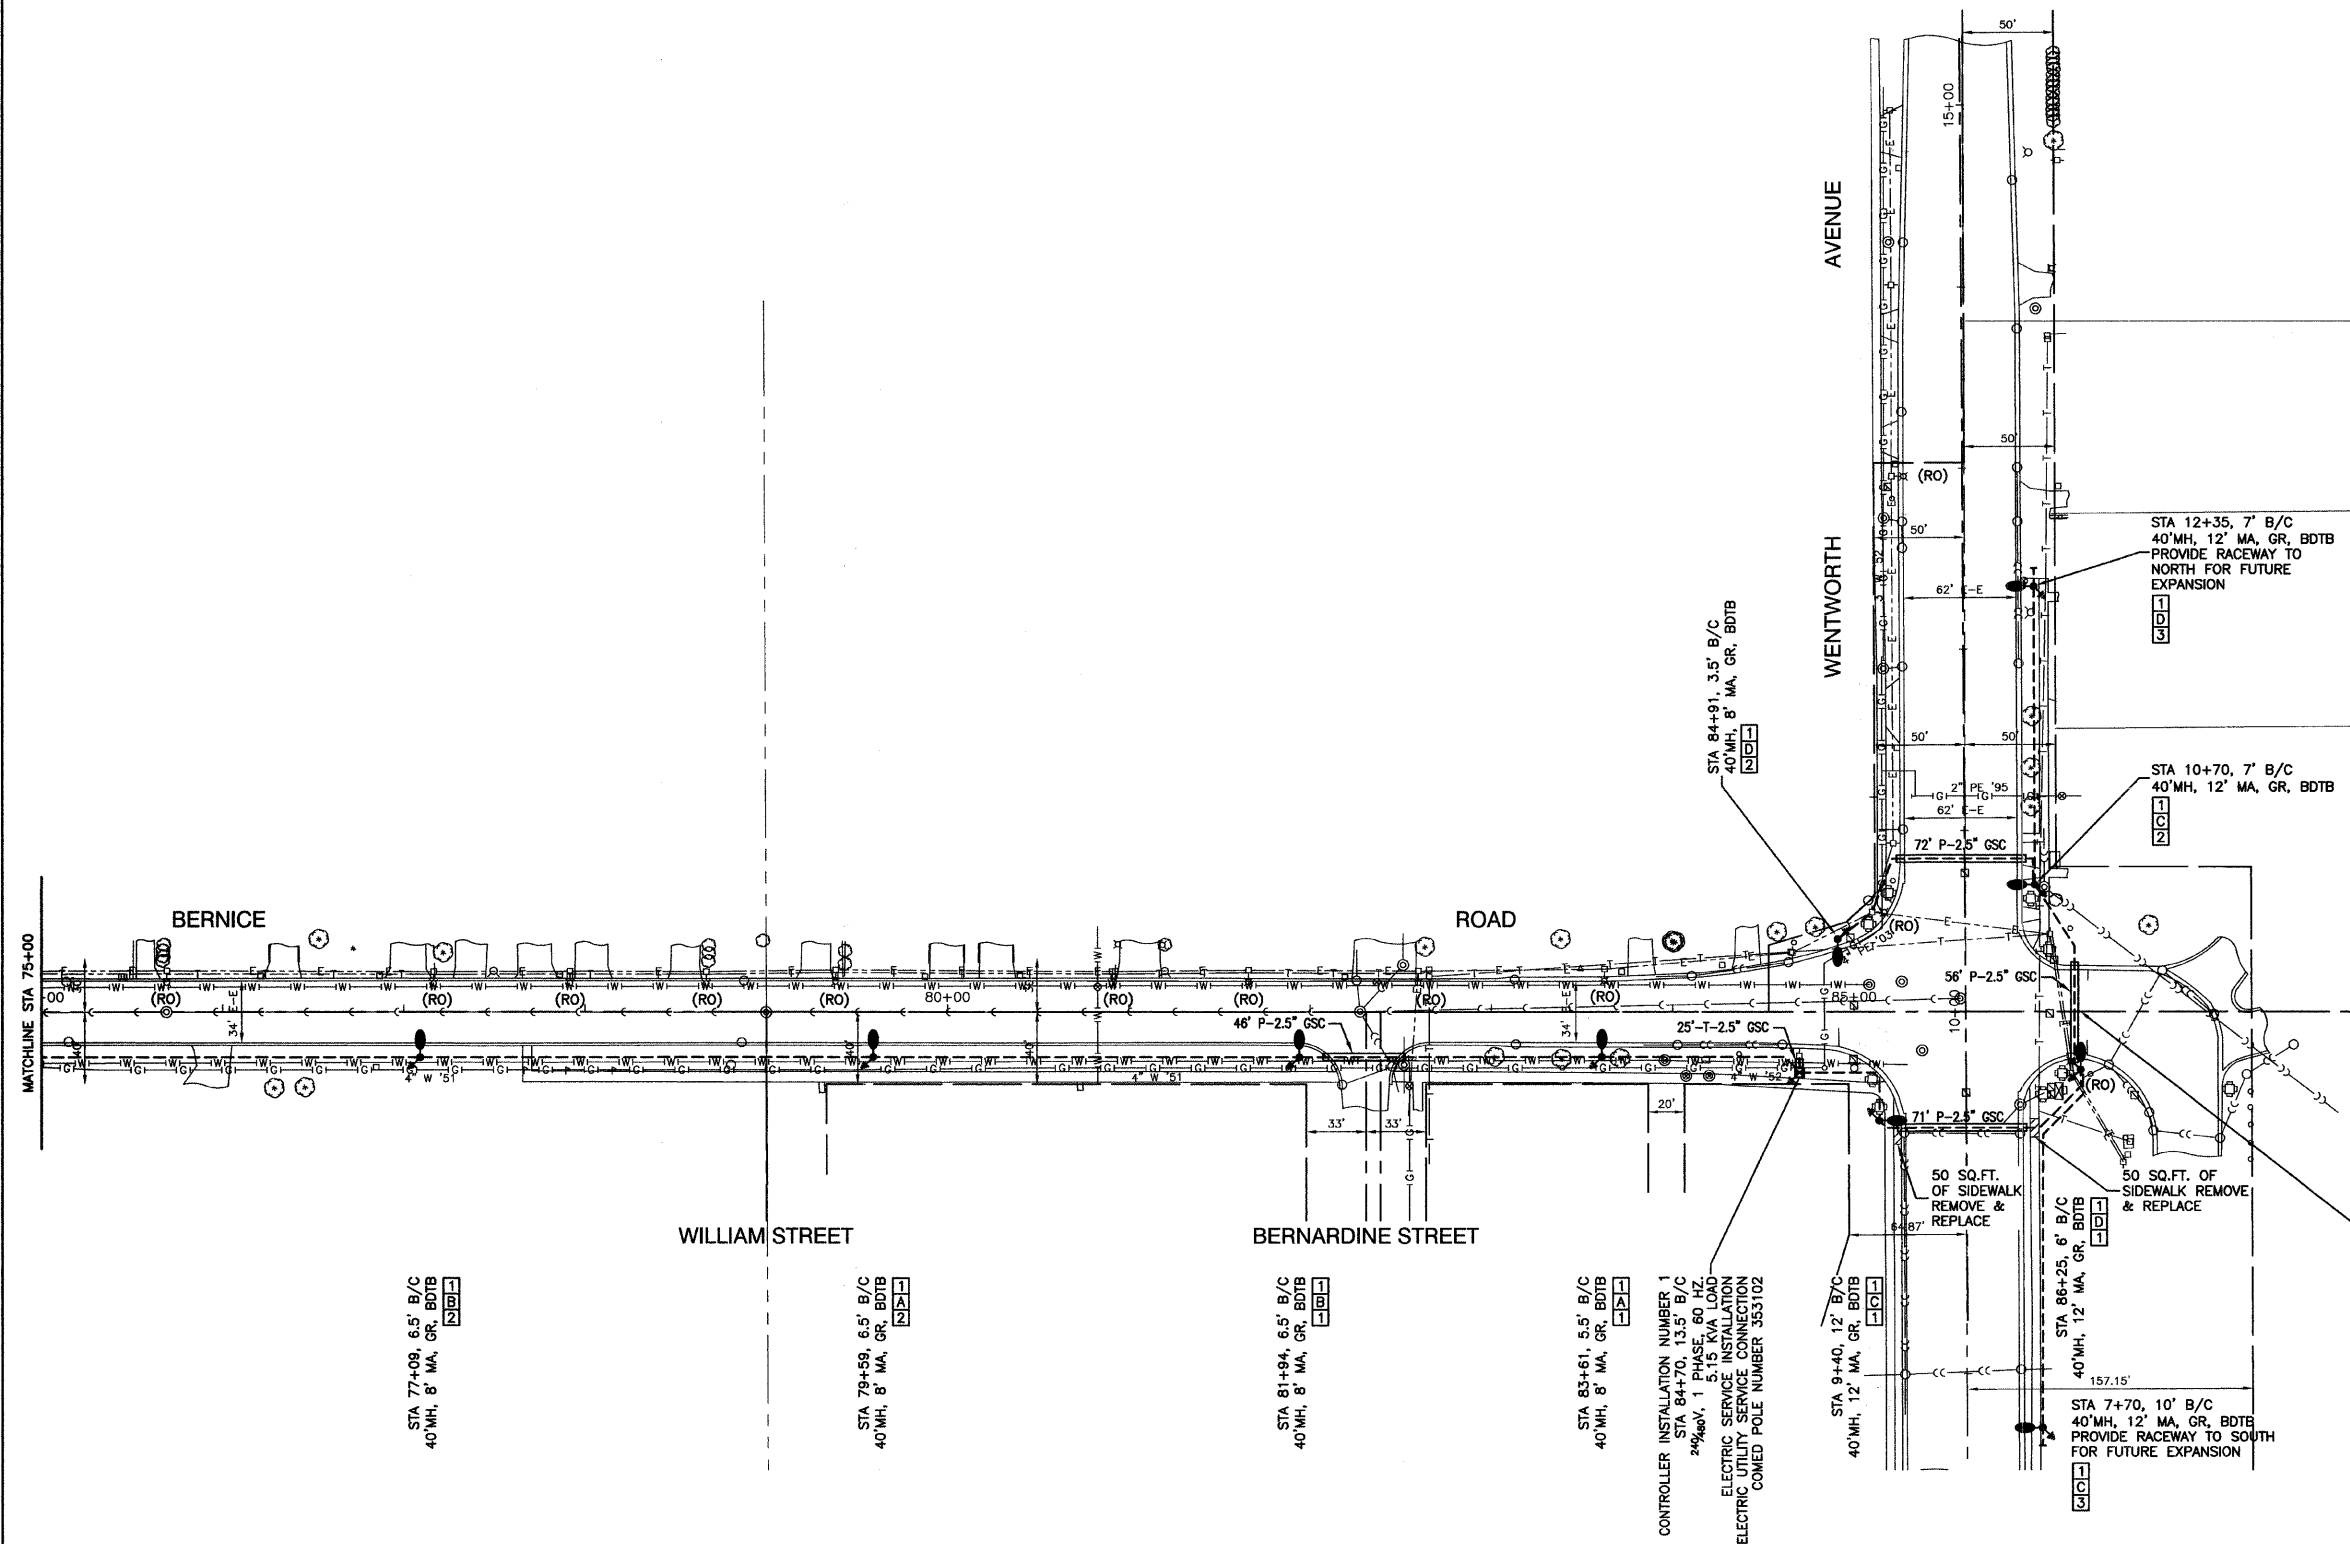

- LEGEND:**
- EXISTING STREET LIGHT
 - PROPOSED STREET LIGHT-250W HPS
 - PROPOSED CONTROLLER, CONSOLE TYPE
 - P — CONDUIT, PUSHED, GALVANIZED STEEL, SIZE AS NOTED
 - T — CONDUIT, TRENCHED, GALVANIZED STEEL, SIZE AS NOTED
 - U — UNIT DUCT, 600V, 3-1/C NO.4, 1/C NO.6 GROUND, (XLP-TYPE USE), 1-1/4" DIA., POLYETHYLENE
 - S — SERVICE WIRE, 3-1/C, NO. 1/0 AWG. (SEE LIGHTING CONTROLLER PLAN)
 - ⊗ GR GROUND ROD, 5/8" DIA. x 10'
 - (R) REMOVAL OF EXISTING STREET LIGHT
 - (RO) REMOVAL OF EXISTING STREET LIGHT (BY OTHERS)
 - MH MOUNTING HEIGHT
 - MA MAST ARM
 - B/C BACK OF CURB
 - BDTB BREAKAWAY DEVICE, TRANSFORMER BASE, 15" BOLT CIRCLE
 - R&R REMOVE AND REPLACE EXISTING STREET LIGHT

- POLE IDENTIFICATION**
- 1 CABINET NUMBER
 - 2 CIRCUIT
 - 3 POLE POSITION

END IMPROVEMENTS
STA 86+25



FILE NAME = 08321-PLAN-01 - IDOT P04	USER NAME =	DESIGNED — PAP	REVISIONS —	STATE OF ILLINOIS DEPARTMENT OF TRANSPORTATION	OAK AVE. TO WENTWORTH AVE. STREET LIGHTING STREET LIGHTING PLAN SHEETS		F.A.U. RTE. 1683	SECTION 09-00166-01-LT	COUNTY COOK	TOTAL SHEETS 12	SHEET NO. 6
PLOT SCALE = 1"=50'	CHECKED — EJT	REVISIONS —	SCALE: 1"=50'		SHEET NO. 6 OF 12 SHEETS	STA. 75+00 TO STA. 86+25	CONTRACT NO. 63285				
PLOT DATE = 10-19-09	DRAWN — MJD	REVISIONS —					FED. ROAD DIST. NO. 1 ILLINOIS		FED. AID PROJECT 9003(335)		
	CHECKED — DWS	REVISIONS —									