
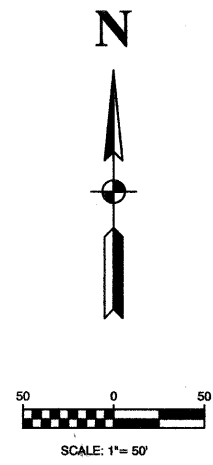


DATE	BY
REVISIONS	PLANNED
ALIGNED	CHECKED
NOTE BOOK	NO.
NO.	


DATE	BY
REVISIONS	PLANNED
GRADES	CHECKED
NOTE BOOK	NO.
NO.	

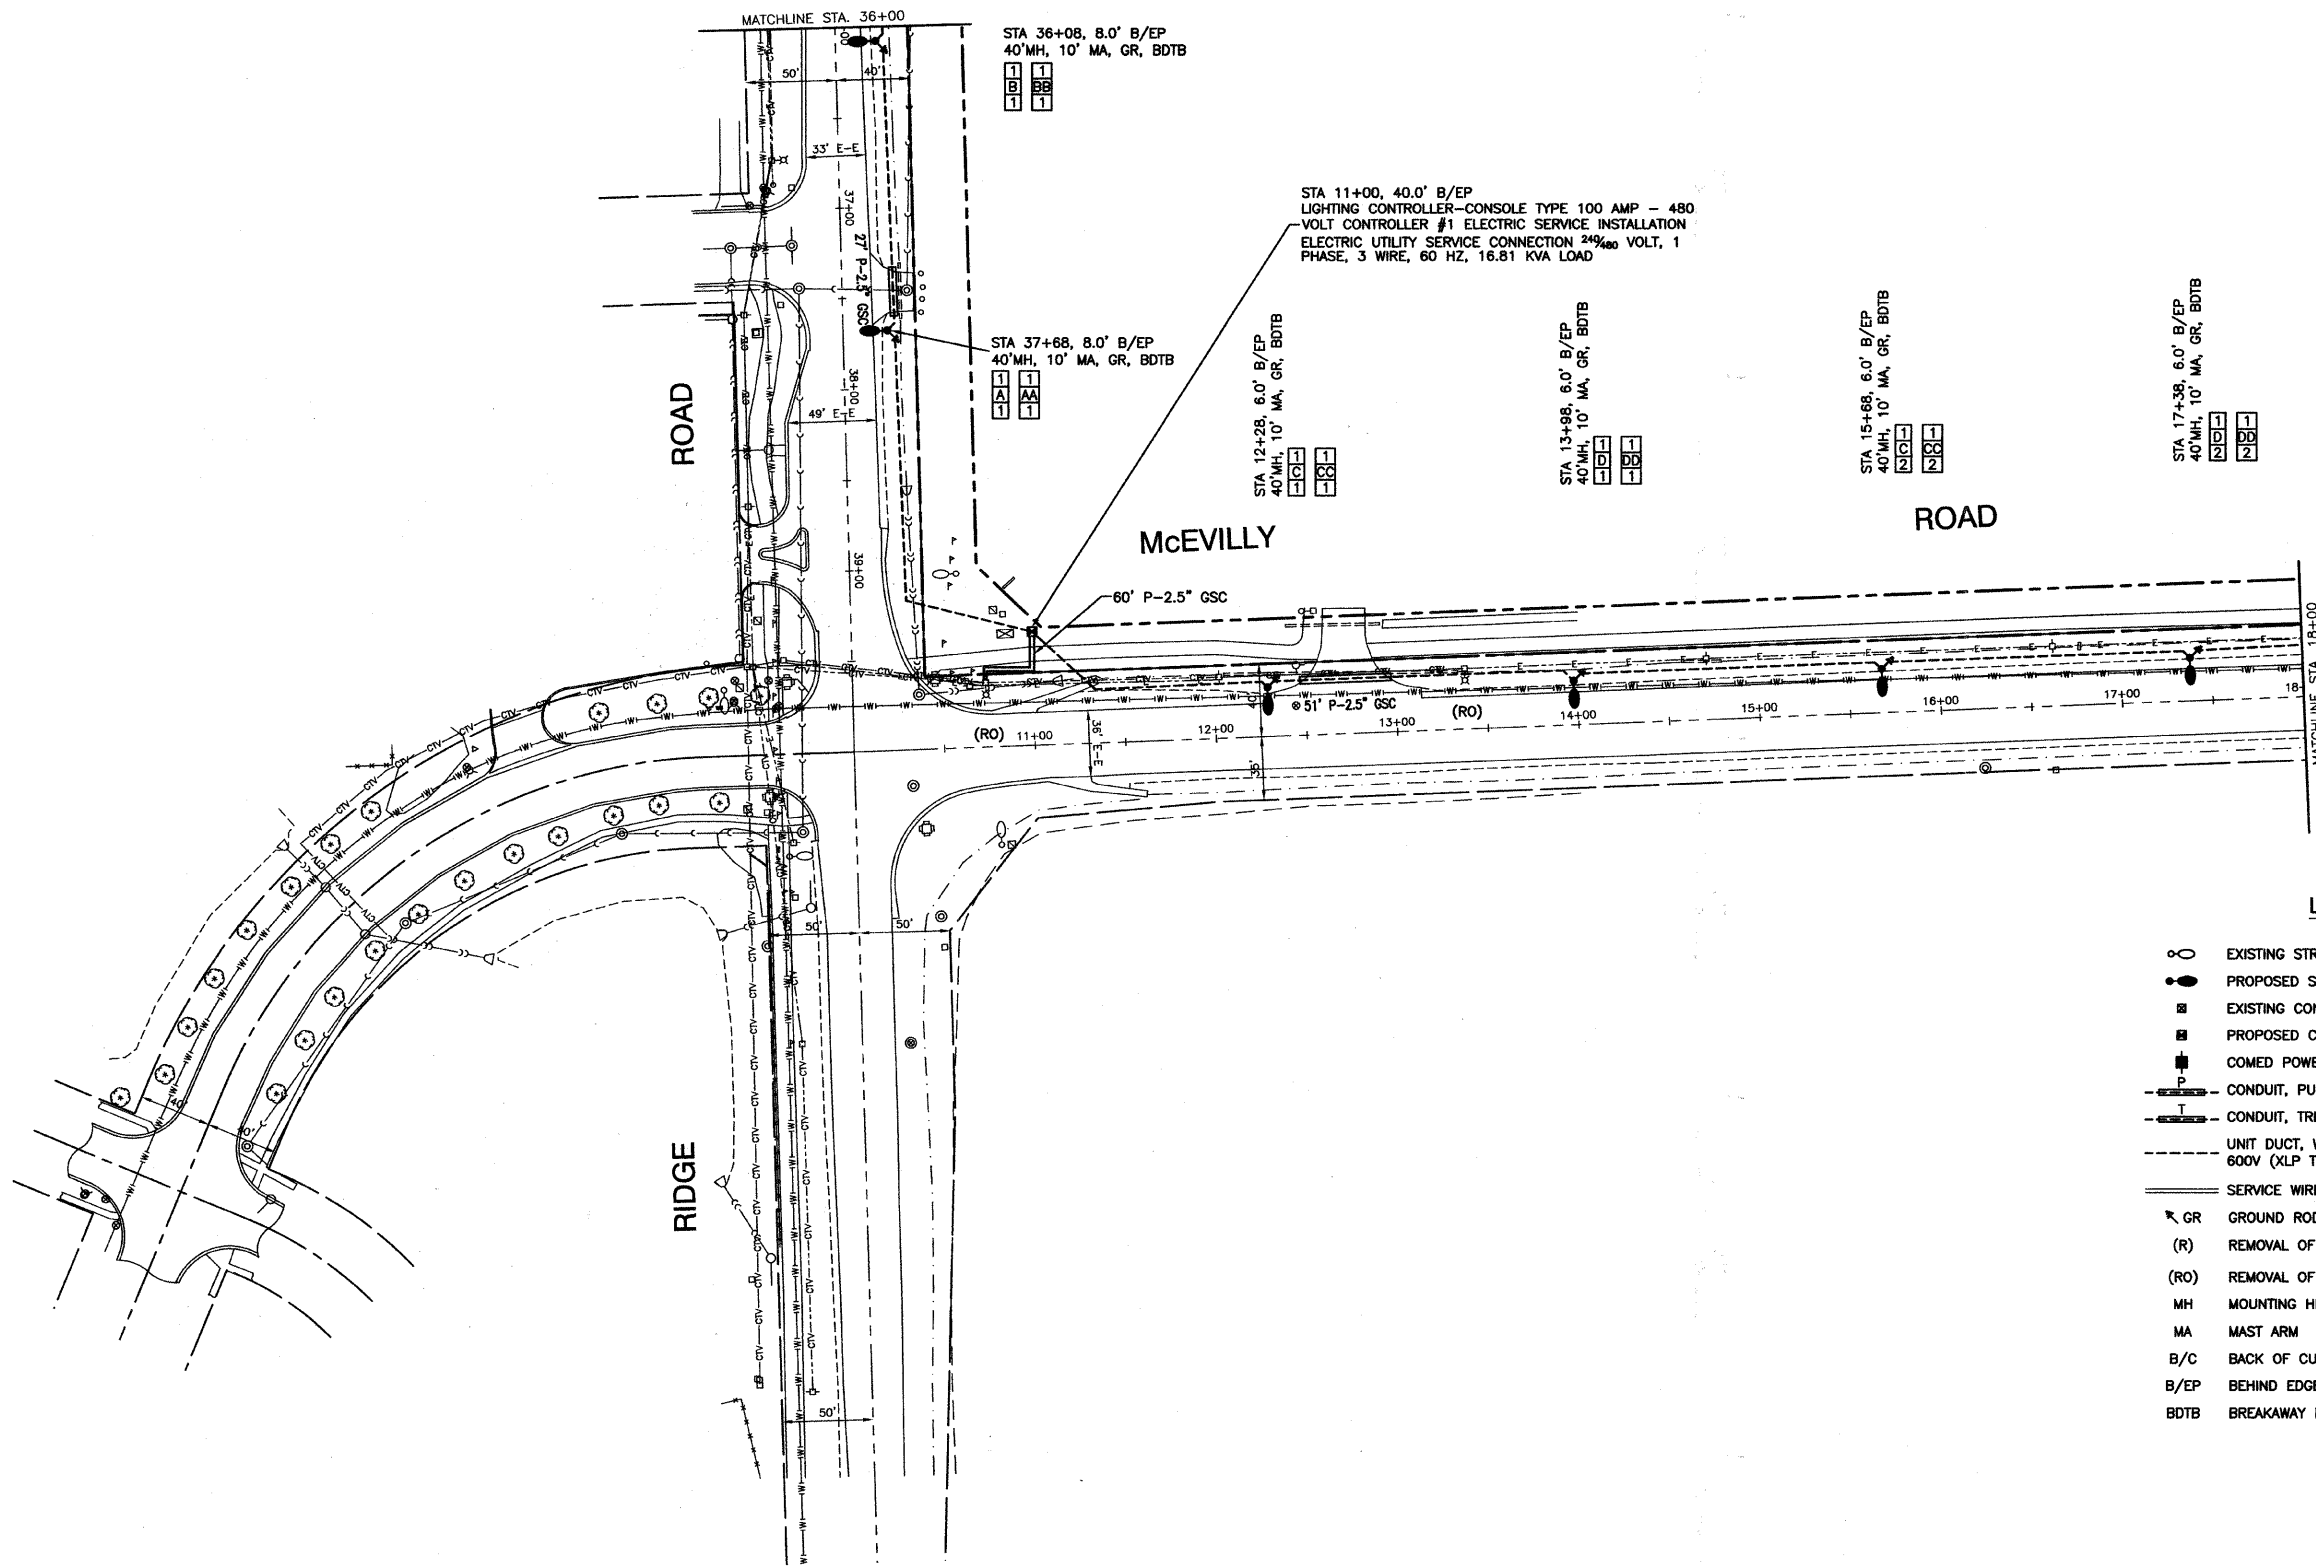

LEGEND:

- EXISTING STREET LIGHT-250W HPS
- PROPOSED STREET LIGHT-250W HPS
- EXISTING CONTROLLER
- PROPOSED CONTROLLER, CONSOLE TYPE
- COMED POWER POLE FOR SERVICE CONNECTION
- P — CONDUIT, PUSHED, GALVANIZED STEEL
- T — CONDUIT, TRENCHED, GALVANIZED STEEL
- U — UNIT DUCT, W/ 6-1/C, NO.4 AWG AND 1/C NO.6 GROUND, 600V (XLP TYPE USE) IN 1-1/2\"/>
- S — SERVICE WIRE, 3-1/C, NO. 1/0 AWG.
- GR GROUND ROD, 5/8\"/>
- (R) REMOVAL OF EXISTING STREET LIGHT (SALVAGE)
- (RO) REMOVAL OF EXISTING STREET LIGHT (BY OTHERS)
- MH MOUNTING HEIGHT
- MA MAST ARM
- B/C BACK OF CURB
- B/EP BEHIND EDGE OF PAVEMENT
- BDTB BREAKAWAY DEVICE, TRANSFORMER BASE, 11.5\"/>

 POLE IDENTIFICATION



FILE NAME = 09330-PLAN-01 - IDOT P02	USER NAME =	DESIGNED — DWS	REVISED —	STATE OF ILLINOIS DEPARTMENT OF TRANSPORTATION	RIDGE ROAD & MCEVILLY ROAD STREET LIGHTING PLAN SHEET				F.A.U. RTE.	SECTION	COUNTY	TOTAL SHEETS	SHEET NO.
	PLOT SCALE = 1"=50'	CHECKED — PAP	REVISED —		0393	09-00054-00-LT	GRUNDY	11	3				
	PLOT DATE = 10-21-09	DRAWN — RG/KWM/MJD	REVISED —		SCALE: 1"=50' SHEET NO. 3 OF 11 SHEETS STA. 10+00 TO STA. 18+00				CONTRACT NO. 87438				
		CHECKED — PAP	REVISED —		FED. ROAD DIST. NO. 3 ILLINOIS FED. AID PROJECT ARA-003 (341)								