 




DATE	
BY	
PLAN	
SURVEYED	
PLOTTED	
ALIGNED	
CHECKED	
NO. / DATE	
NOTE BOOK	
NO.	
FILE NAME	

DATE	
BY	
PROFILE	
SURVEYED	
PLOTTED	
GRADES	
CHECKED	
NO. / DATE	
NOTE BOOK	
NO.	
FILE NAME	

FILE NAME = D:\6011001\106X-B.dgn
 MODEL = 106X-B.dwg
 PLOT DRIVER = V8i_PDF_11x17.plt

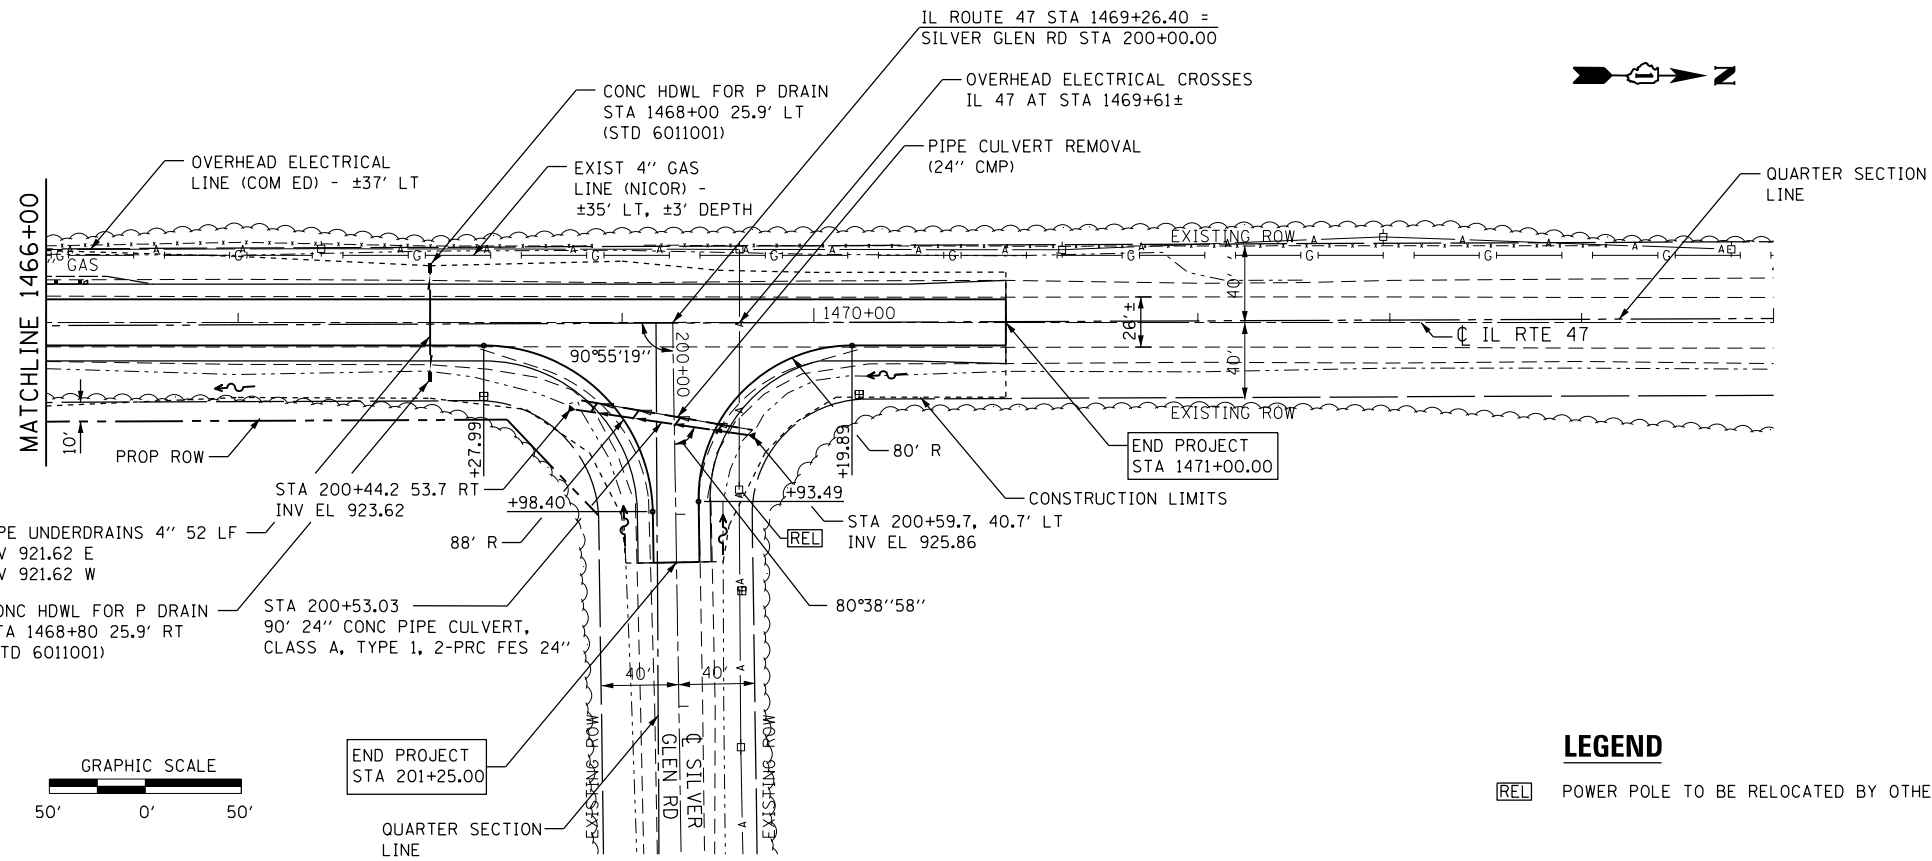

LEGEND
 [REL] POWER POLE TO BE RELOCATED BY OTHERS

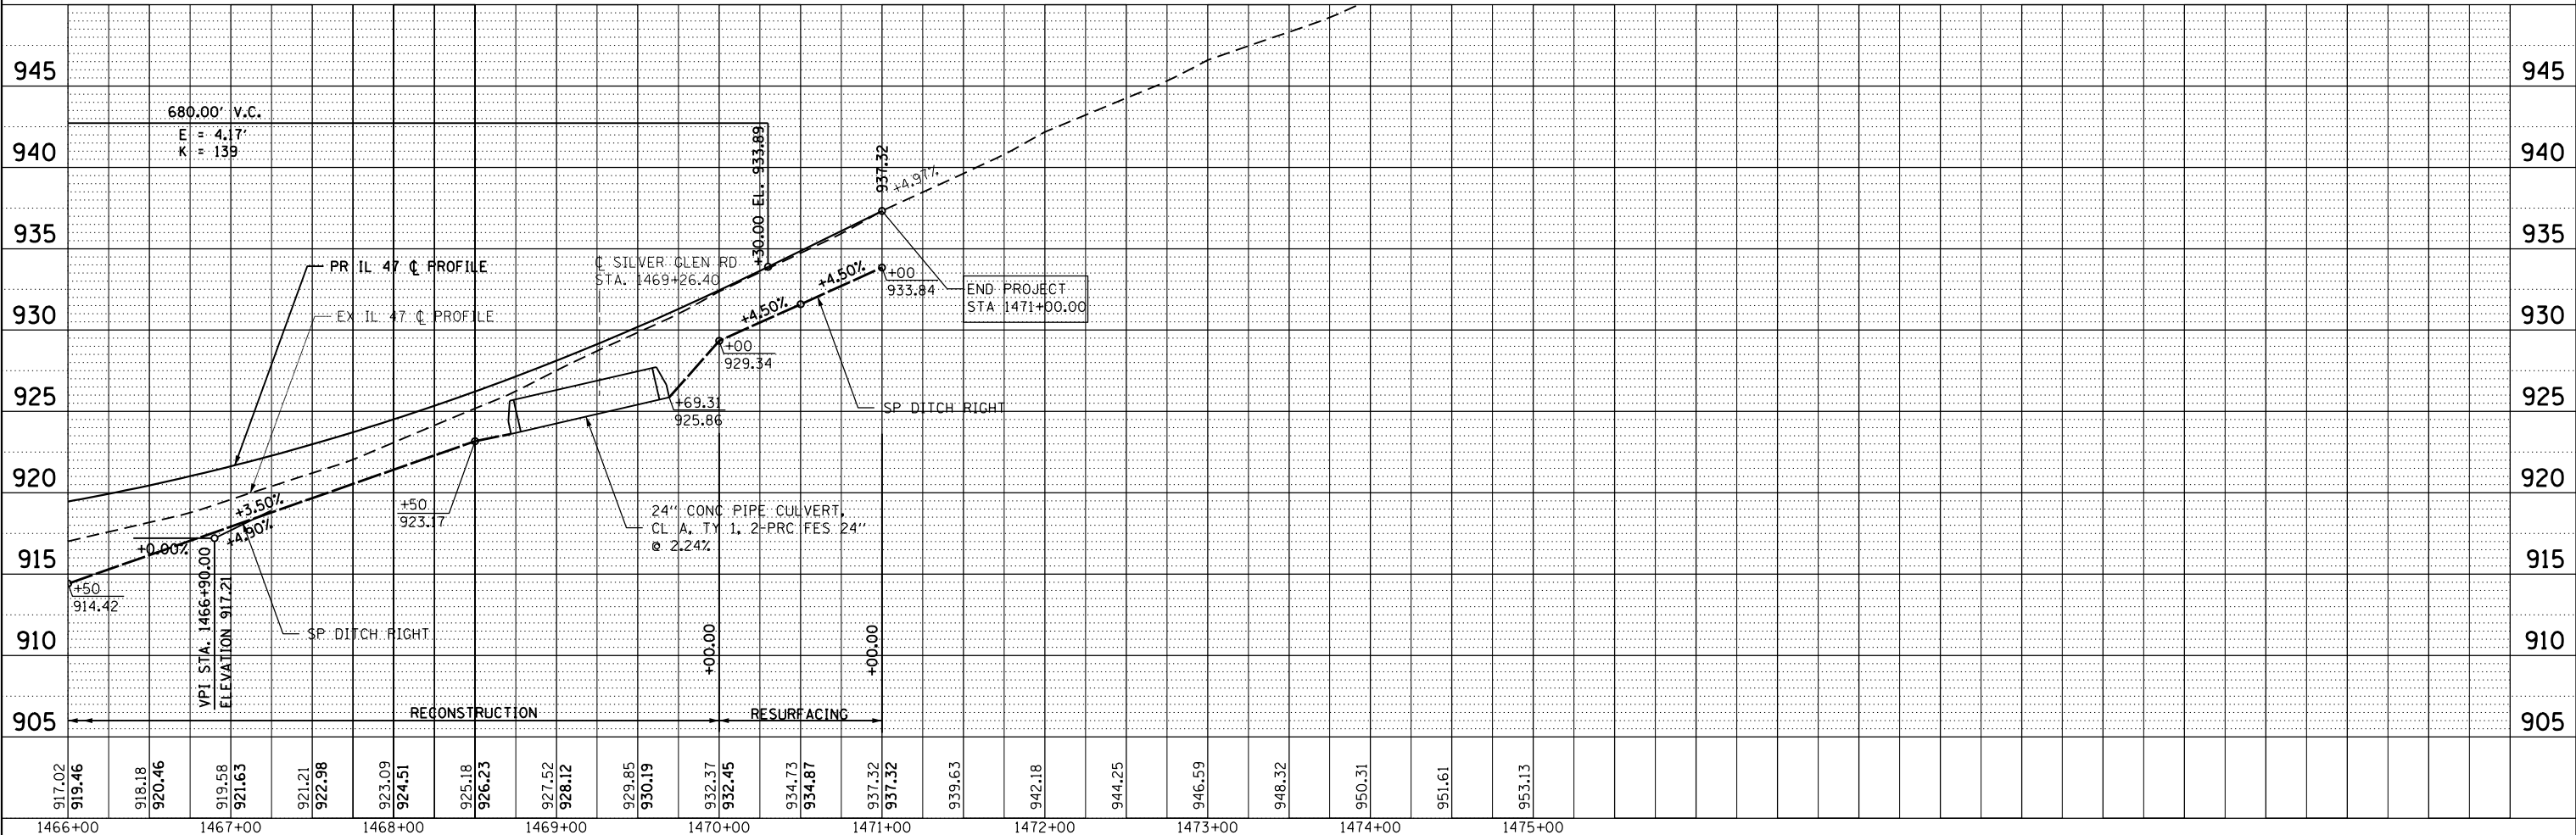

USER NAME = mmann
 DESIGNED - MCV
 DRAWN - CMM
 CHECKED - MTM
 DATE - 10/12

REVISOR -
 REVISION -
 REVISION -
 REVISION -

STATE OF ILLINOIS
 DEPARTMENT OF TRANSPORTATION

IL ROUTE 47 OVER VIRGIL DITCH #2
 DRAINAGE AND UTILITY PLAN

SCALE: 1"=50' SHEET NO. 2 OF 3 SHEETS STA. 1466+00 TO STA. 1474+00

F.A.P. RTE.	SECTION	COUNTY	TOTAL SHEETS	SHEET NO.
326	106X-B	KANE	87	27
CONTRACT NO. 60N13				
ILLINOIS FED. AID PROJECT				