


MAINTENANCE OF TRAFFIC LEGEND

	WORK AREA		TRAFFIC DIRECTION		ARROW BOARD		PVT MK - LINE 4" WHITE		PVT MK - LINE 24" WHITE
	TEMPORARY PAVEMENT (TO BE CONSTRUCTED IN CURRENT STAGE)		BARRICADE, TYPE III, W/ TYPE A BI-DIRECTIONAL FLASHING LIGHT		DOUBLE VERTICAL PANEL		PVT MK - LINE 4" YELLOW		PVT MK - LINE 8" WHITE
			TYPE II BARRICADES OR DRUMS W/ TYPE C STEADY BURN LIGHT		PROPOSED SIGN		PVT MK - DBL 4" YELLOW		TEMP PVT MK (SEE GENERAL NOTES SHT G-03)
			TYPE B MONO-DIRECTIONAL FLASHING LIGHT		TEMPORARY CONCRETE BARRIER		PVT MK - LINE 6" WHITE		WET REF TEM TAPE T3 (SEE GENERAL NOTES SHT G-03)
			RAMP CLOSED		RAMP CLOSED		PVT MK - LINE 12"		PERM PVT MK (SEE PVT MK PLANS)

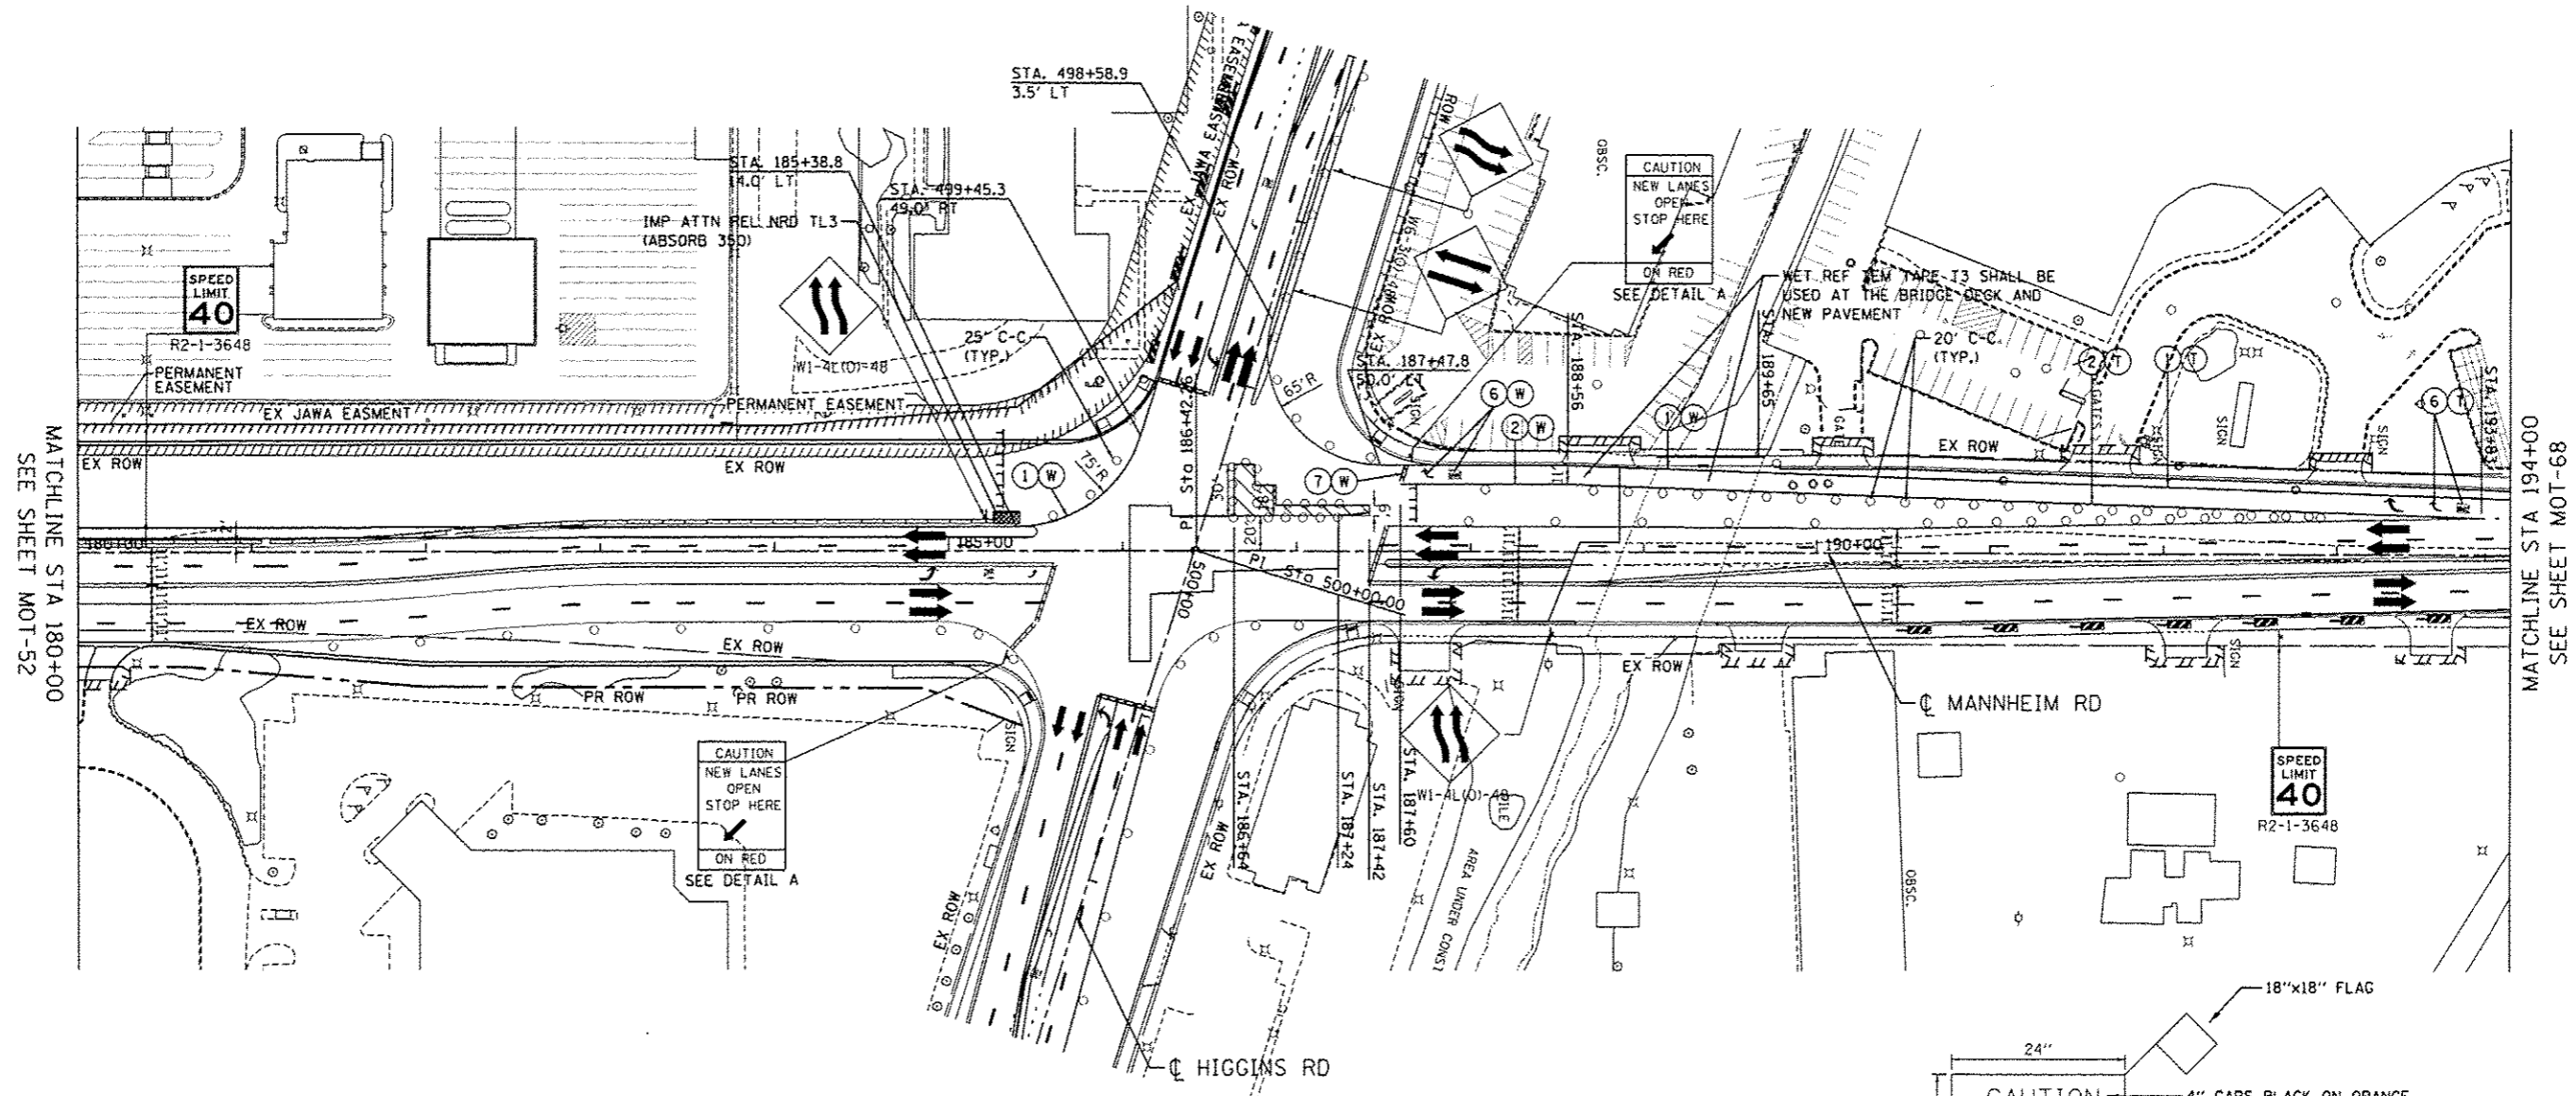


MATCHLINE STA 180+00
SEE SHEET MOT-52

MATCHLINE STA 194+00
SEE SHEET MOT-68

NOTE:

- SIDEROAD, INTERSECTION, AND DRIVEWAY TRAFFIC CONTROL SHALL BE IN ACCORDANCE WITH DISTRICT DETAIL TC-10.

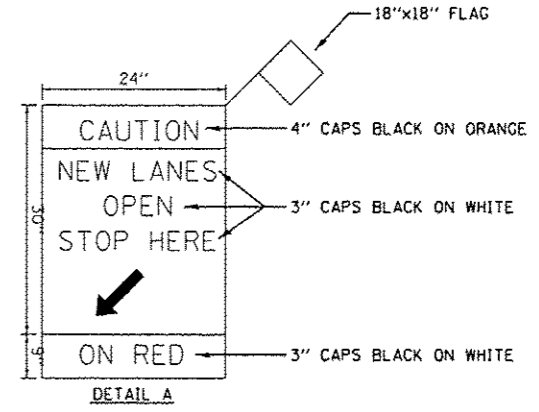

FILE NAME = F:\DDC\EXP\DOT\2002\2584\B2\CDP\ON\PSST\TEMP\SHR\PLT\010625-SHT-ST102\MOCC.B.DWG
 XREF: 11/15/02
 12-22-2012, 10:01:26

TENG & ASSOCIATES, INC. ENGINEERS/ARCHITECTS/PLANNERS CHICAGO, ILLINOIS	USER NAME = #USER# DESIGNED - BRH DRAWN - JZP CHECKED - KDA DATE - 10/19/12	REVISED - REVISED - REVISED - REVISED -	STATE OF ILLINOIS DEPARTMENT OF TRANSPORTATION		MAINTENANCE OF TRAFFIC STAGE 2 - SUB-STAGE C		F.A. RTE. SECTION COUNTY CONTRACT NO. 60P35	TOTAL SHEET NO. SHEET NO. 148 ILLINOIS FED. AID PROJECT
	PLOT SCALE = #SCALE# PLOT DATE = #DATE#	DATE - 10/19/12	SCALE: 1"=50' SHEET NO. OF SHEETS STA. 180+00 TO STA. 194+00					

MOT-67