


| | |
|---------------|--|
| DATE | |
| BY | |
| DESIGNED | |
| ROUTED | |
| ALIGNED | |
| CHECKED | |
| NO. | |
| NOTE BOOK | |
| ADD FILE NAME | |


| | |
|---------------|--|
| DATE | |
| BY | |
| DESIGNED | |
| ROUTED | |
| ALIGNED | |
| CHECKED | |
| NO. | |
| NOTE BOOK | |
| ADD FILE NAME | |

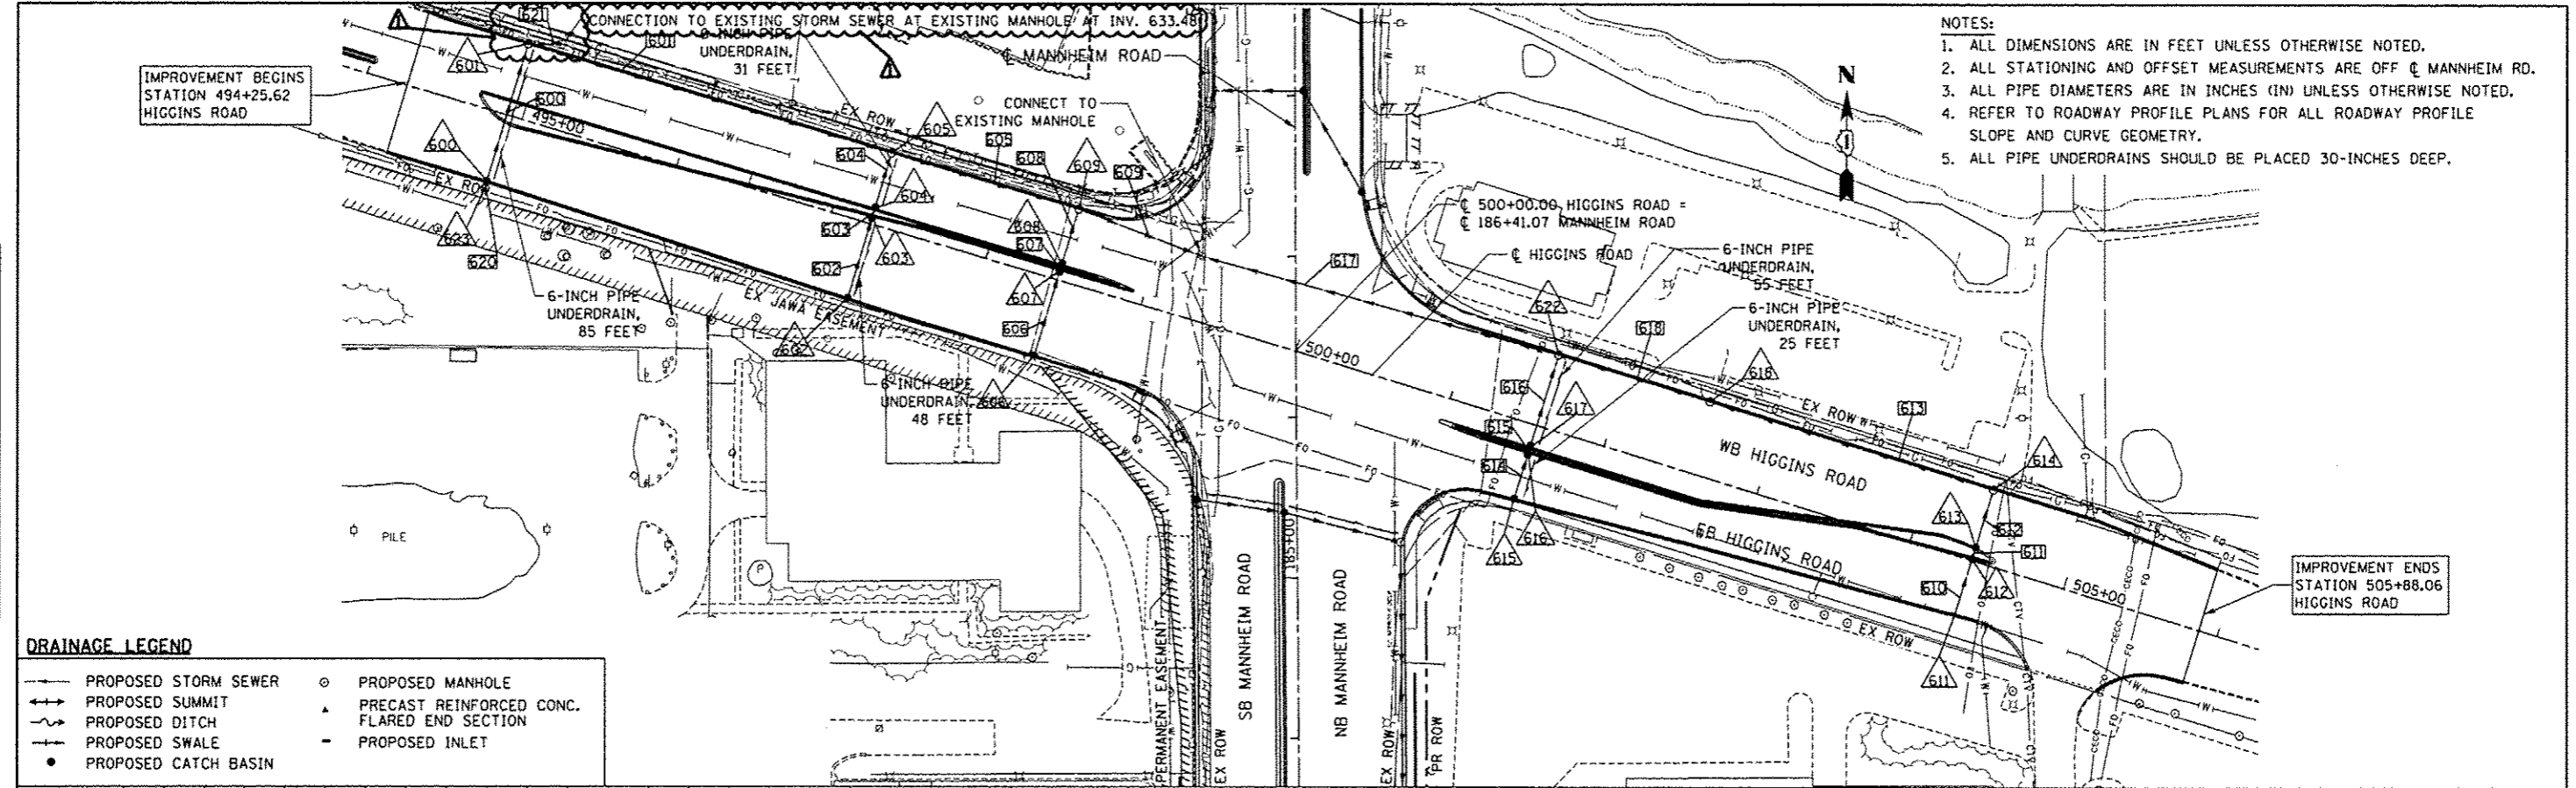

- NOTES:
1. ALL DIMENSIONS ARE IN FEET UNLESS OTHERWISE NOTED.
 2. ALL STATIONING AND OFFSET MEASUREMENTS ARE OFF C MANNHEIM RD.
 3. ALL PIPE DIAMETERS ARE IN INCHES (IN) UNLESS OTHERWISE NOTED.
 4. REFER TO ROADWAY PROFILE PLANS FOR ALL ROADWAY PROFILE SLOPE AND CURVE GEOMETRY.
 5. ALL PIPE UNDERDRAINS SHOULD BE PLACED 30-INCHES DEEP.

DRAINAGE LEGEND

- PROPOSED STORM SEWER
- PROPOSED SUMMIT
- PROPOSED DITCH
- PROPOSED SWALE
- PROPOSED CATCH BASIN
- PROPOSED MANHOLE
- PRECAST REINFORCED CONC. FLARED END SECTION
- PROPOSED INLET

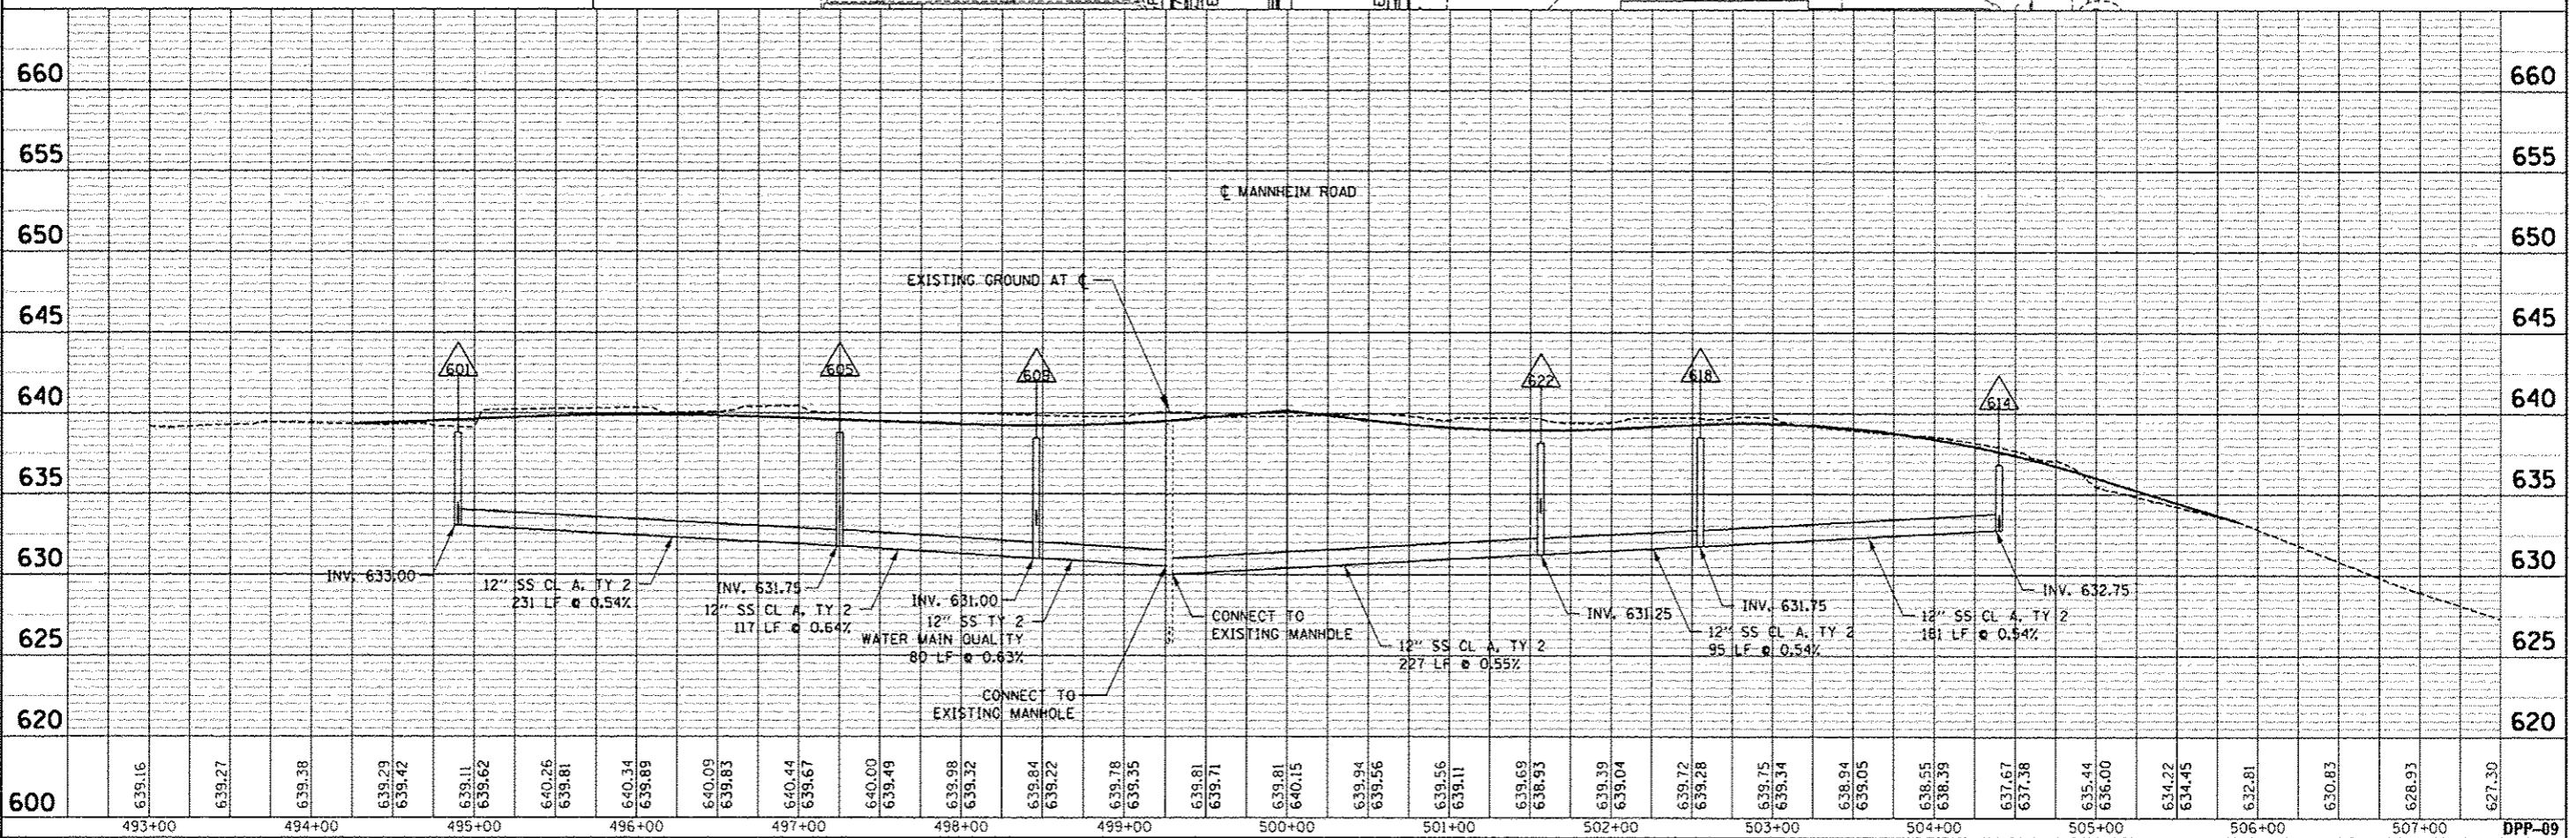

| | | | | | | | | | | | | | | | |
|----------------------|--------------------|-----------------|--------------------------|---|--|--|--|--|--|--------------------|---------|--------------|--------------|-----------------------------|--|
| FILE NAME : | USER NAME : #USER# | DESIGNED - TKL | REVISED - 12/27/2012 HDU | STATE OF ILLINOIS DEPARTMENT OF TRANSPORTATION | | | | PROPOSED DRAINAGE HIGGINS ROAD PLAN AND PROFILE | | F.A. RTE. | SECTION | COUNTY | TOTAL SHEETS | SHEET NO. | |
| #FILE# | | DRAWN - KC | REVISED - | | | | | | | 0105-WRS | COOK | 517 | 186 | | |
| PLOT SCALE : #SCALE# | | CHECKED - MCD | REVISED - | | | | | | | CONTRACT NO. 60P35 | | | | | |
| PLOT DATE : #DATE# | | DATE - 10/19/12 | REVISED - | | | | | SCALE: HORIZ. 1"=50' | | VERT. 1"=5' | | STA. TO STA. | | [ILLINOIS] FED. AID PROJECT | |

12-27-2012 REVISIONS
 F:\A002\CH2120212012\01-DESIGN\DRAINAGE\PLANS\DRAINAGE\0105-WRS.DWG

