



PLAN	SURVEYED	DATE
	PLOTTED	BY
	GRADES CHECKED	
	STRUCTURE NOTATIONS CHECKED	
	NOTE BOOK NO.	
	CARD FILE NAME	

PROFILE	SURVEYED	DATE
	PLOTTED	BY
	GRADES CHECKED	
	STRUCTURE NOTATIONS CHECKED	
	NOTE BOOK NO.	
	CARD FILE NAME	

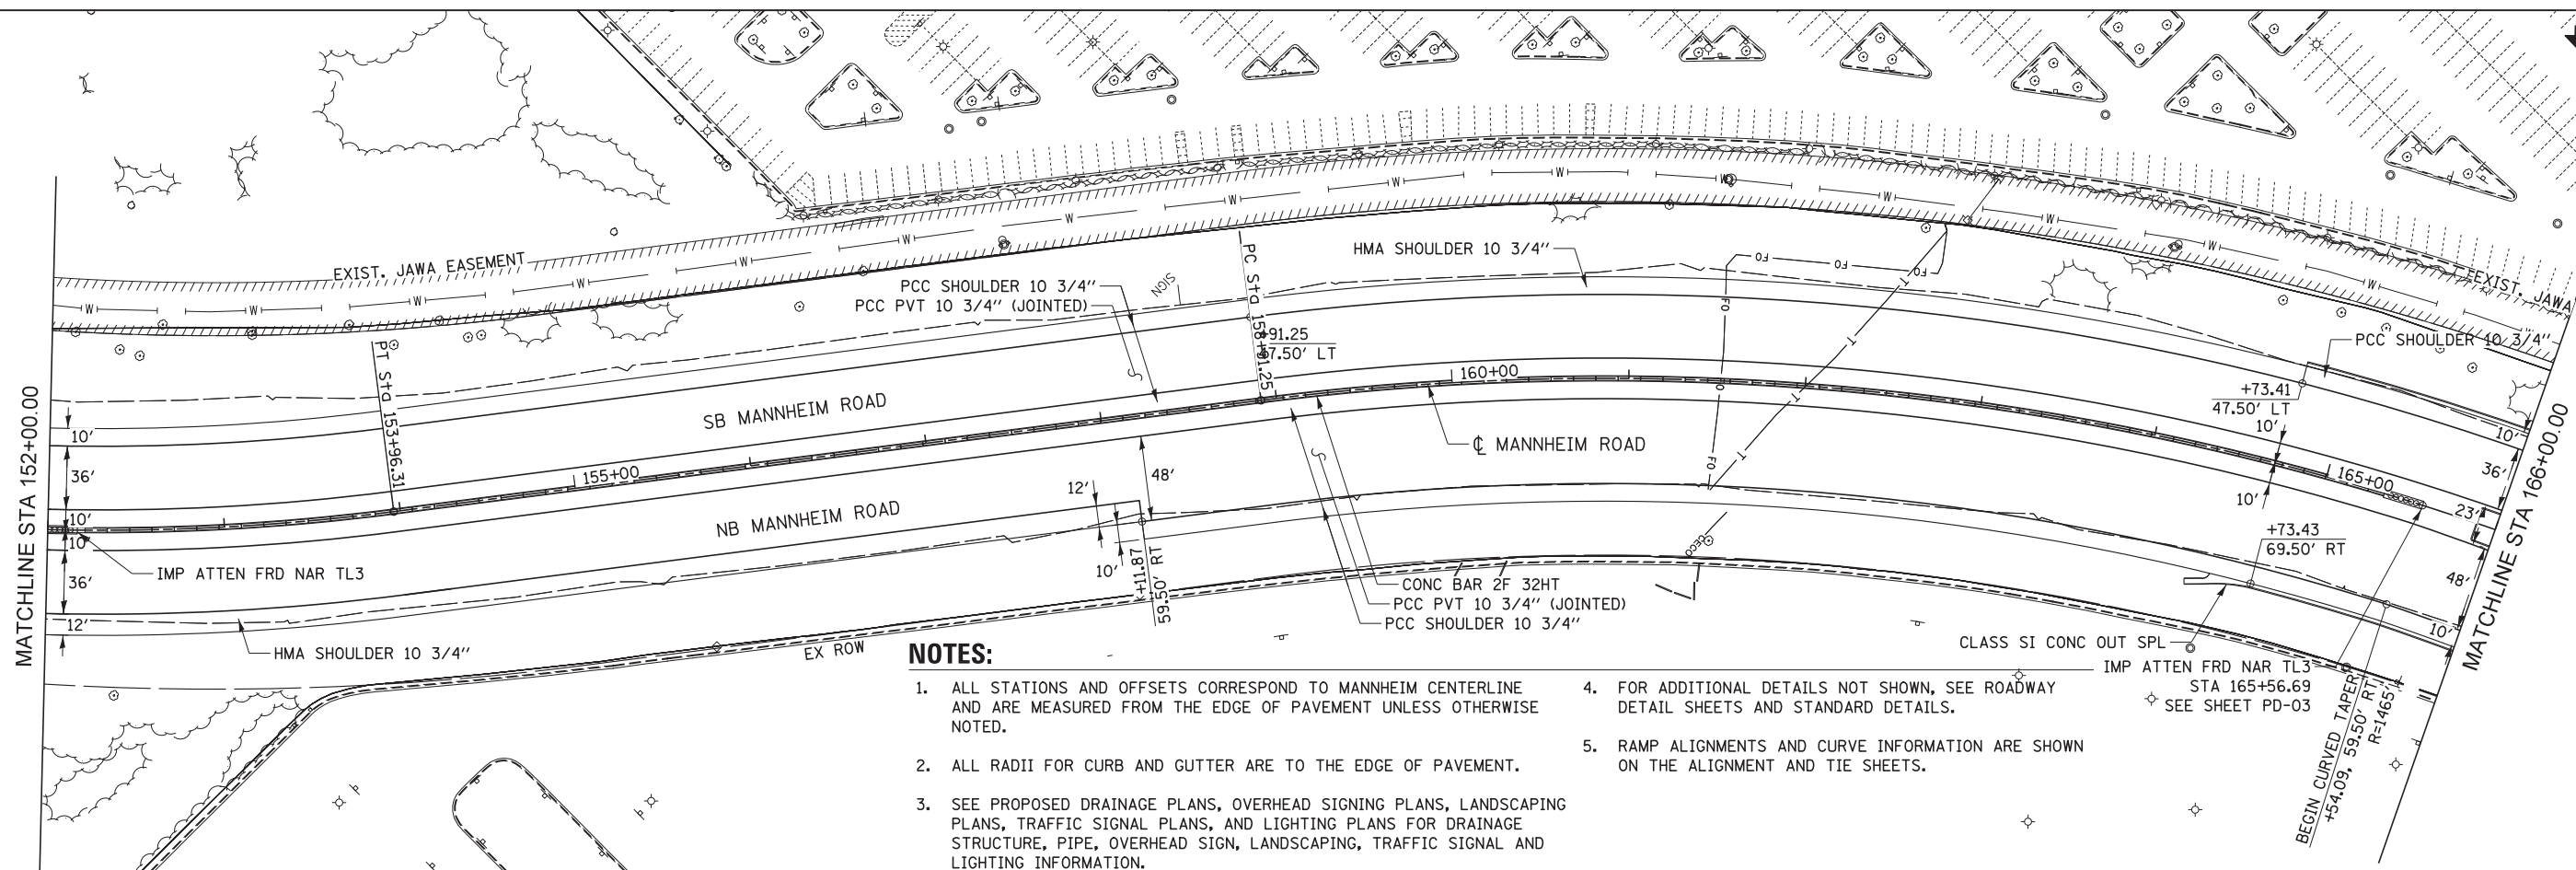

NOTES:

1. ALL STATIONS AND OFFSETS CORRESPOND TO MANNHEIM CENTERLINE AND ARE MEASURED FROM THE EDGE OF PAVEMENT UNLESS OTHERWISE NOTED.
2. ALL RADII FOR CURB AND GUTTER ARE TO THE EDGE OF PAVEMENT.
3. SEE PROPOSED DRAINAGE PLANS, OVERHEAD SIGNING PLANS, LANDSCAPING PLANS, TRAFFIC SIGNAL PLANS, AND LIGHTING PLANS FOR DRAINAGE STRUCTURE, PIPE, OVERHEAD SIGN, LANDSCAPING, TRAFFIC SIGNAL AND LIGHTING INFORMATION.
4. FOR ADDITIONAL DETAILS NOT SHOWN, SEE ROADWAY DETAIL SHEETS AND STANDARD DETAILS.
5. RAMP ALIGNMENTS AND CURVE INFORMATION ARE SHOWN ON THE ALIGNMENT AND TIE SHEETS.

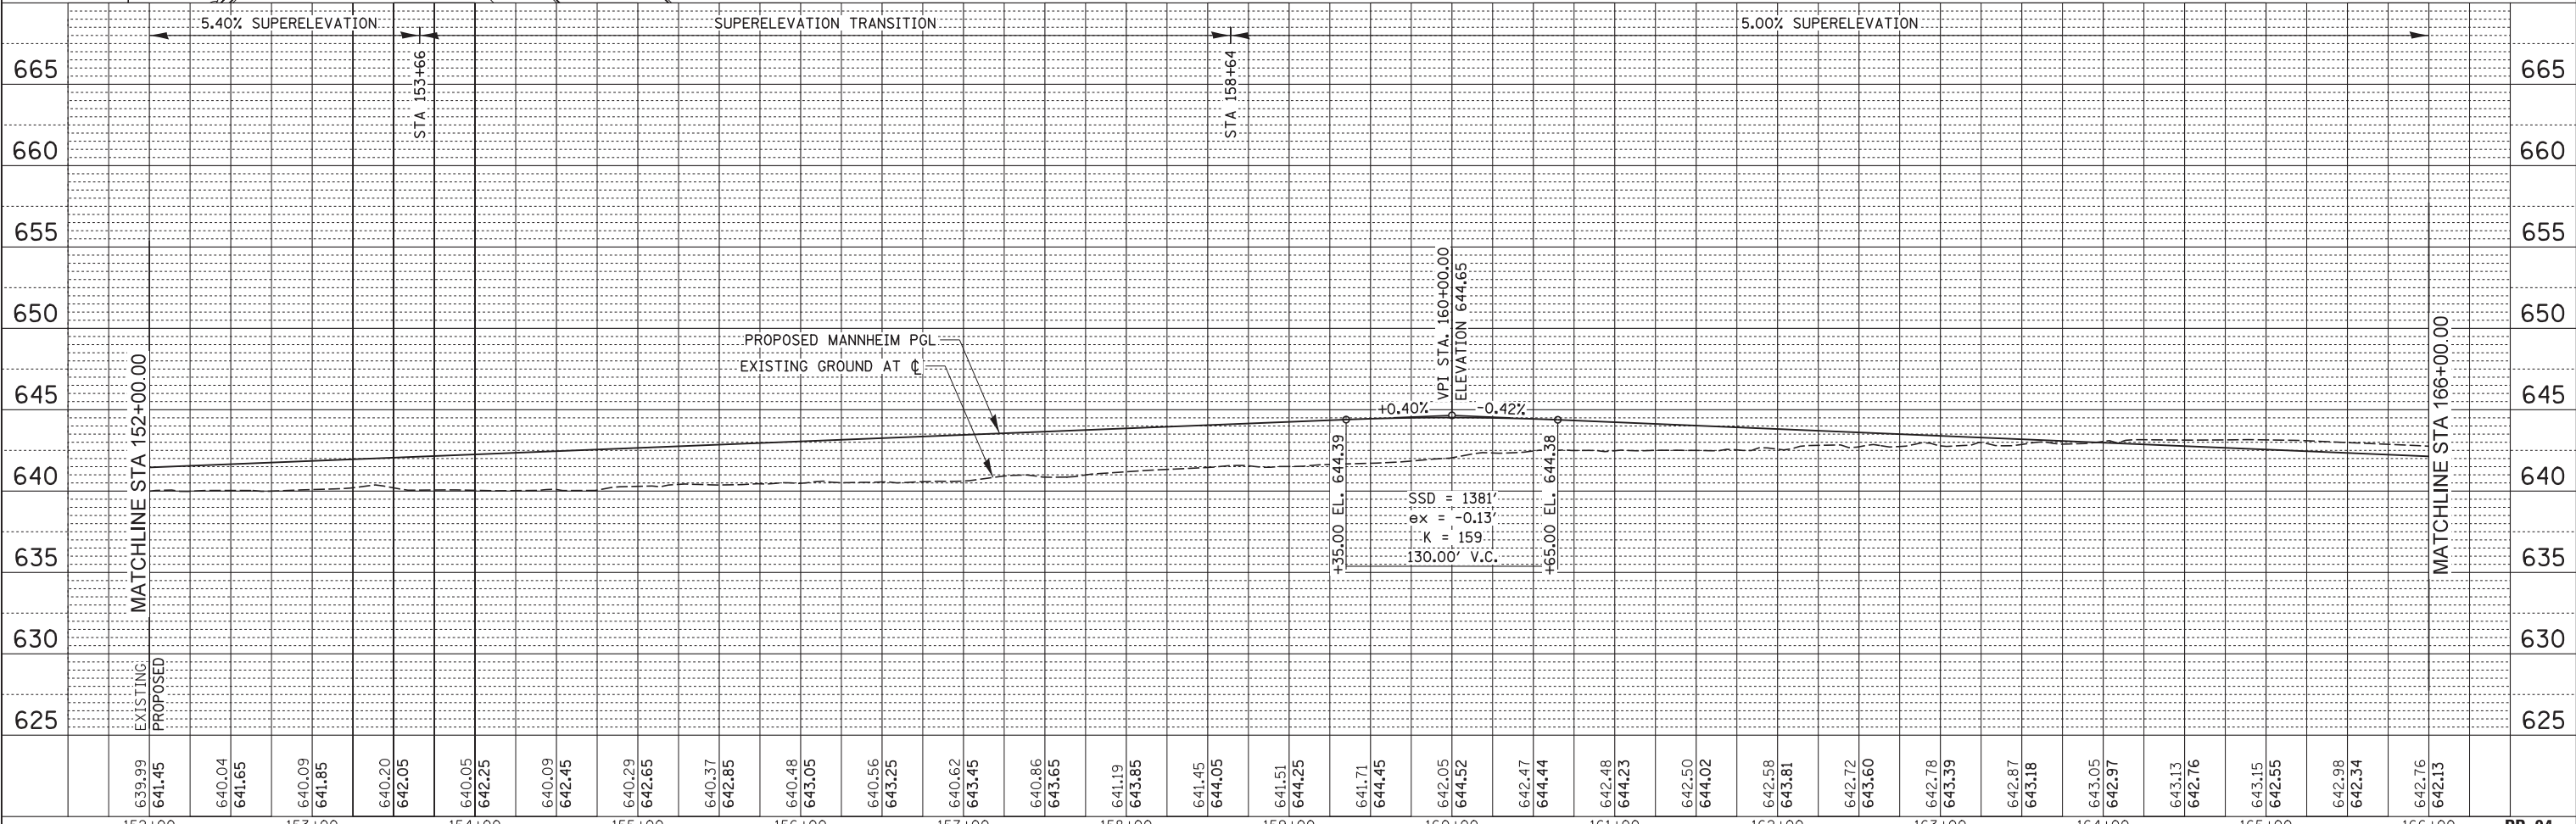

	USER NAME = mkosir	DESIGNED LLS/MMK	REVISED -	<p align="center">STATE OF ILLINOIS DEPARTMENT OF TRANSPORTATION</p> <p align="center">PLAN AND PROFILE MANNHEIM ROAD</p>	F.A.P. 330	SECTION 0105-WRS	COUNTY COOK	TOTAL SHEETS 537	SHEET NO. 63	
	PLOT SCALE = 50:1	CHECKED LLS	REVISED -		SCALE: 1" = 50'	SHEET NO. 4 OF 10 SHEETS	STA. 152+00.00 TO STA. 166+00.00	CONTRACT NO. 60P35		
	PLOT DATE = 23-OCT-2012	DATE 10/19/12	REVISED -		ILLINOIS FED. AID PROJECT					
	<p align="right">PP-04</p>									