
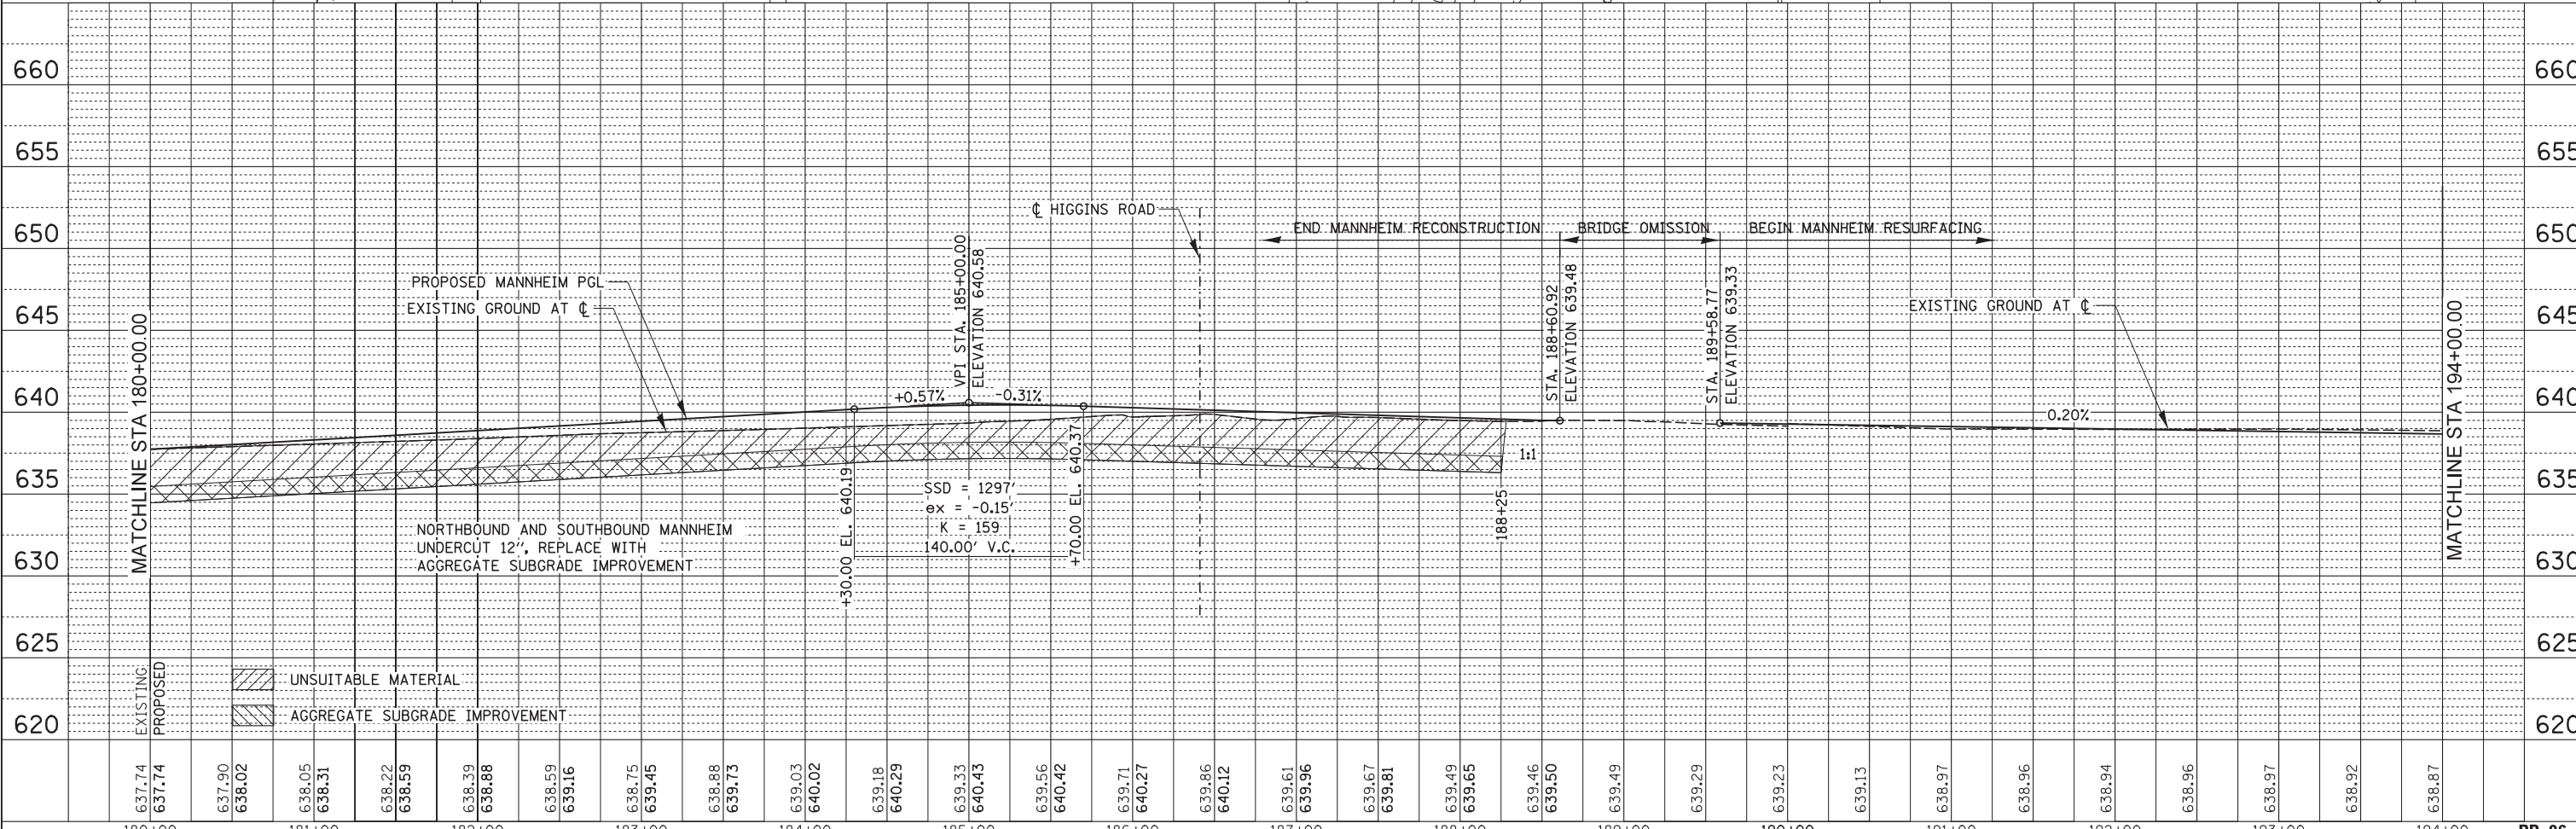


NOTES:

- ALL STATIONS AND OFFSETS CORRESPOND TO MANNHEIM CENTERLINE AND ARE MEASURED FROM THE EDGE OF PAVEMENT UNLESS OTHERWISE NOTED.
- ALL RADII FOR CURB AND GUTTER ARE TO THE EDGE OF PAVEMENT.
- SEE PROPOSED DRAINAGE PLANS, OVERHEAD SIGNING PLANS, LANDSCAPING PLANS, TRAFFIC SIGNAL PLANS, AND LIGHTING PLANS FOR DRAINAGE STRUCTURE, PIPE, OVERHEAD SIGN, LANDSCAPING, TRAFFIC SIGNAL AND LIGHTING INFORMATION.
- FOR ADDITIONAL DETAILS NOT SHOWN, SEE ROADWAY DETAIL SHEETS AND STANDARD DETAILS.
- RAMP ALIGNMENTS AND CURVE INFORMATION ARE SHOWN ON THE ALIGNMENT AND TIE SHEETS.
- CONTRACTOR TO VERIFY LOCATION OF EXISTING CONCRETE THRUST BLOCK AND SHEET PILING AT EXISTING NSMJAWA 90" WATER MAIN.

PLAN	SURVEYED	DATE
	PLOTTED	
	GRADES CHECKED	
	STRUCTURE NOTATIONS CHECKED	
	NOTE BOOK NO.	
	CARD FILE NAME	

PROFILE	SURVEYED	DATE
	PLOTTED	
	GRADES CHECKED	
	STRUCTURE NOTATIONS CHECKED	
	NOTE BOOK NO.	
	CARD FILE NAME	

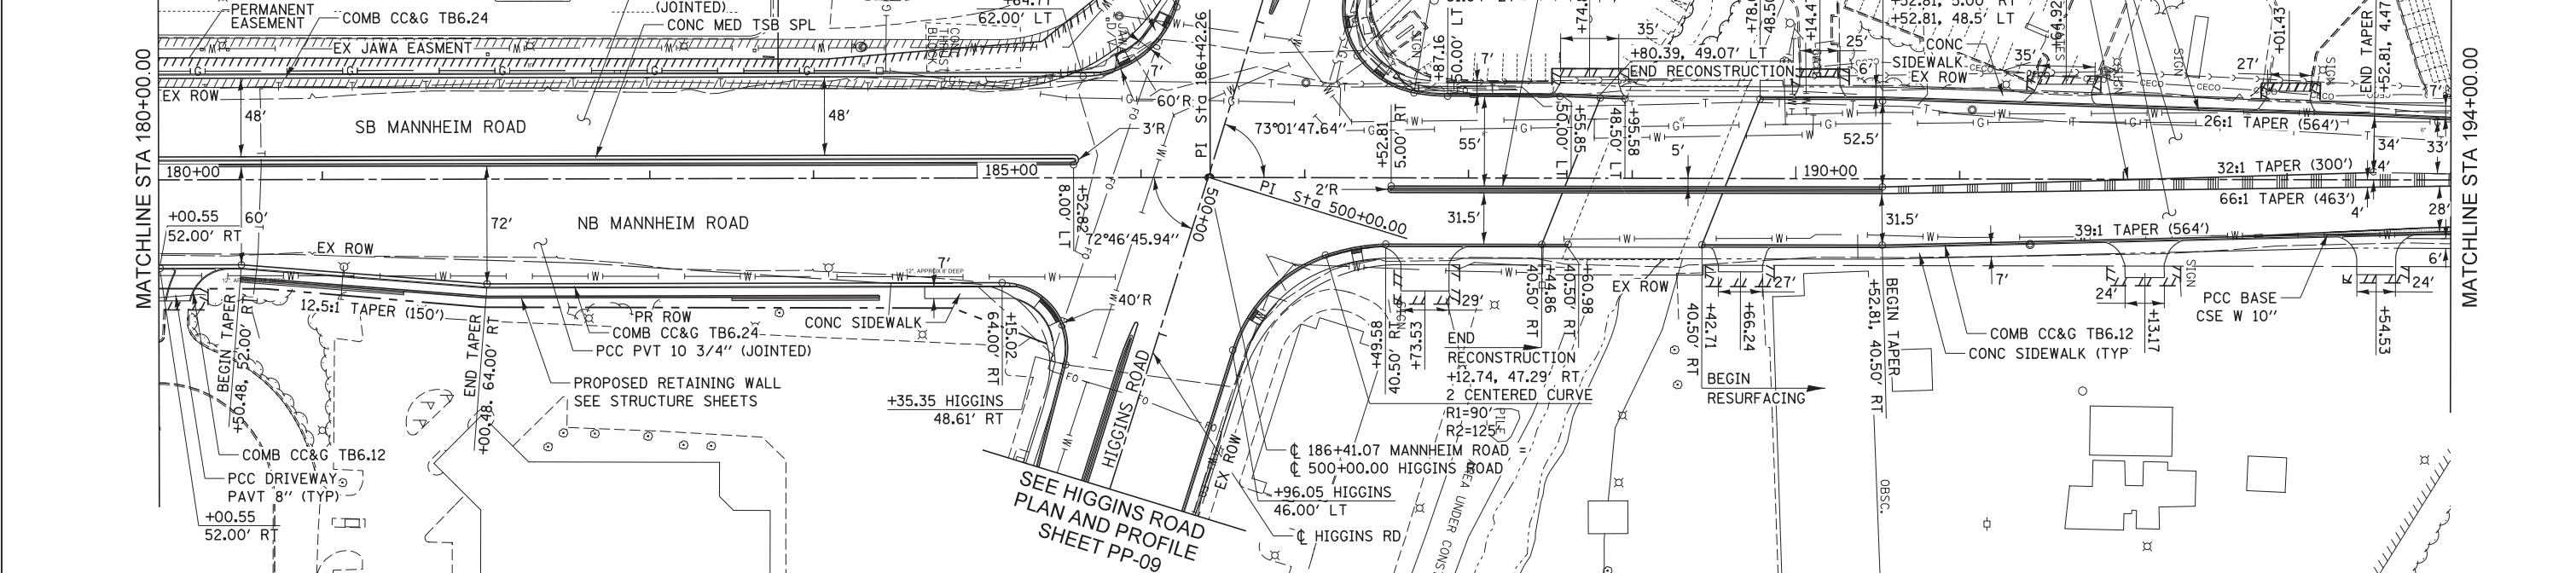

637.74	637.90	638.02	638.05	638.31	638.22	638.59	638.39	638.88	638.59	639.16	638.75	639.45	638.88	639.73	639.03	640.02	639.18	640.29	639.33	640.43	639.56	640.42	639.71	640.27	639.86	640.12	639.61	639.96	639.67	639.81	639.49	639.65	639.46	639.50	639.49	639.29	639.23	639.13	638.97	638.96	638.94	638.96	638.97	638.92	638.87
180+00	181+00	182+00	183+00	184+00	185+00	186+00	187+00	188+00	189+00	190+00	191+00	192+00	193+00	194+00	PP-06																														



USER NAME = micosir	DESIGNED LLS/MMK	REVISED -
	DRAWN MMK	REVISED -
PLOT SCALE = 50:1	CHECKED LLS	REVISED -
PLOT DATE = 23-OCT-2012	DATE 10/19/12	REVISED -

STATE OF ILLINOIS
DEPARTMENT OF TRANSPORTATION

SCALE: 1" = 50'	SHEET NO. 6 OF 10 SHEETS	STA. 180+00.00 TO STA. 194+00.00
-----------------	--------------------------	----------------------------------

F.A.P. RTE. 330	SECTION 0105-WRS	COUNTY COOK	TOTAL SHEETS 537	SHEET NO. 65
CONTRACT NO. 60P35			ILLINOIS FED. AID PROJECT	