


**NOTES:**

1. IDOT CONTRACT 60G37 IS SOUTH OF THIS CONTRACT AND ALL WORK DONE BY OTHERS.

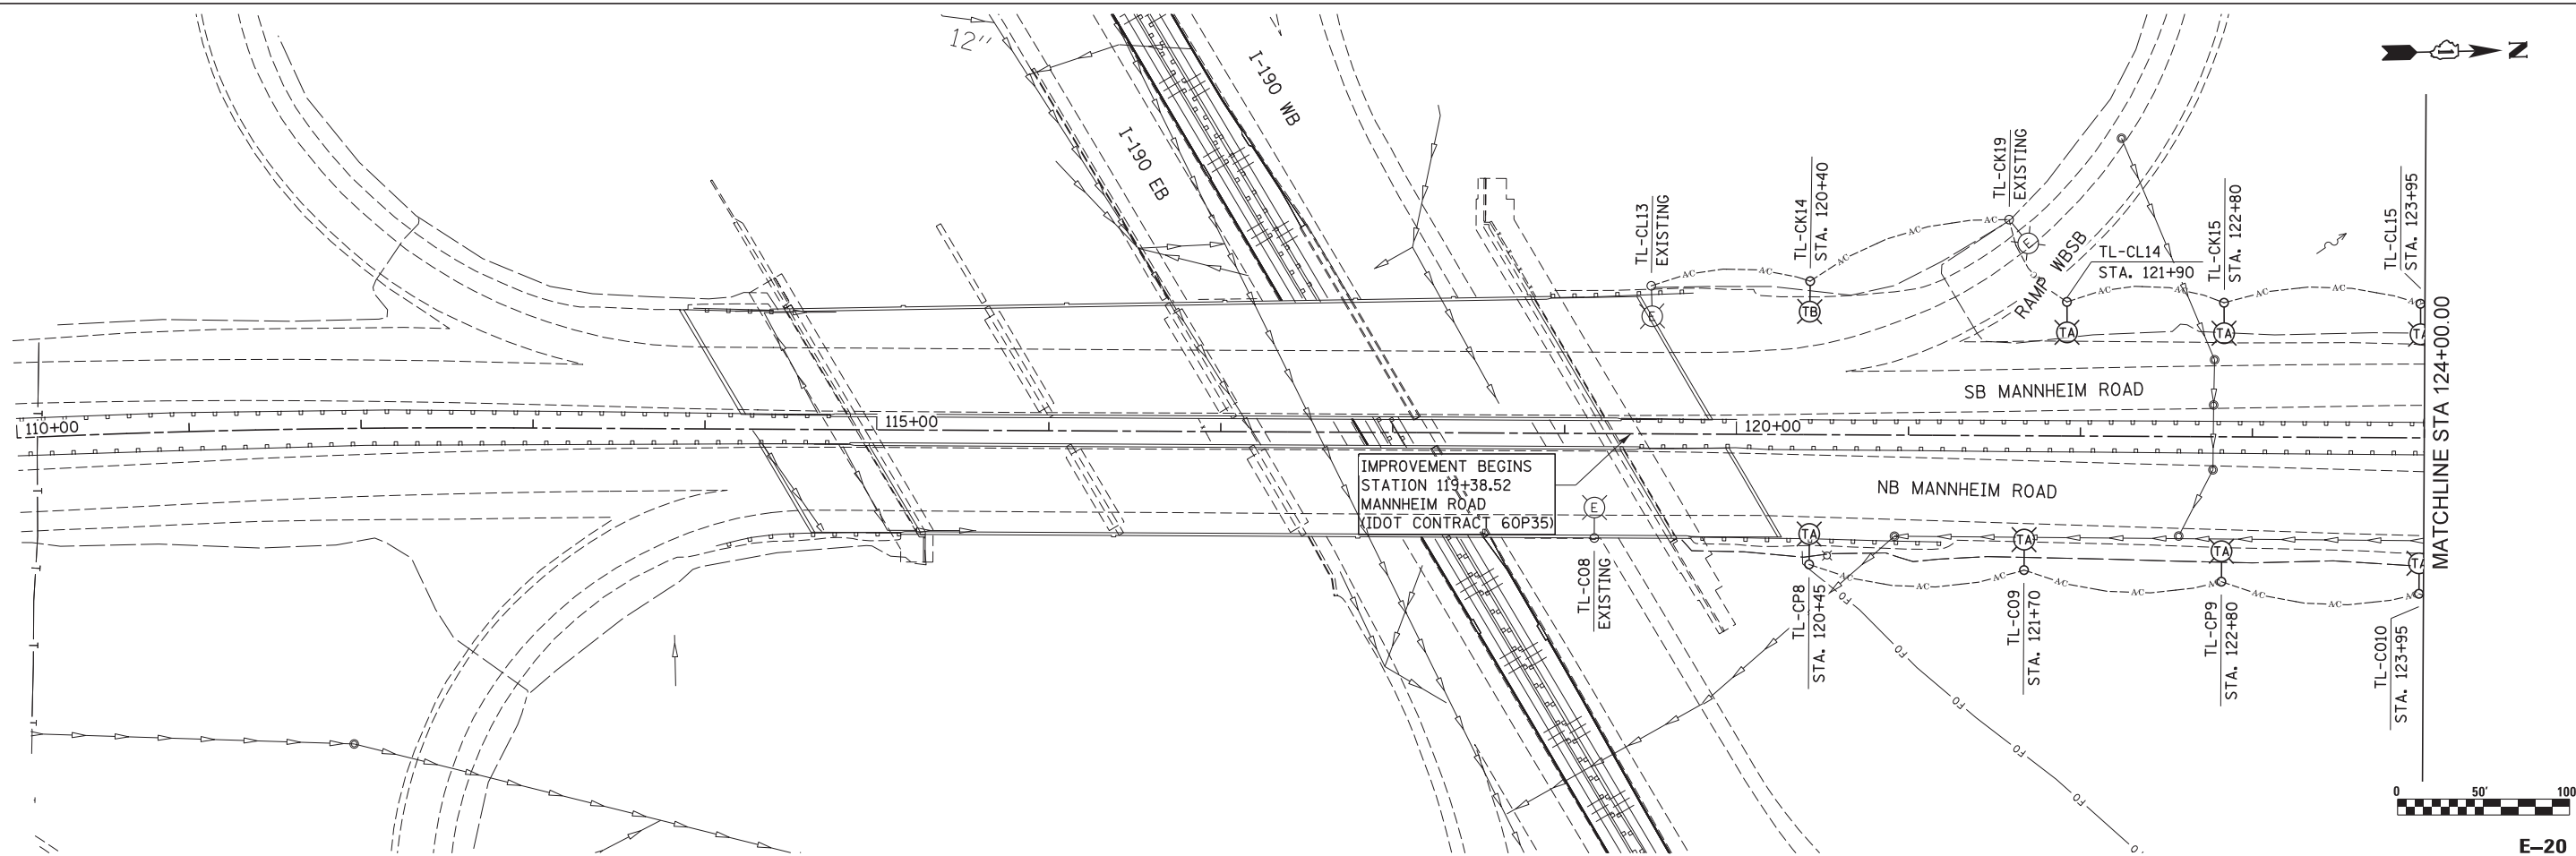

USER NAME = mkosir	DESIGNED KA	REVISED -
	DRAWN MMK	REVISED -
PLOT SCALE = 50:1	CHECKED MCD	REVISED -
PLOT DATE = 23-OCT-2012	DATE 10/19/12	REVISED -

STATE OF ILLINOIS  
DEPARTMENT OF TRANSPORTATION

**TEMPORARY LIGHTING PLAN  
PRESTAGE  
MANNHEIM ROAD**

SCALE: 1" = 50' SHEET NO. 1 OF 5 SHEETS STA. BOP TO STA. 124+00.00

F.A.P. RTE. 330	SECTION 0105-WRS	COUNTY COOK	TOTAL SHEETS 537	SHEET NO. 284
CONTRACT NO. 60P35				
ILLINOIS FED. AID PROJECT				

E-20