



TYPICAL SPLICE DETAIL

N.T.S.

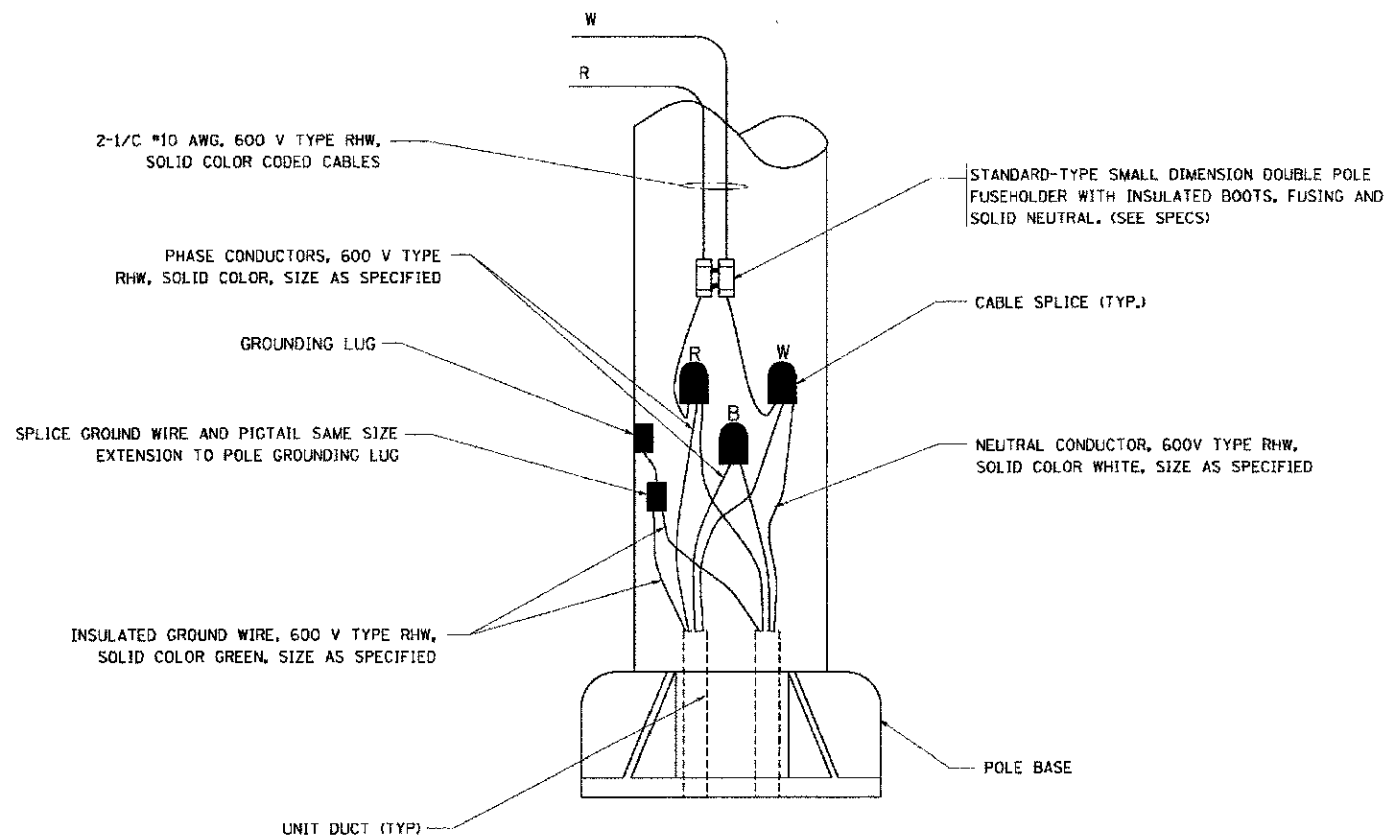

POLE WIRING DETAIL

N.T.S.

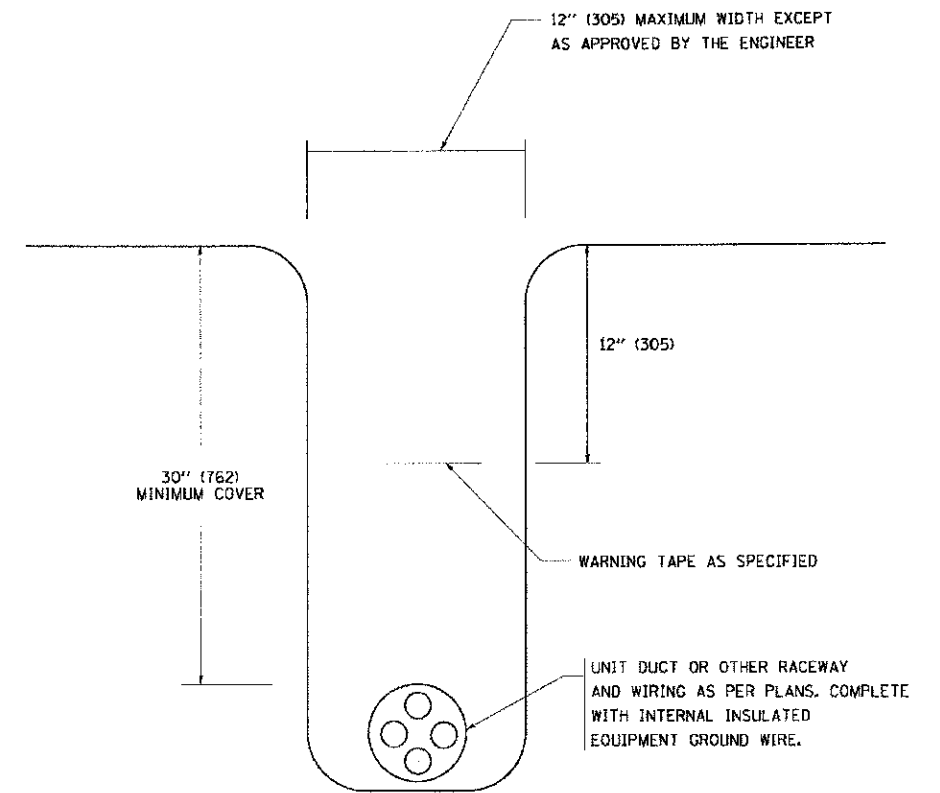

TYPICAL WIRING IN TRENCH DETAIL

N.T.S.

FILE NAME: L:\PROJECTS\122481\Drawings\CADD\Sheet\Lighting_4.dwg



USER NAME = Jeff Sedig	DESIGNED - MNB	REVISED -
	DRAWN - MNB	REVISED -
PLOT SCALE = 1/8" = 1'-0"	CHECKED - CMC	REVISED -
PLOT DATE = 11/12/2012	DATE = 10/22/2012	REVISED -

STATE OF ILLINOIS
DEPARTMENT OF TRANSPORTATION

LIGHTING AND CCTV PLAN
ELECTRICAL DETAILS

SCALE: N.T.S. SHEET NO. 4 OF 9 SHEETS STA. N/A TO STA. N/A

F.A.U. RTE. 0192	SECTION 06-00153-07-CH	COUNTY LAKE	TOTAL SHEETS 120	SHEET NO. 51
CONTRACT NO. 63682				
FED. ROAD DIST. NO. ILLINOIS FED. AID PROJECT				