
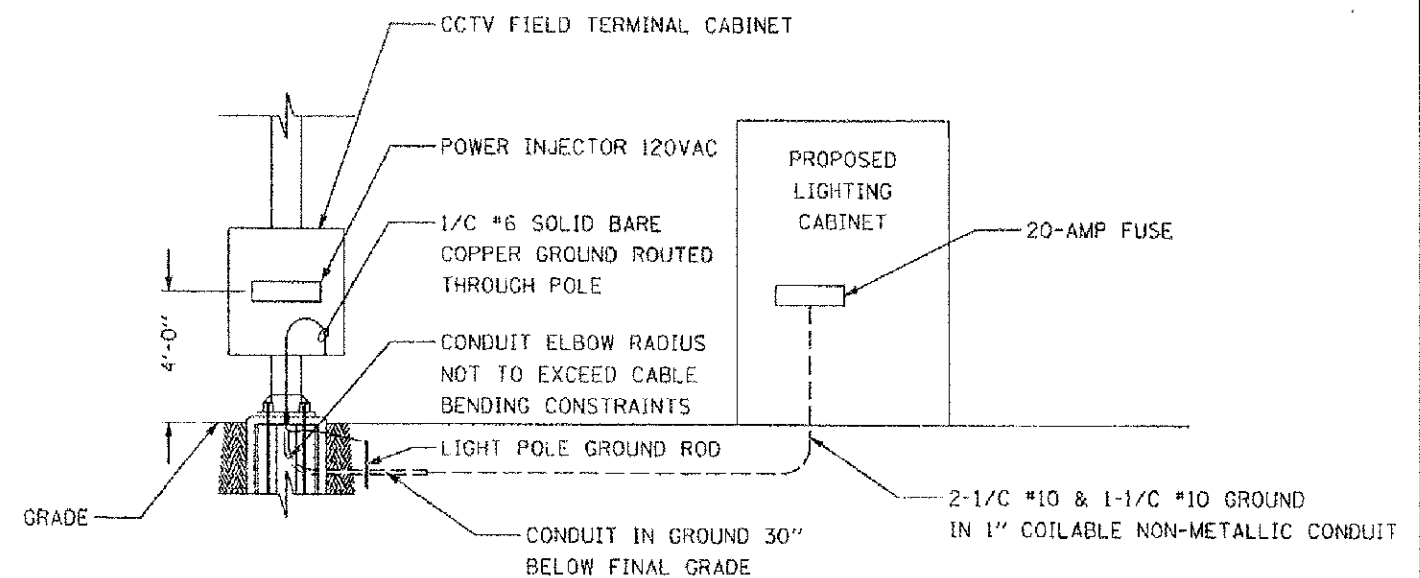


WIRELESS ANTENNA, RADIO, AND DOME (PTZ) CAMERA MOUNTING DETAIL

(NOT TO SCALE)

NOTES:

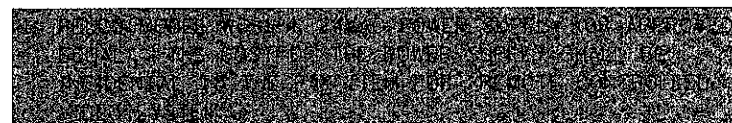

CAMERA, WIRELESS ANTENNA, AND RADIO INSTALLATION ON CAMERA MOUNTING ASSEMBLY DETAIL

(NOT TO SCALE)

FILE NAME = L:\LAKED\112248\1\Dr-04-CADD-Sheets\Lighting_6_detail_4.dgn



USER NAME = Jeff Sadig	DESIGNED - MNB	REVISED -
PLLOT SCALE = 40,0000' / 1"	DRAWN - MNB	REVISED -
PLLOT DATE = 11/12/2012	CHECKED - CMC	REVISED -
	DATE - 10/22/2012	REVISED -

**STATE OF ILLINOIS
DEPARTMENT OF TRANSPORTATION**

**LIGHTING AND CCTV PLAN
PTZ CAMERA AND WIRELESS TRANSMISSION DETAILS**

SCALE: N.T.S. SHEET NO. 6 OF 9 SHEETS STA. N/A TO STA. N/A

F.A.U. RTE.	SECTION	COUNTY	TOTAL SHEETS	SHEET NO.
0192	06-00153-07-CH	LAKE	120	53
FED. ROAD DIST. NO.			ILLINOIS FED. AID PROJECT	
			CONTRACT NO. 63682	