


FOR LEGEND AND NOTES
SEE SHEET 48

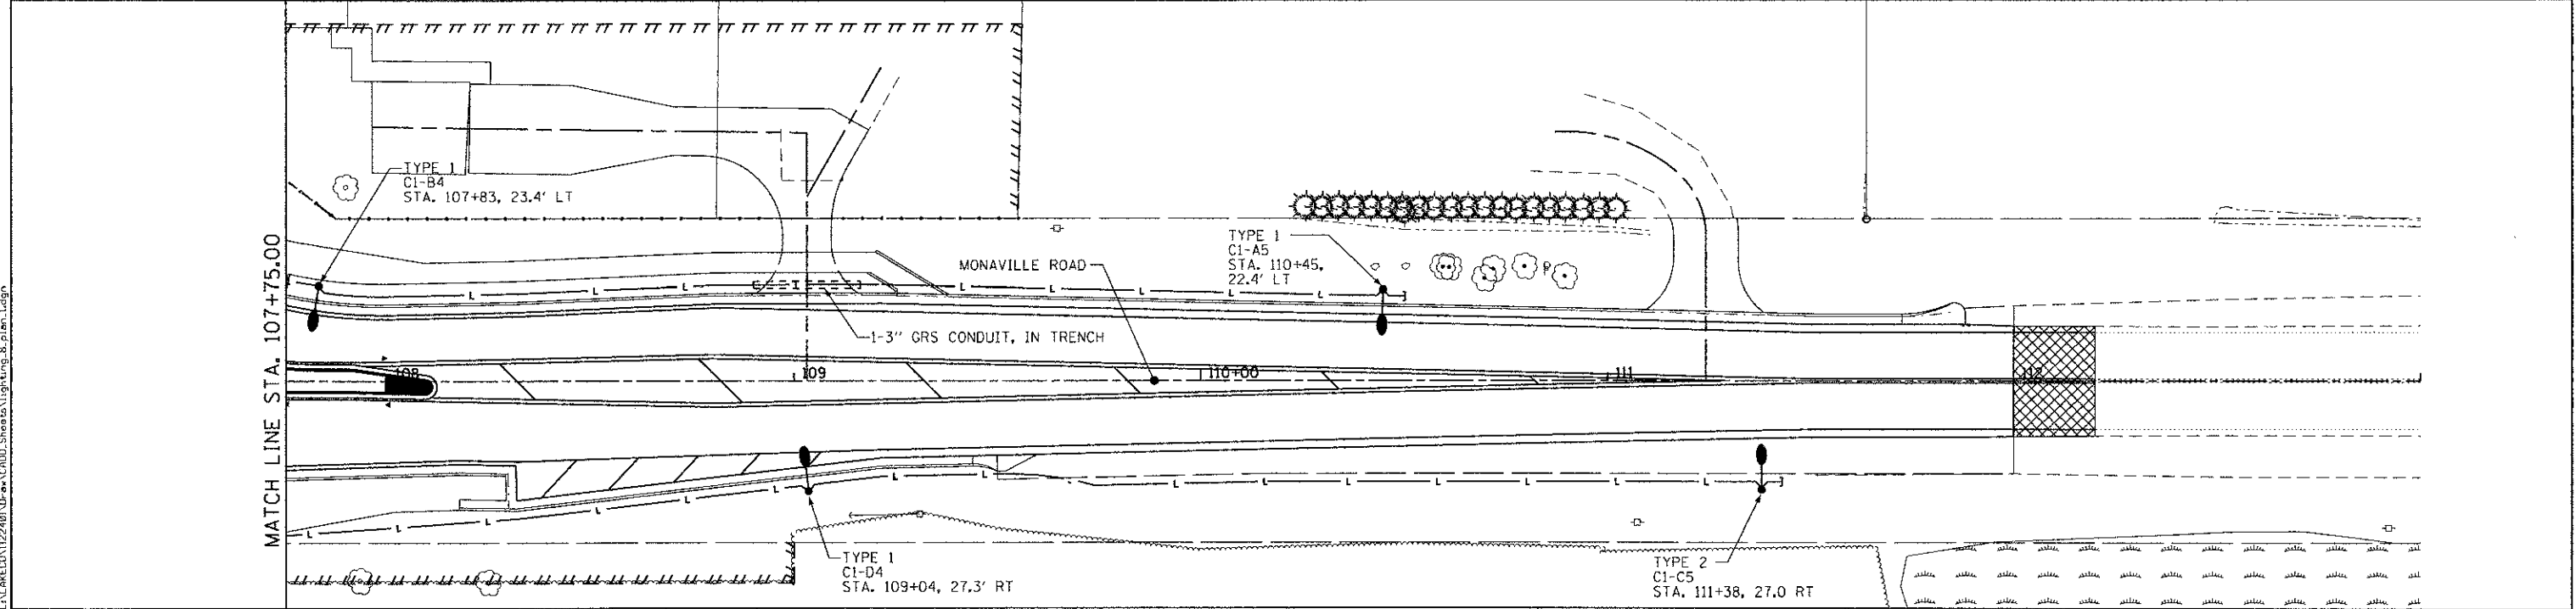

FILE NAME = L:\ALAMEDA\122481\Draws\Road_Sheets\Lighting_8_plan.Ldgn

	USER NAME = Jeff Sedig	DESIGNED - MNB	REVISED -	STATE OF ILLINOIS DEPARTMENT OF TRANSPORTATION	LIGHTING AND CCTV PLAN ROADWAY LIGHTING PLAN		F.A.I. RTE.	SECTION	COUNTY	TOTAL SHEETS	SHEET NO.
	PLOT SCALE = 40,0000 1/4 in.	DRAWN - MNB	REVISED -				0192	06-00153-07-CH	LAKE	120	55
	PLOT DATE = 11/12/2012	CHECKED - CMC	REVISED -				CONTRACT NO. 63682				
	DATE = 10/22/2012	REVISED -		SCALE:		SHEET NO. 8 OF 9 SHEETS		STA. TO STA.		FED. ROAD DIST. NO. ILLINOIS FED. AID PROJECT	