



RANDHURST SHOPPING CENTER

LEGEND:

- STORM SEWER
- STORM SEWER INLET
- STORM SEWER CATCH BASIN
- STORM SEWER MANHOLE
- SANITARY SEWER
- SANITARY SEWER MAN HOLE
- WATERMAIN
- VALVE VAULT

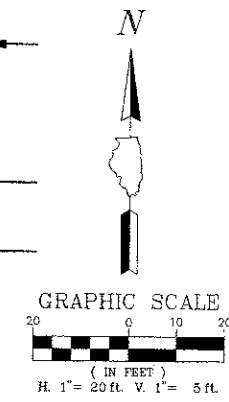


MATCH LINE STA. 206+00
SEE SHEET 52

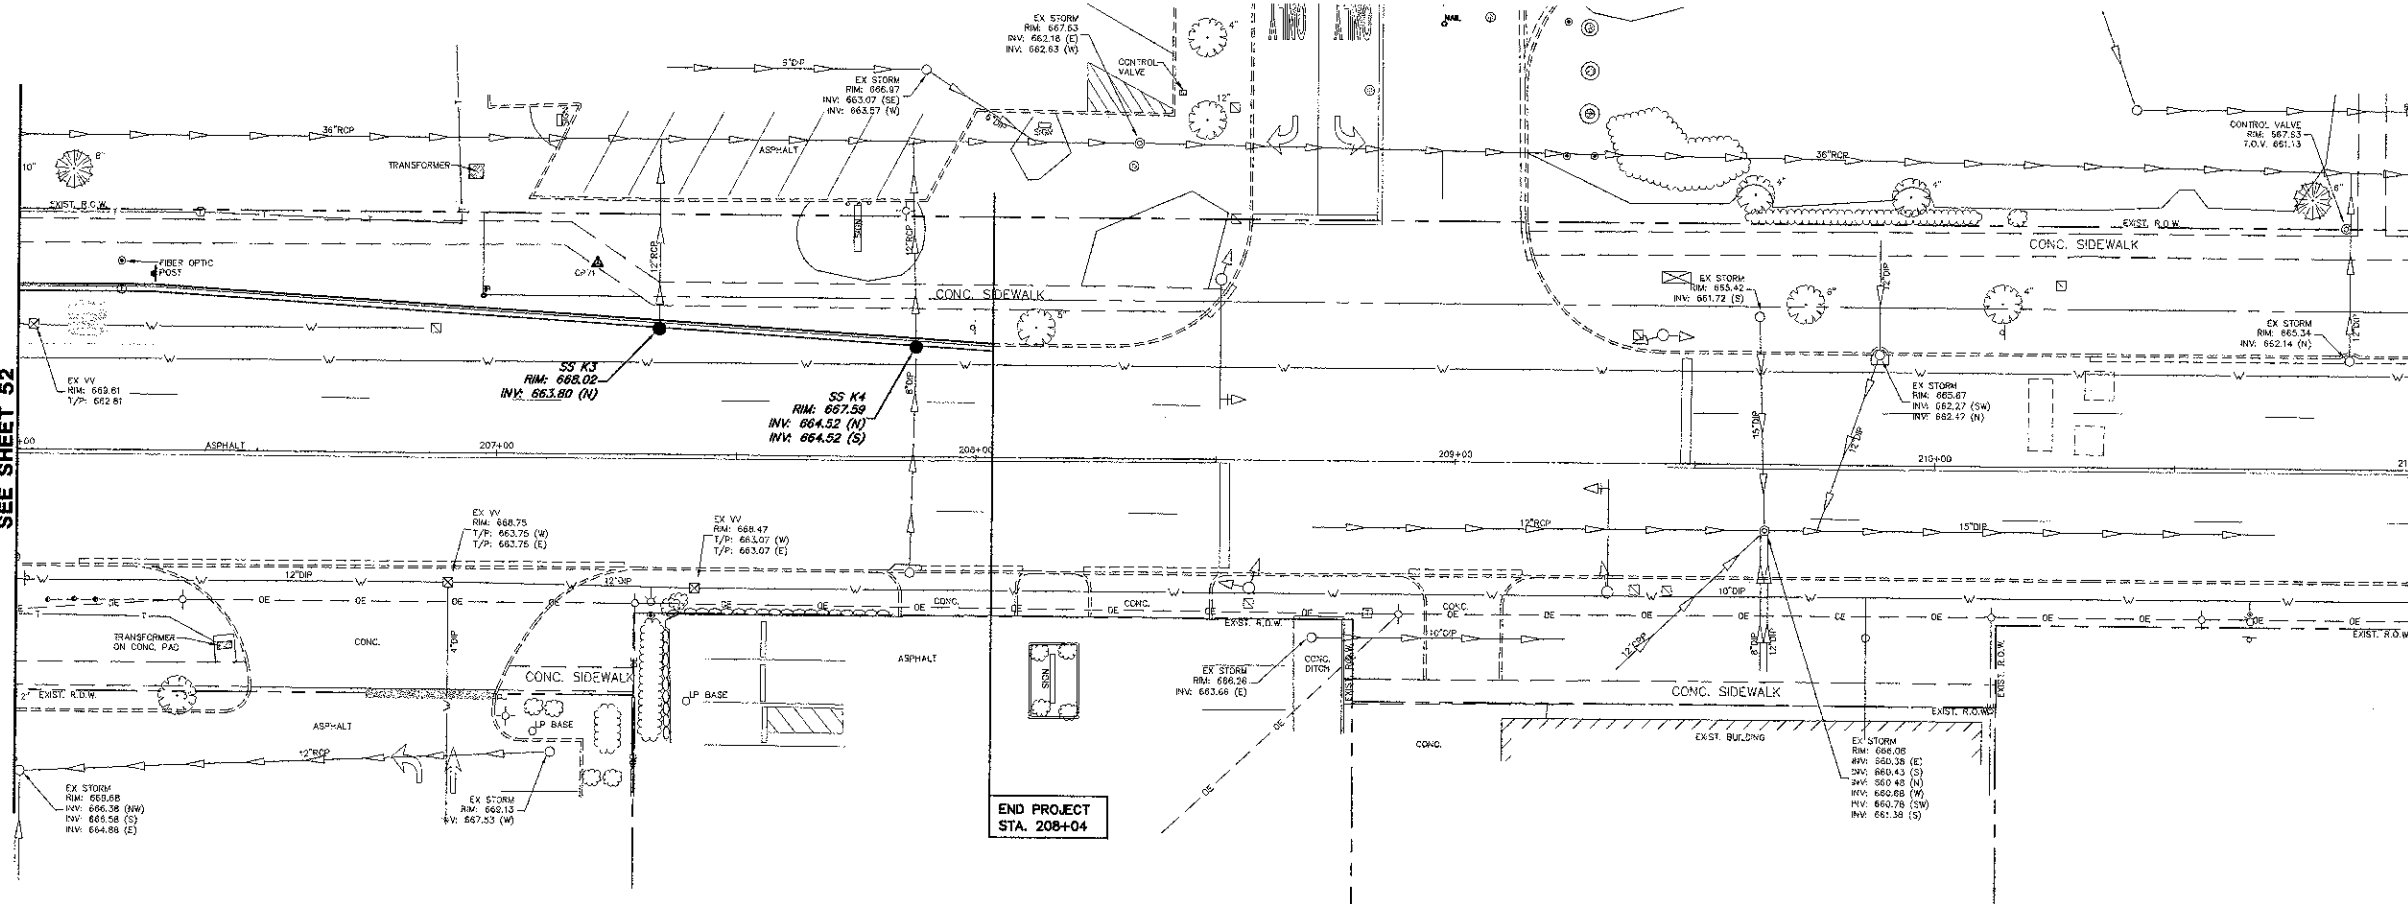

END PROJECT
STA. 208+04

STORM STRUCTURES		
STRUCTURE #	TYPE	FRAME & GRATE
SS K3	CB TYPE C	TYPE 23 FR & GR
SS K4	CB TYPE C	TYPE 23 FR & GR

WEST KENSINGTON ROAD

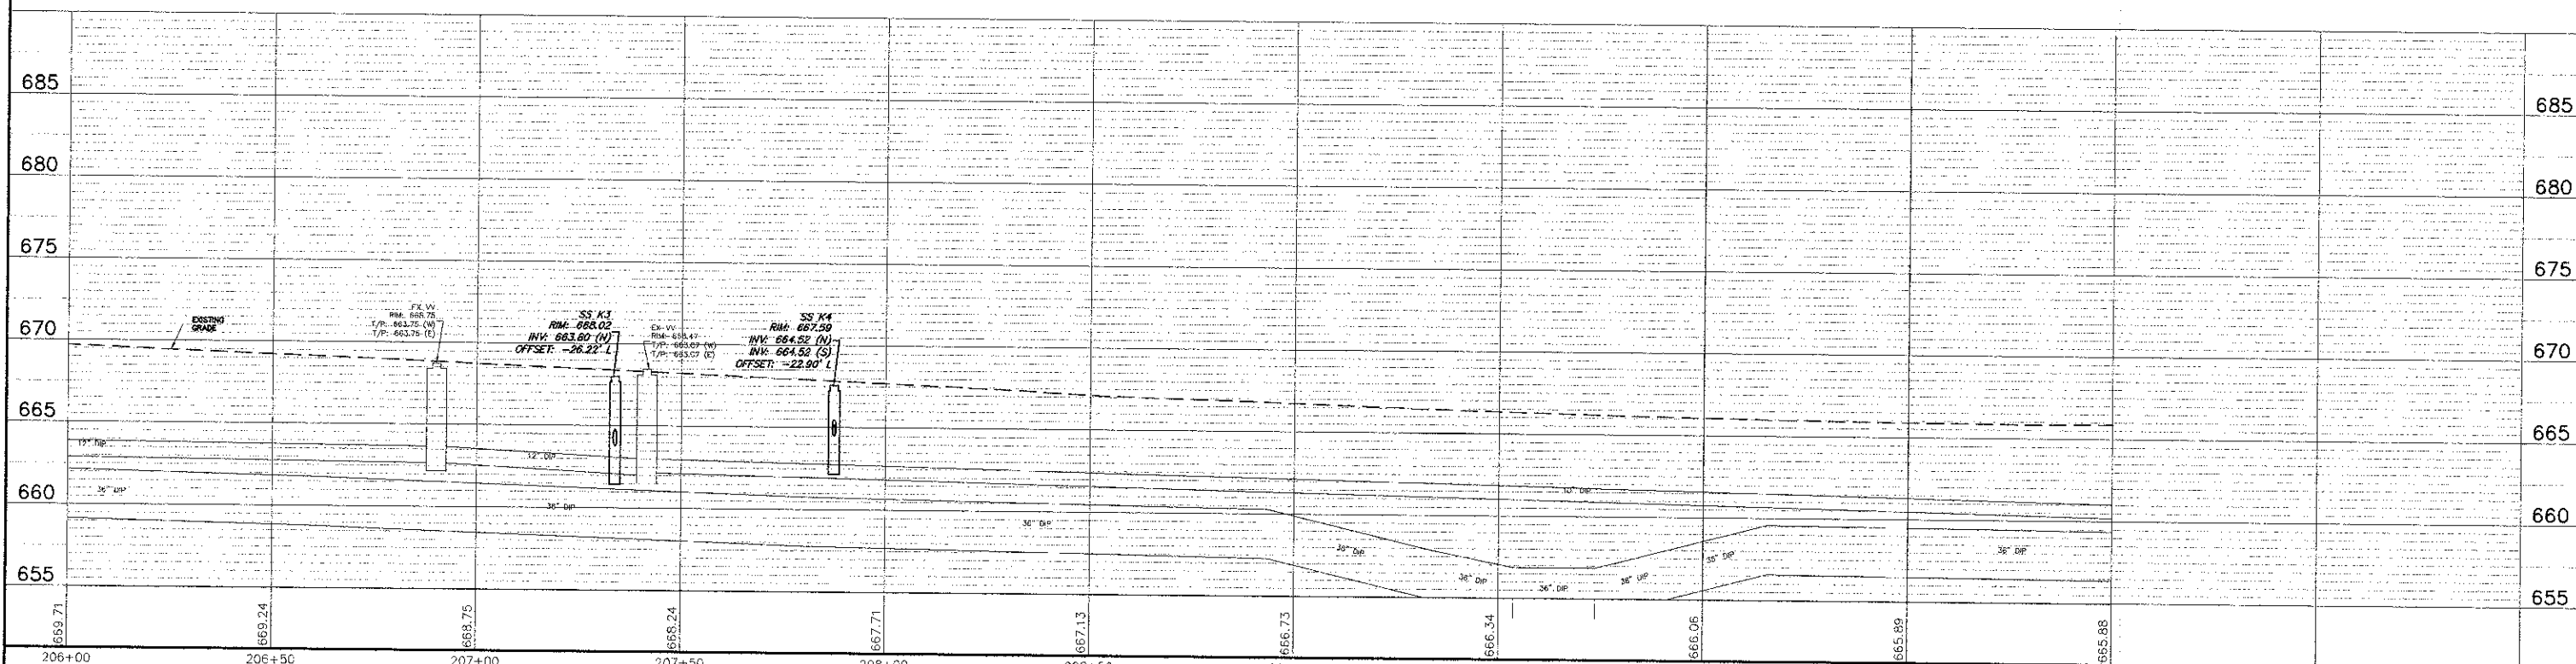

FILE NAME = 4185.B00-PR3.dwg	USER NAME = PAUL SWIATEK	DESIGNED - BVS	REVISED -	STATE OF ILLINOIS DEPARTMENT OF TRANSPORTATION	DRAINAGE AND UTILITY - PLAN AND PROFILE KENSINGTON ROAD IMPROVEMENTS	FAU RTE. 1295	SECTION 09-00154-00-PV	COUNTY COOK	TOTAL SHEETS 119	SHEET NO. 53	
PLOT SCALE = 1" = 08'	CHECKED - KLB	REVISIONS	REVISIONS			SCALE 1"=20'	SHEET NO. OF SHEETS	STA. 201+00 TO STA. 206+00	CONTRACT # 63746	ILLINOIS FED. AID PROJECT	
PLOT DATE = 10/17/2012	DATE - 10/17/12	REVISIONS	REVISIONS								