



F.A.P. RTE.	SECTION	COUNTY	TOTAL SHEETS	SHEET NO.
322	11-13	CHRISTIAN	437	170
STA.		TO STA.		
FED. ROAD DIST. NO.	ILLINOIS	FED. AID PROJECT		

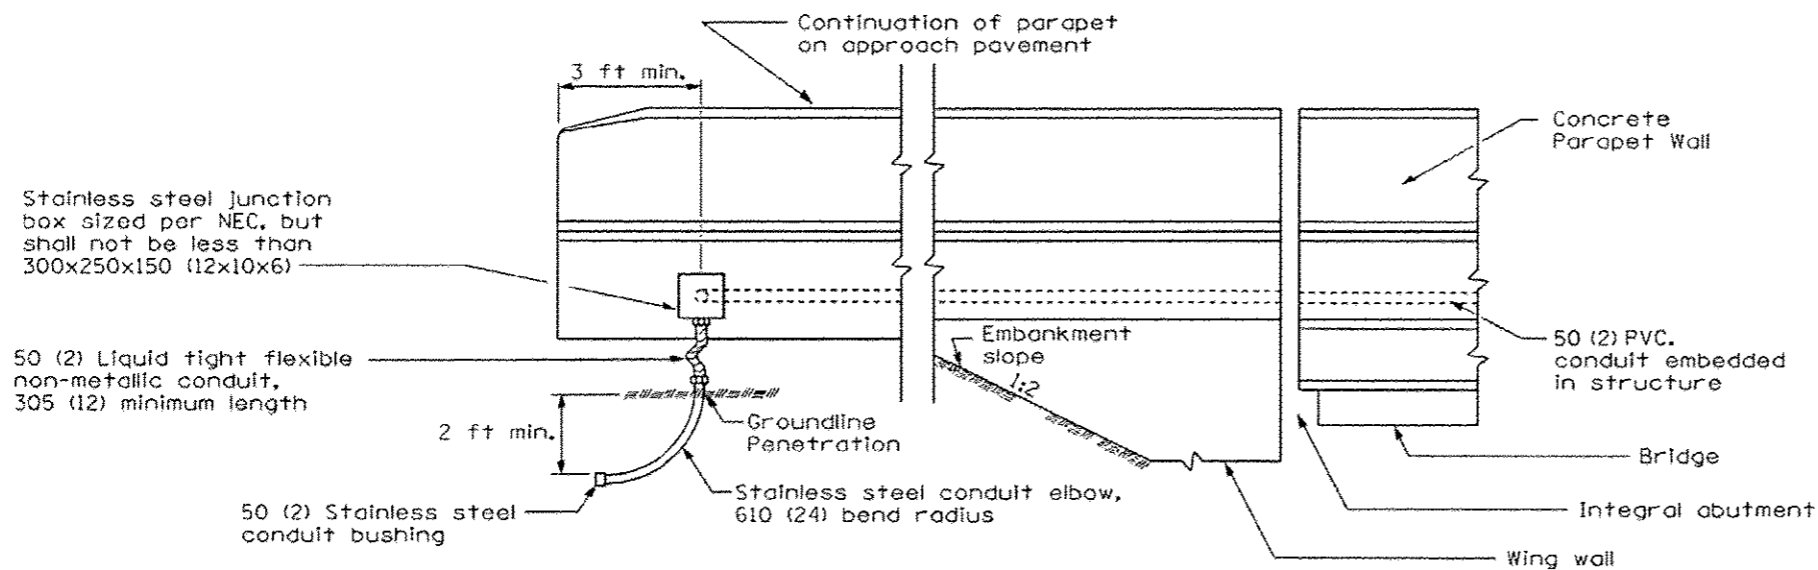

**CONDUIT DETAIL**  
(Integral Abutment)

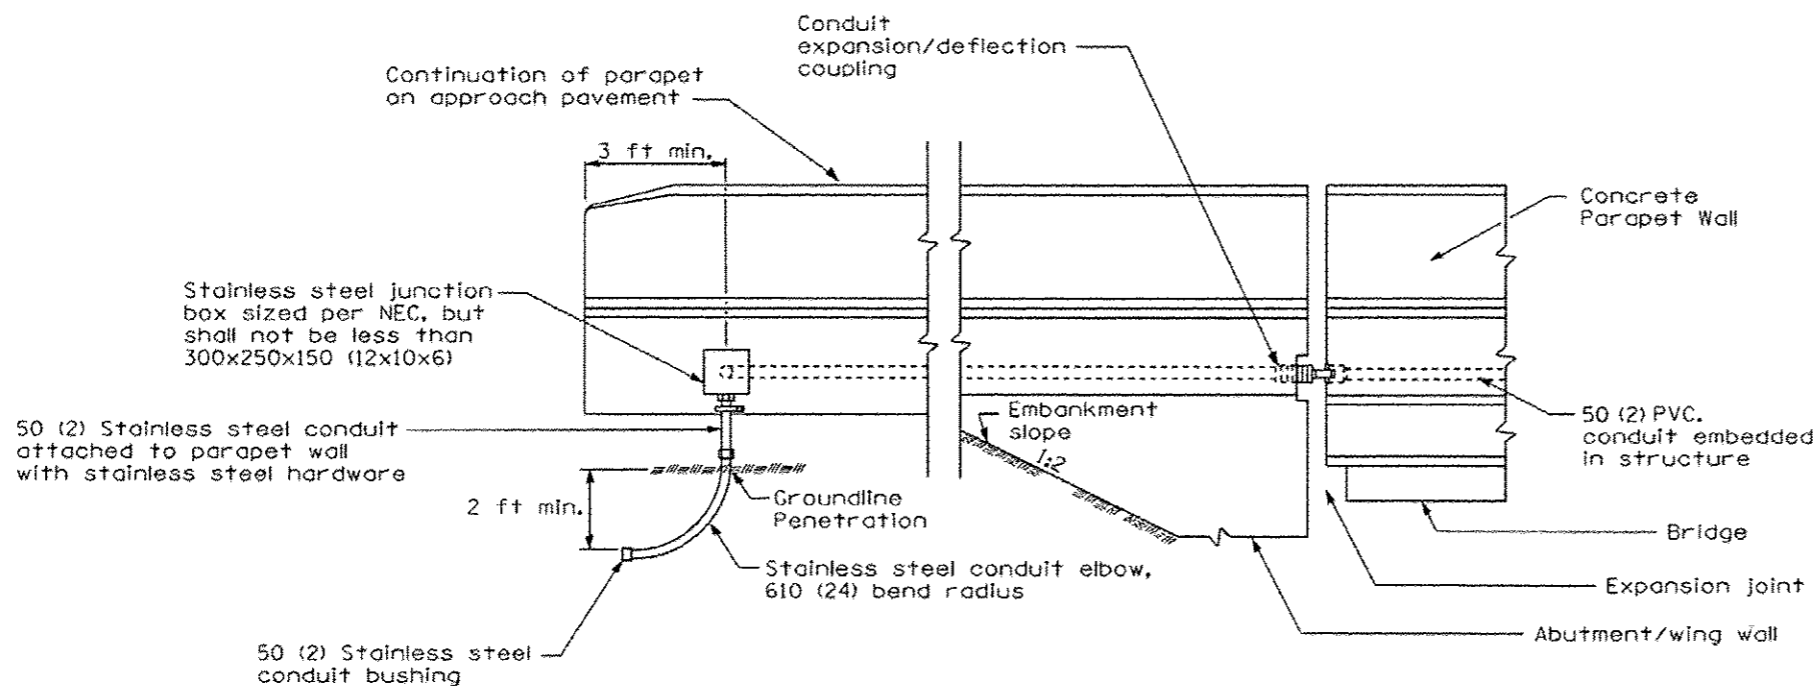

**CONDUIT DETAIL**  
(Open Abutment)

**GENERAL NOTES**

Stainless steel conduit, couplings, and elbows shall be according to Section 810 of the Standard Specifications, as applicable, shall be Type 304 or Type 316, and shall be manufactured according to UL Standard 6A and ANSI Standard C 80.1.

Conduit fittings shall be the threaded type, shall be Type 304 or Type 316 stainless steel, and shall be manufactured according to UL Standard 514B.

All stainless steel and liquid tight flexible non-metallic conduit, including all fittings, bushings, couplings, and elbows shall be included in the cost of the "Junction Box, Stainless Steel, Attached to Structure, 12" X 10" X 6" " pay item.

All dimensions are in millimeters (inches) unless otherwise shown.

REVISIONS	
NAME	DATE
SEB	10/10/12
SEB	11/14/12

ILLINOIS DEPARTMENT OF TRANSPORTATION  
**LIGHTING PLAN -**  
**LIGHTING DETAILS 3 OF 4**  
 FAP 322 (US 51)  
 SECTION 11-13  
 CHRISTIAN COUNTY

SCALE: NONE DRAWN BY IDOT  
 DATE CHECKED BY

CONDUIT - PARAPET ON APPROACH PAVEMENT

11/14/2012

D:\BENTON\BENTON\BENTON\PLANS\NEW\ROAD\Sheet\11-13\Lighting\3-11-13.dwg